



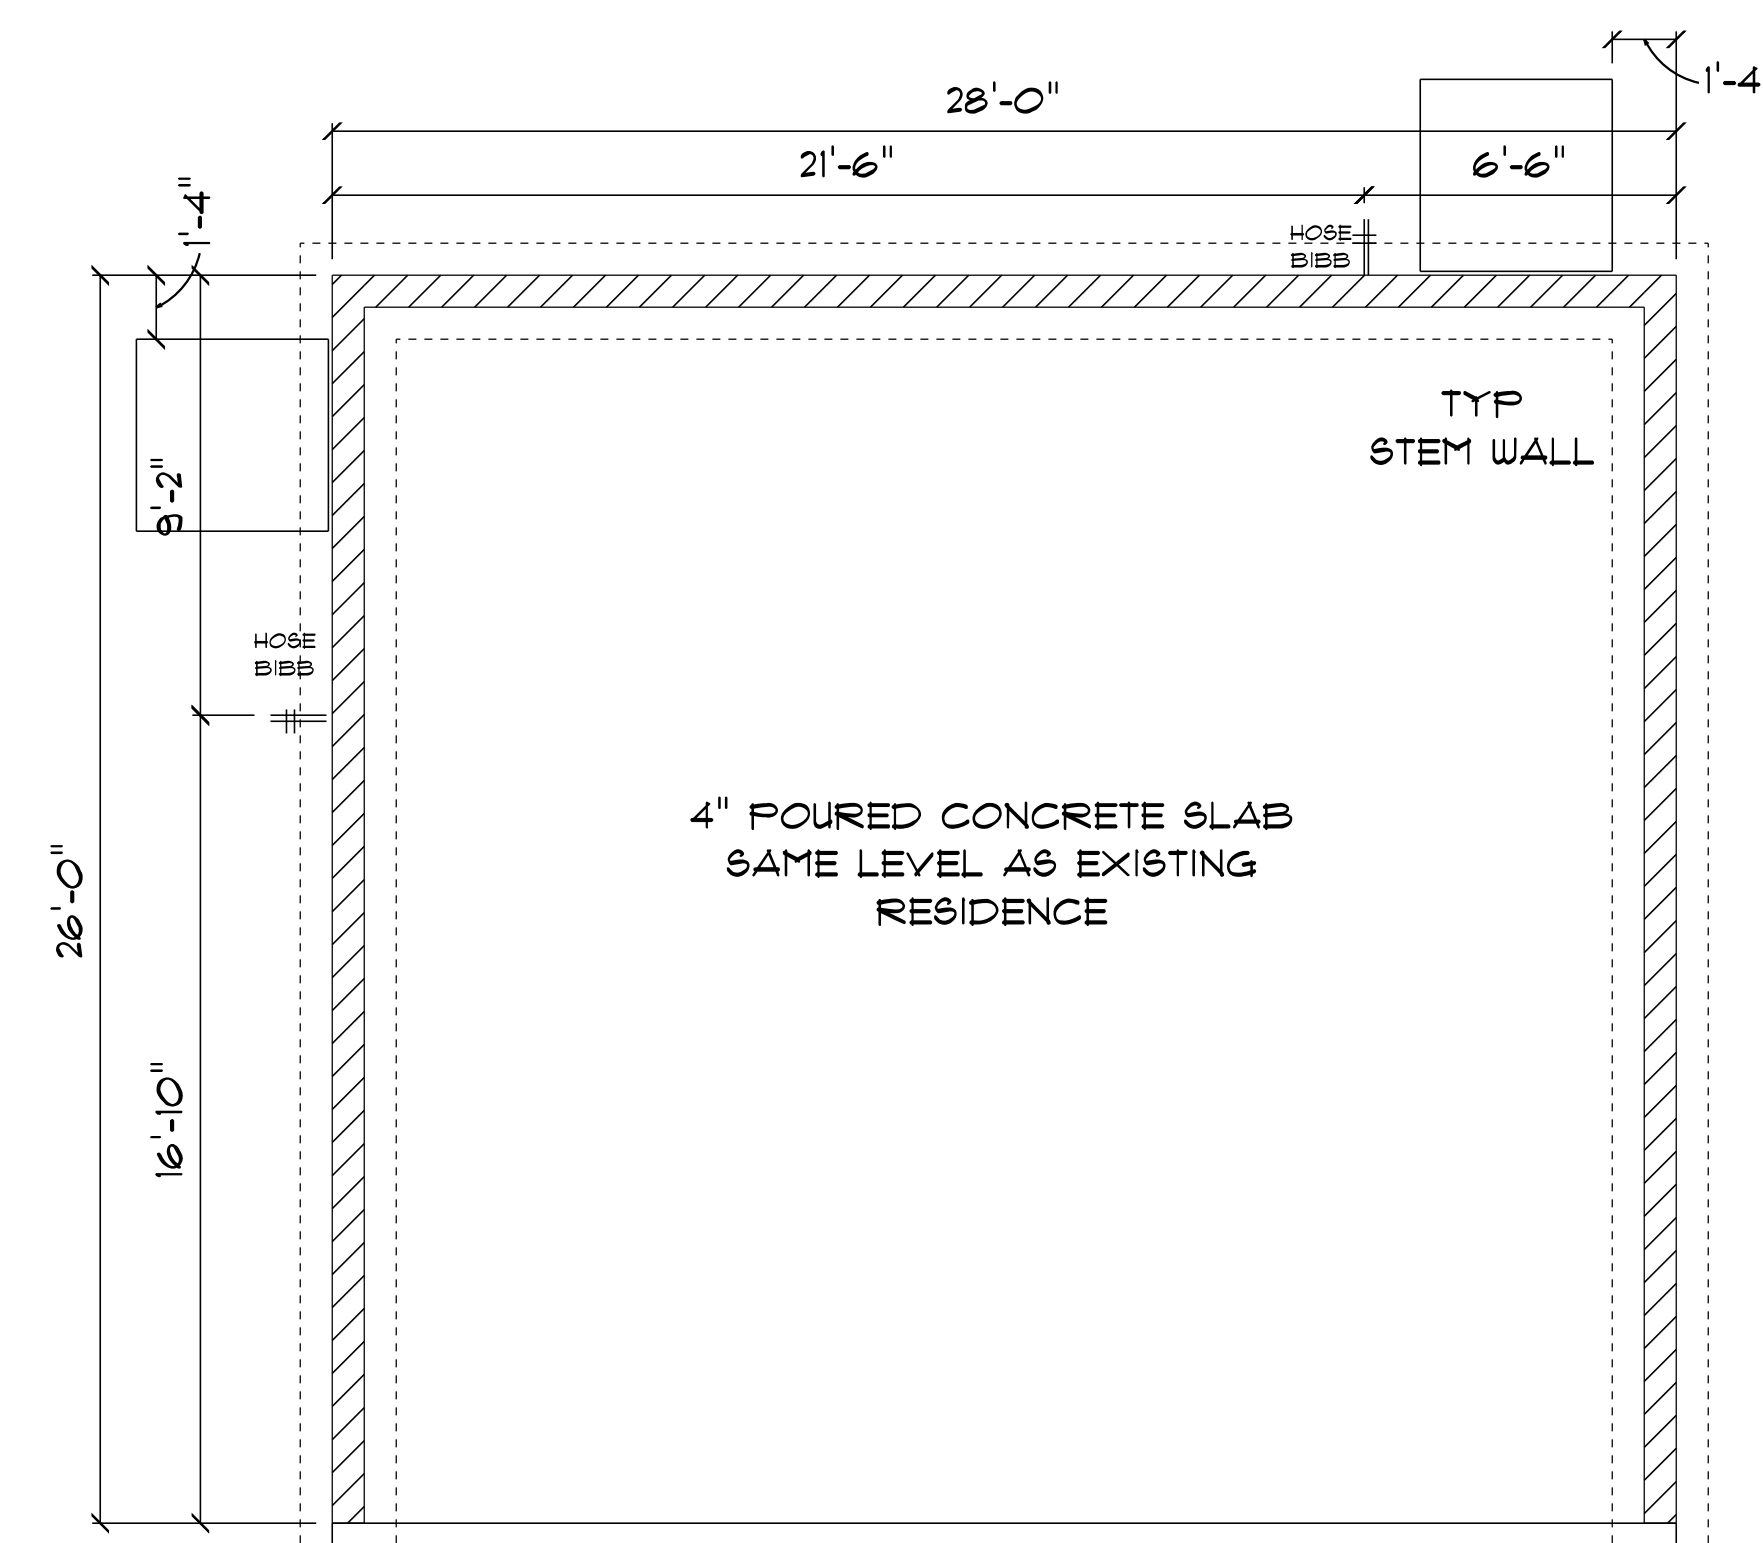


*** PROPOSED PARTIAL ***
*** FOUNDATION PLAN ***
 SCALE = 1/4" = 1'-0"

IMPORTANT NOTE:
 1. IT IS THE BUILDERS RESPONSIBILITY TO VERIFY ALL GEOMETRY AND DIMENSIONS BEFORE ORDERING ANY MATERIALS OR BEGINNING CONSTRUCTION.
 2. THESE PLANS ARE FOR LAYOUT AND DESIGN PURPOSES ONLY ALL STRUCTURAL NOTES AND DETAILS TO BE PROVIDED BY AN ENGINEER.

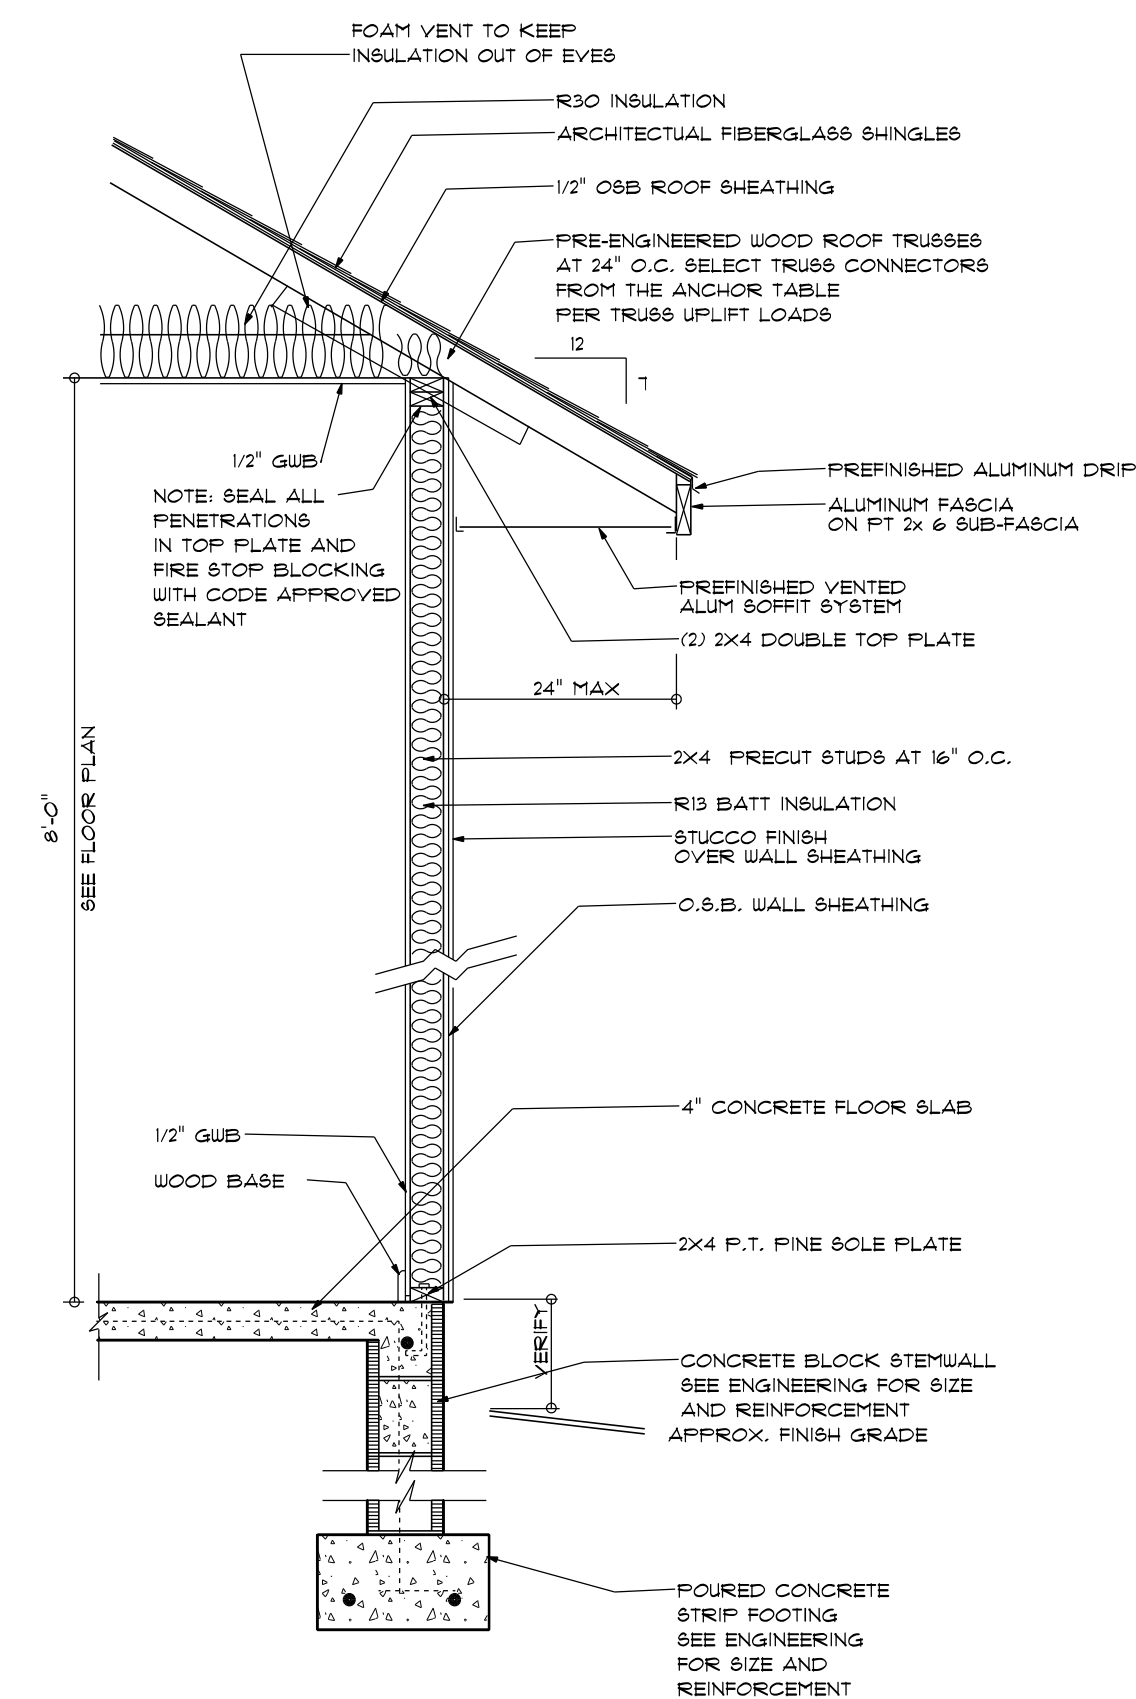

TYPICAL DESIGN WALL SECTION
NON - STRUCTURAL DATA
 N.T.S.

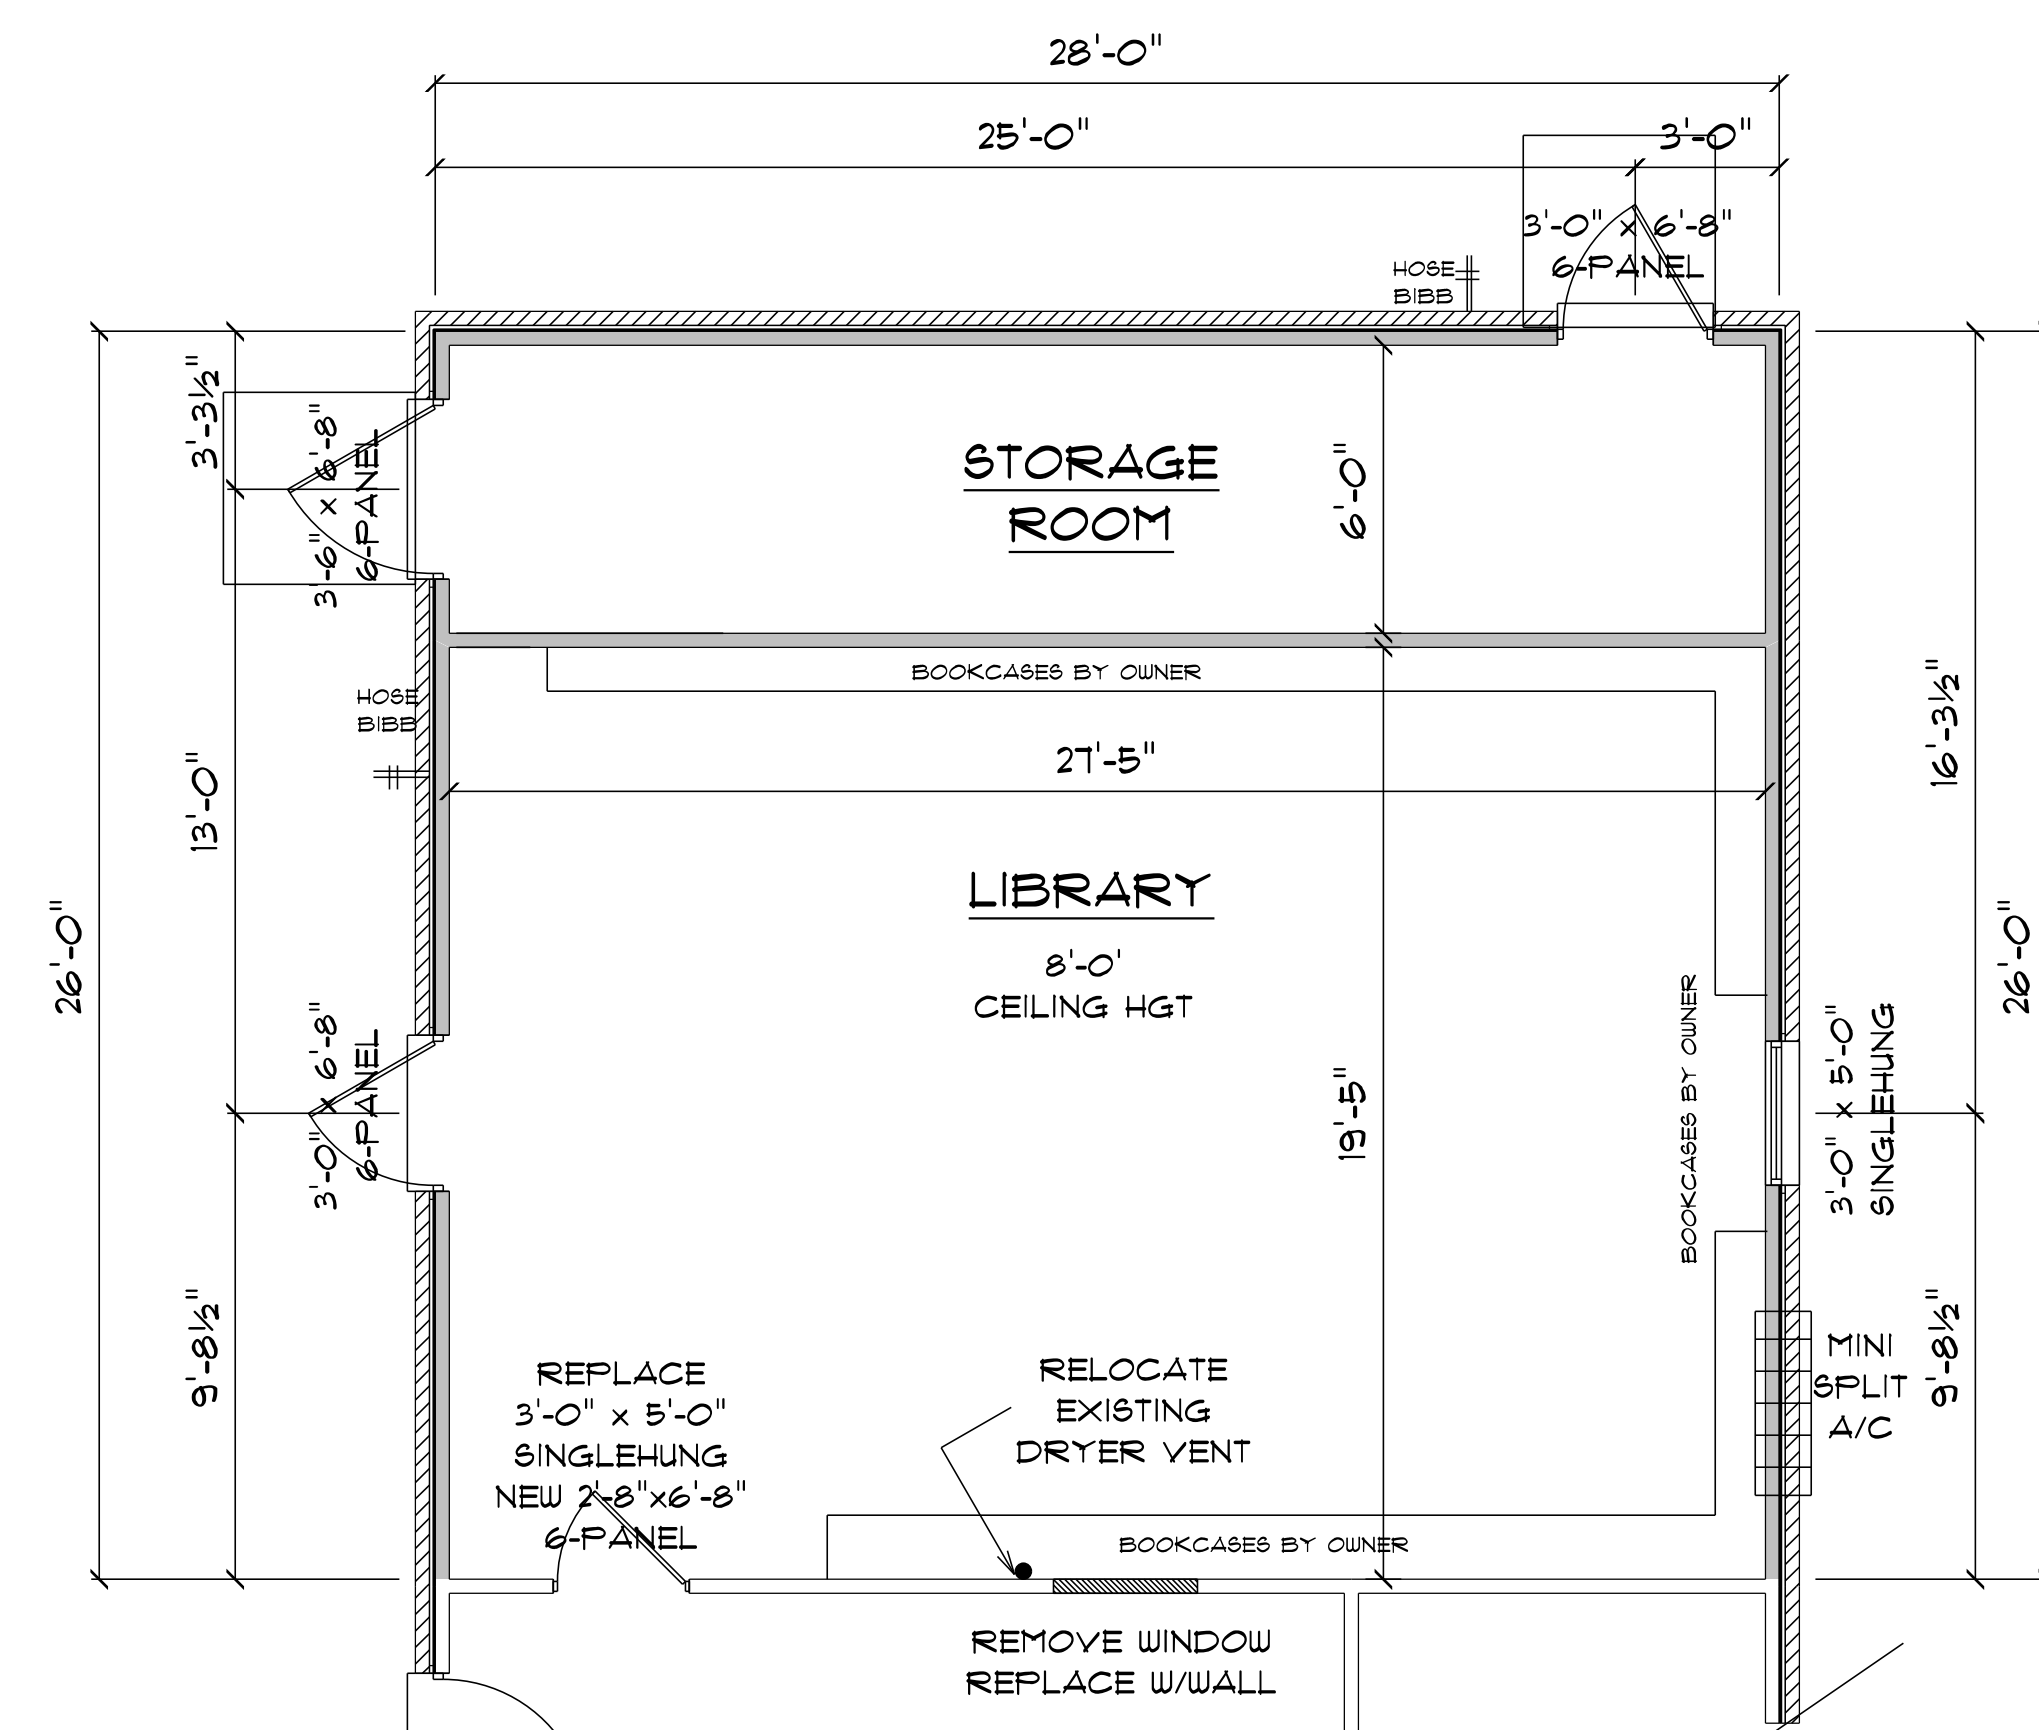

*** PROPOSED PARTIAL ***
*** FLOOR PLAN ***
 SCALE = 1/4" = 1'-0"

NEW A/C AREA = 544 S.F.
 NEW NON A/C STORAGE AREA = 184 S.F.
 TOTAL NEW AREA UNDER ROOF = 728 S.F.

ADDITION
for
BOB & LANE
DEKLE

283 SW LOBLOLLY PL
 LAKE CITY, FLORIDA

Teresa M. Rufo
 2925 SW SR 47
 Lake City Florida, 32025
 Cell: (386) 867-1191
 Email: terarufot@gmail.com

PRINTED DATE:
 Thursday, June 25, 2020


DRAWN BY: Teresa M. Rufo
 CHECKED BY:

BUILDING CONTRACTOR

FINALS DATE:

JOB NUMBER:

DRAWING NUMBER
A-1
 OF 2 SHEETS

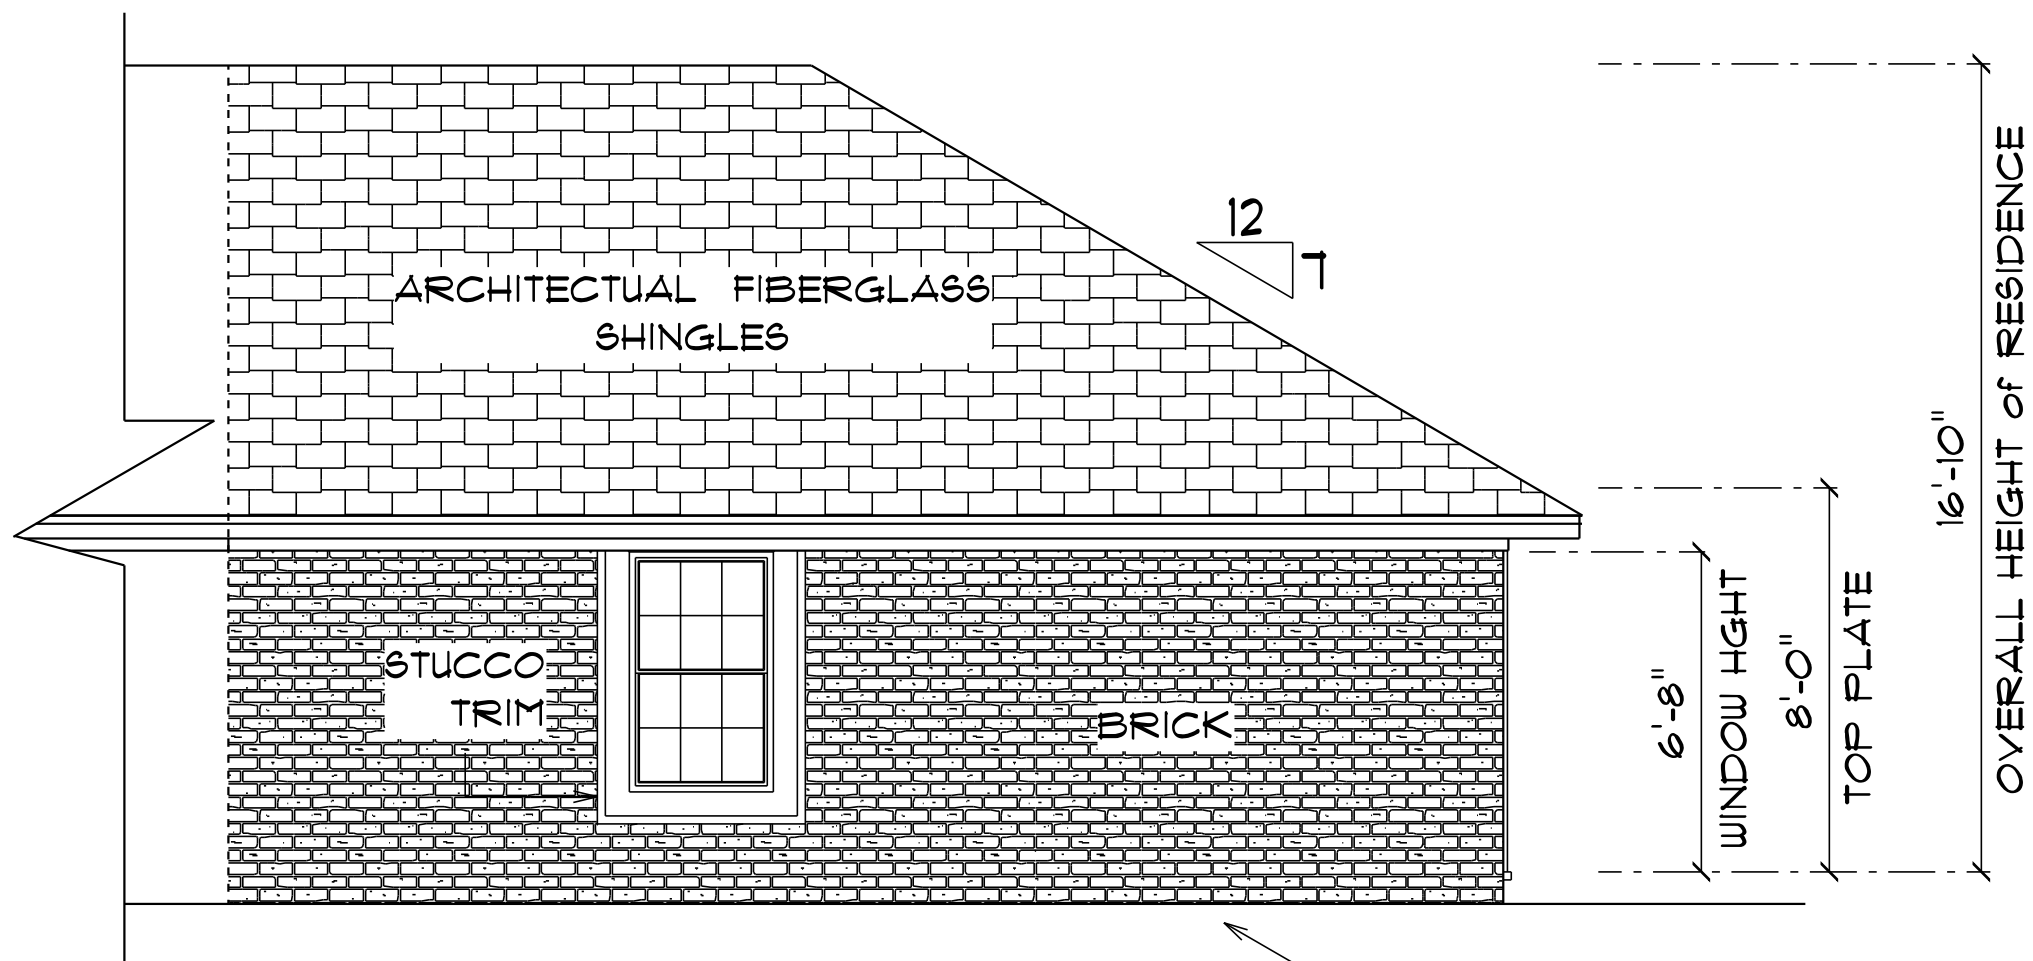


* PARTIAL *
* RIGHT SIDE ELEVATION *

NOTE:
24" OVERHANG ON GABLE ENDS


SCALE : 3/16" = 1'-0"

NOTE:
ALL FINISHES TO MATCH EXISTING

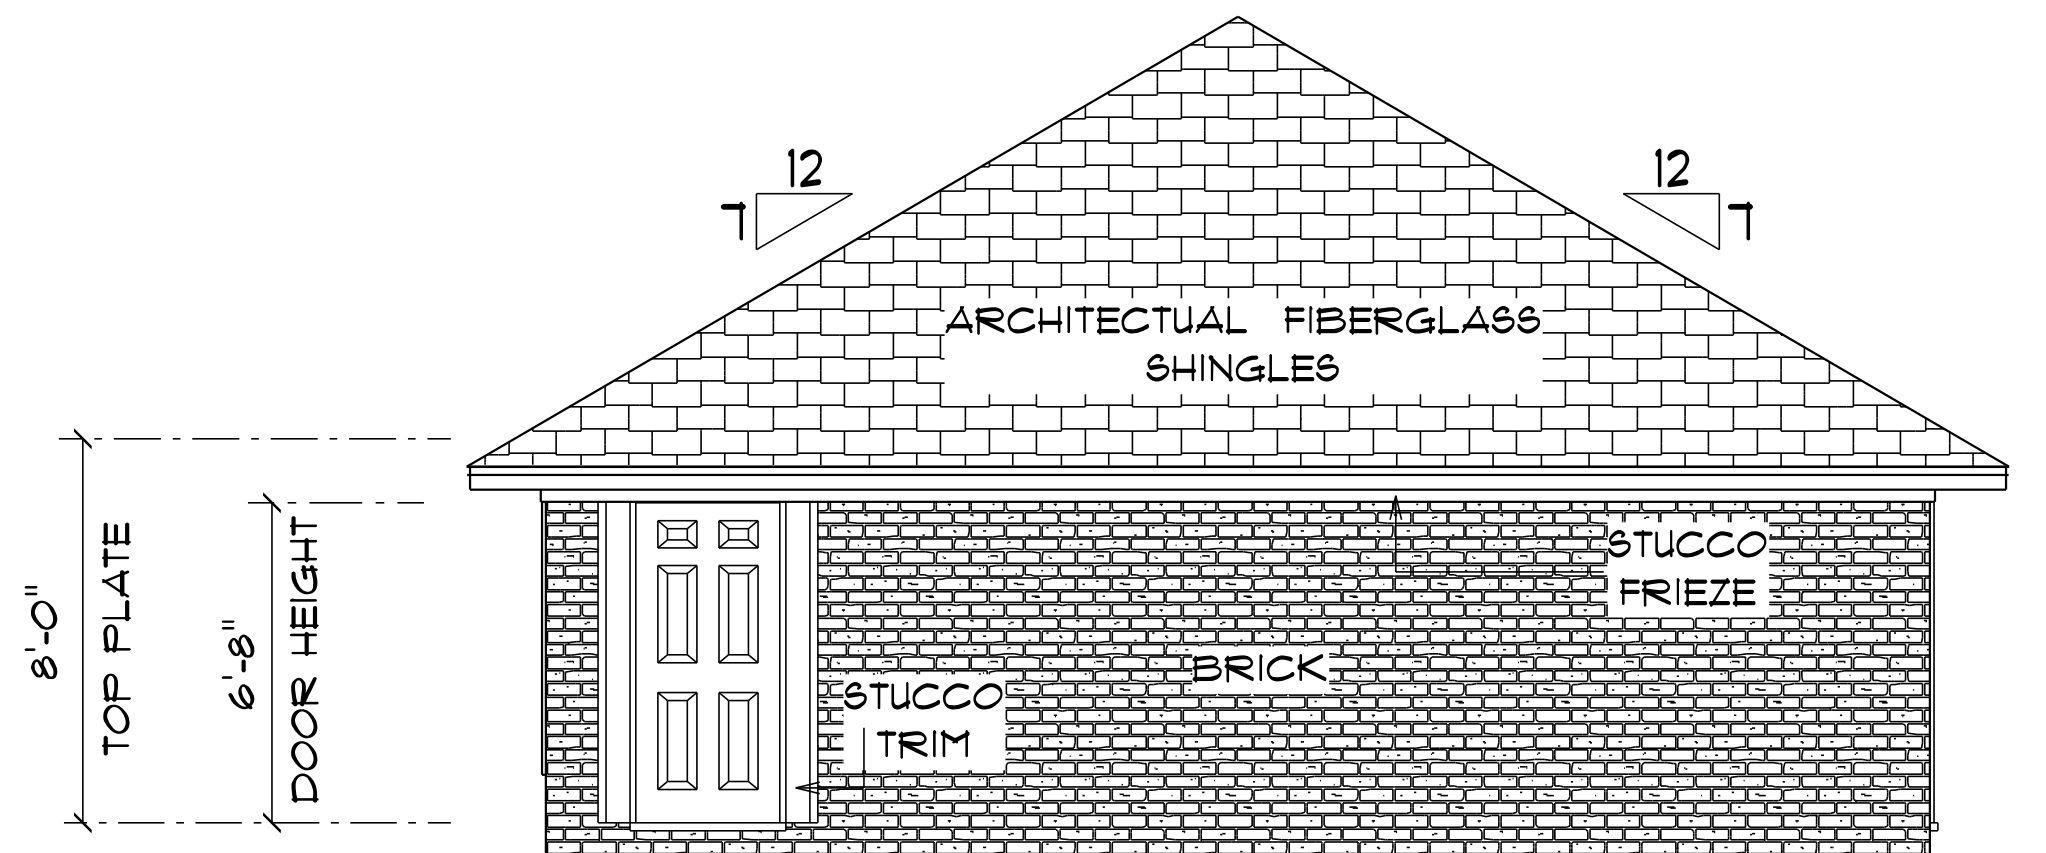

* PARTIAL *
* REAR ELEVATION *



SCALE : 1/4" = 1'-0"

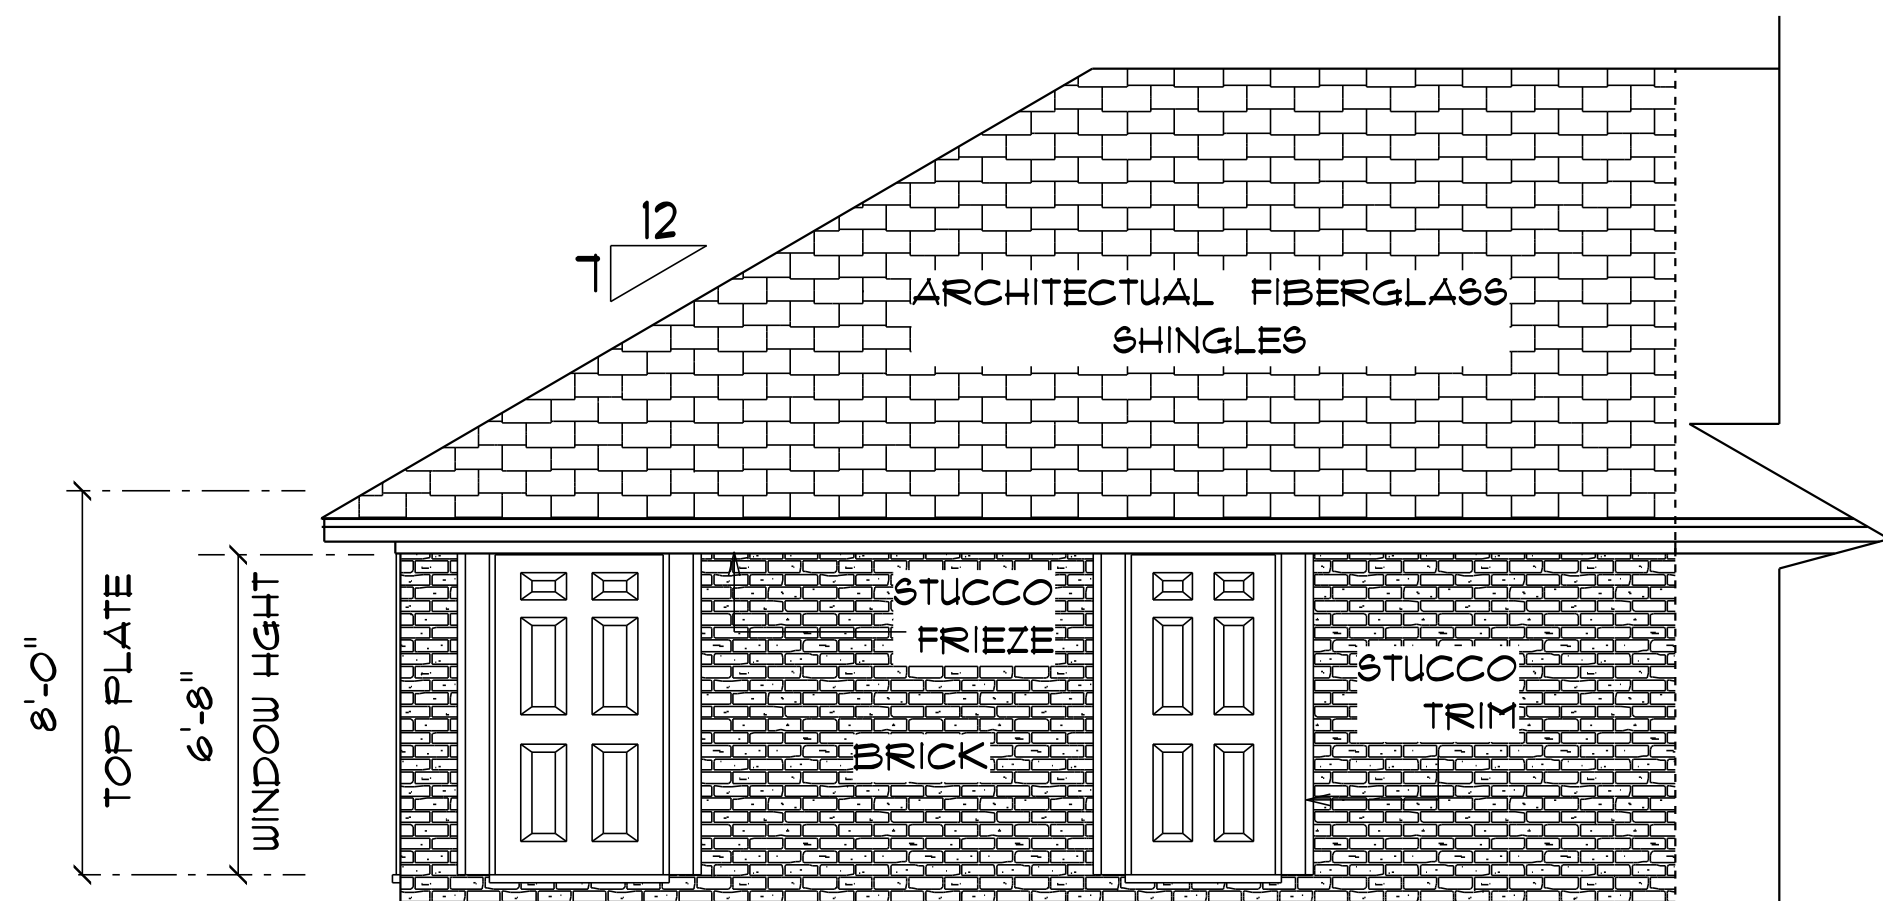

* PARTIAL *
* LEFT SIDE ELEVATION *

SCALE : 1/4" = 1'-0"

ELECTRICAL LEGEND		
ELECTRICAL	COUNT	SYMBOL
ceiling fan globe O1	2	
pot light	9	
exterior light O2	1	
spotlight double	2	
light	3	
outlet	9	
outlet 220v	2	
outlet gfi	3	
outlet wp	1	
switch	4	
switch 3 way	2	

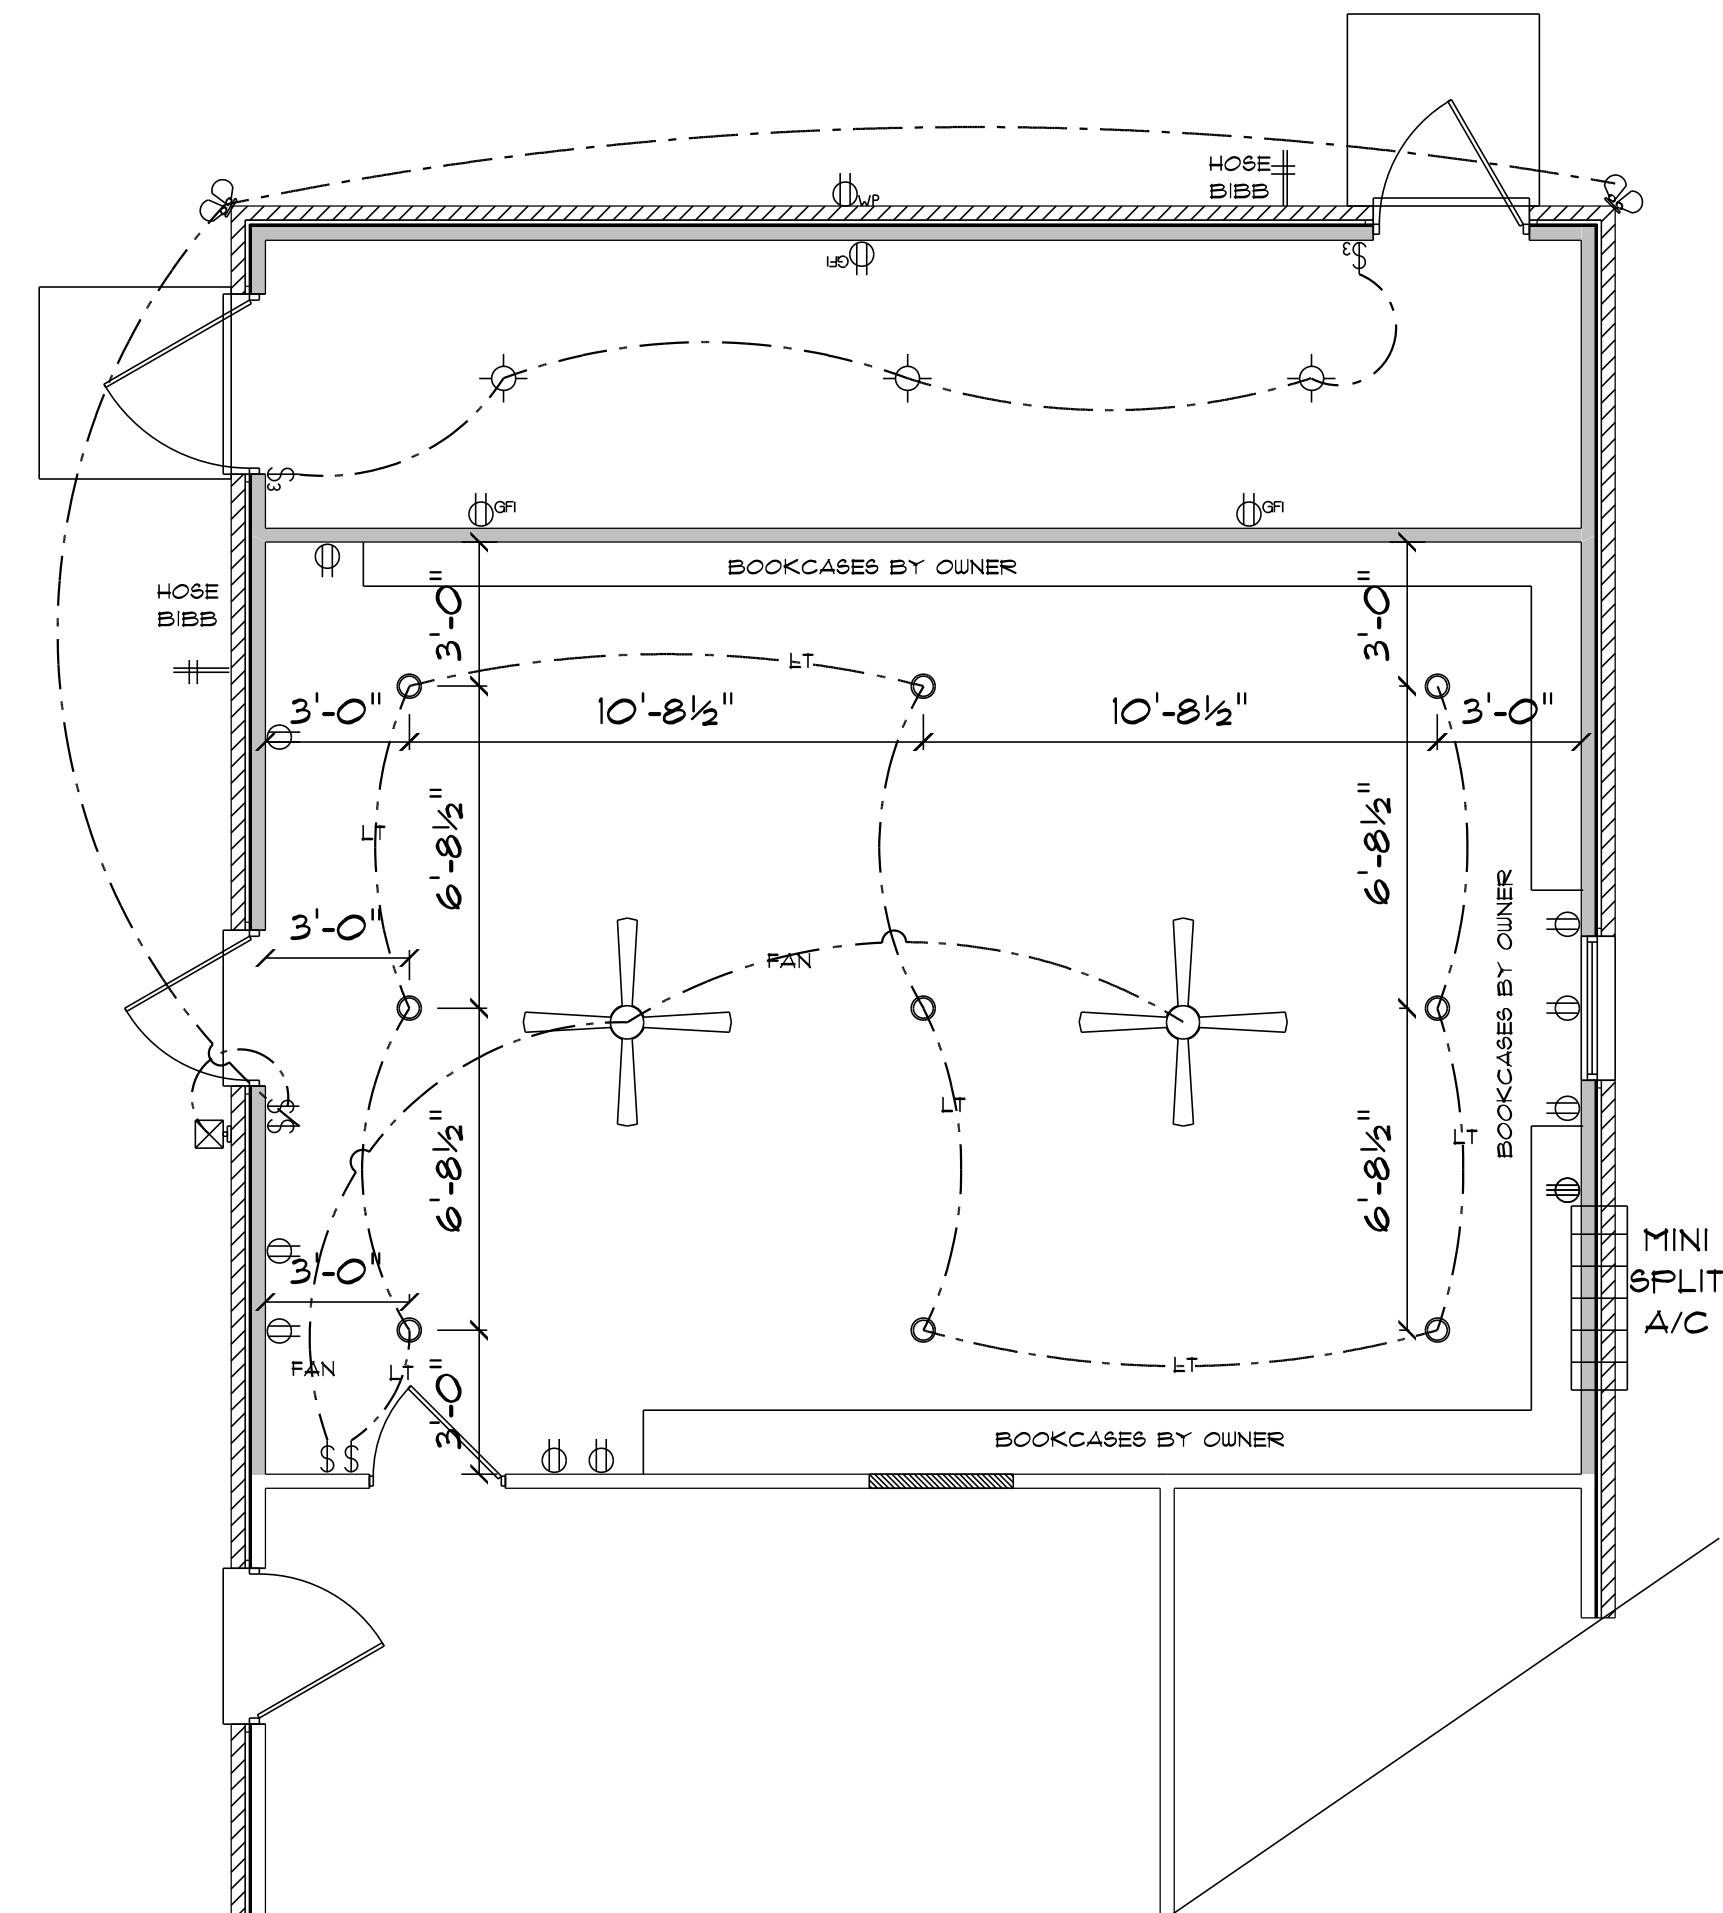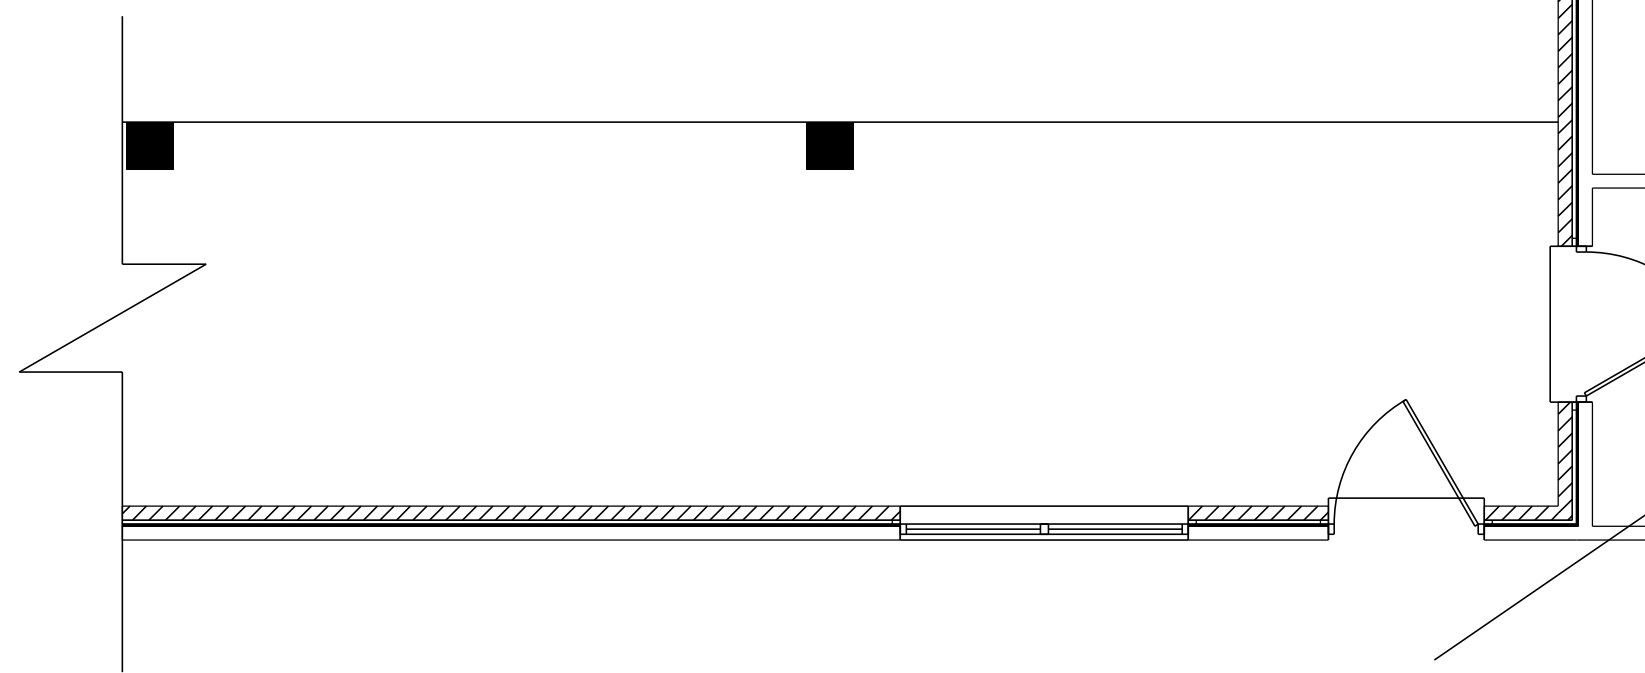

ELECTRICAL PLAN NOTES

- E-1 WIRE ALL APPLIANCES, HVAC UNITS AND OTHER EQUIPMENT PER MANUFACTURERS SPECIFICATIONS.
- E-2 ALL INSTALLATIONS SHALL BE PER NATIONAL ELECTRIC CODE.
- E-3 ELECTRICAL CONTRACTOR SHALL BE RESPONSIBLE FOR THE DESIGN AND SIZING OF ELECTRICAL SERVICE AND CIRCUITS.

* PROPOSED PARTIAL *
* ELECTRICAL PLAN *

SCALE = 1/4" = 1'-0"

ADDITION
for
BOB & LANE
DEKLE

283 SW LOBLOLLY PL
LAKE CITY, FLORIDA

Teena M. Ruffo
2925 SW SR 47
Lake City Florida, 32025
Cell: (386) 867-1191
Email: teenaruffo@gmail.com

PRINTED DATE:
Thursday, June 25, 2020

DRAWN BY: Teena M. Ruffo CHECKED BY:

BUILDING CONTRACTOR

FINALS DATE:

JOB NUMBER:

DRAWING NUMBER

A-2

OF 2 SHEETS