



EXISTING BUILDING RENOVATIONS FOR:
KINGDOM CULTURE ACADEMY
COLUMBIA COUNTY, FLORIDA

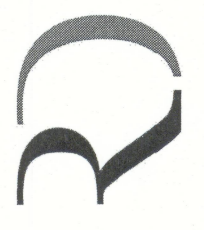

RIDGEPOINT DESIGN
RIDGEPOINTDESIGNPAUL.COM | 386-288-1888

JOINT VENTURED WITH

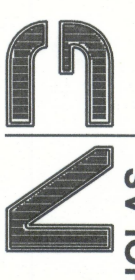

**NICHOLAS
GEISLER
PAUL
ARCHITECT**
NCA/ALCB, Certified


1759 NW Brown Rd.
Largo City, FL 33025

SHEET NUMBER
A.3
OF 4 SHEETS



05 Apr 2024

AR0007005

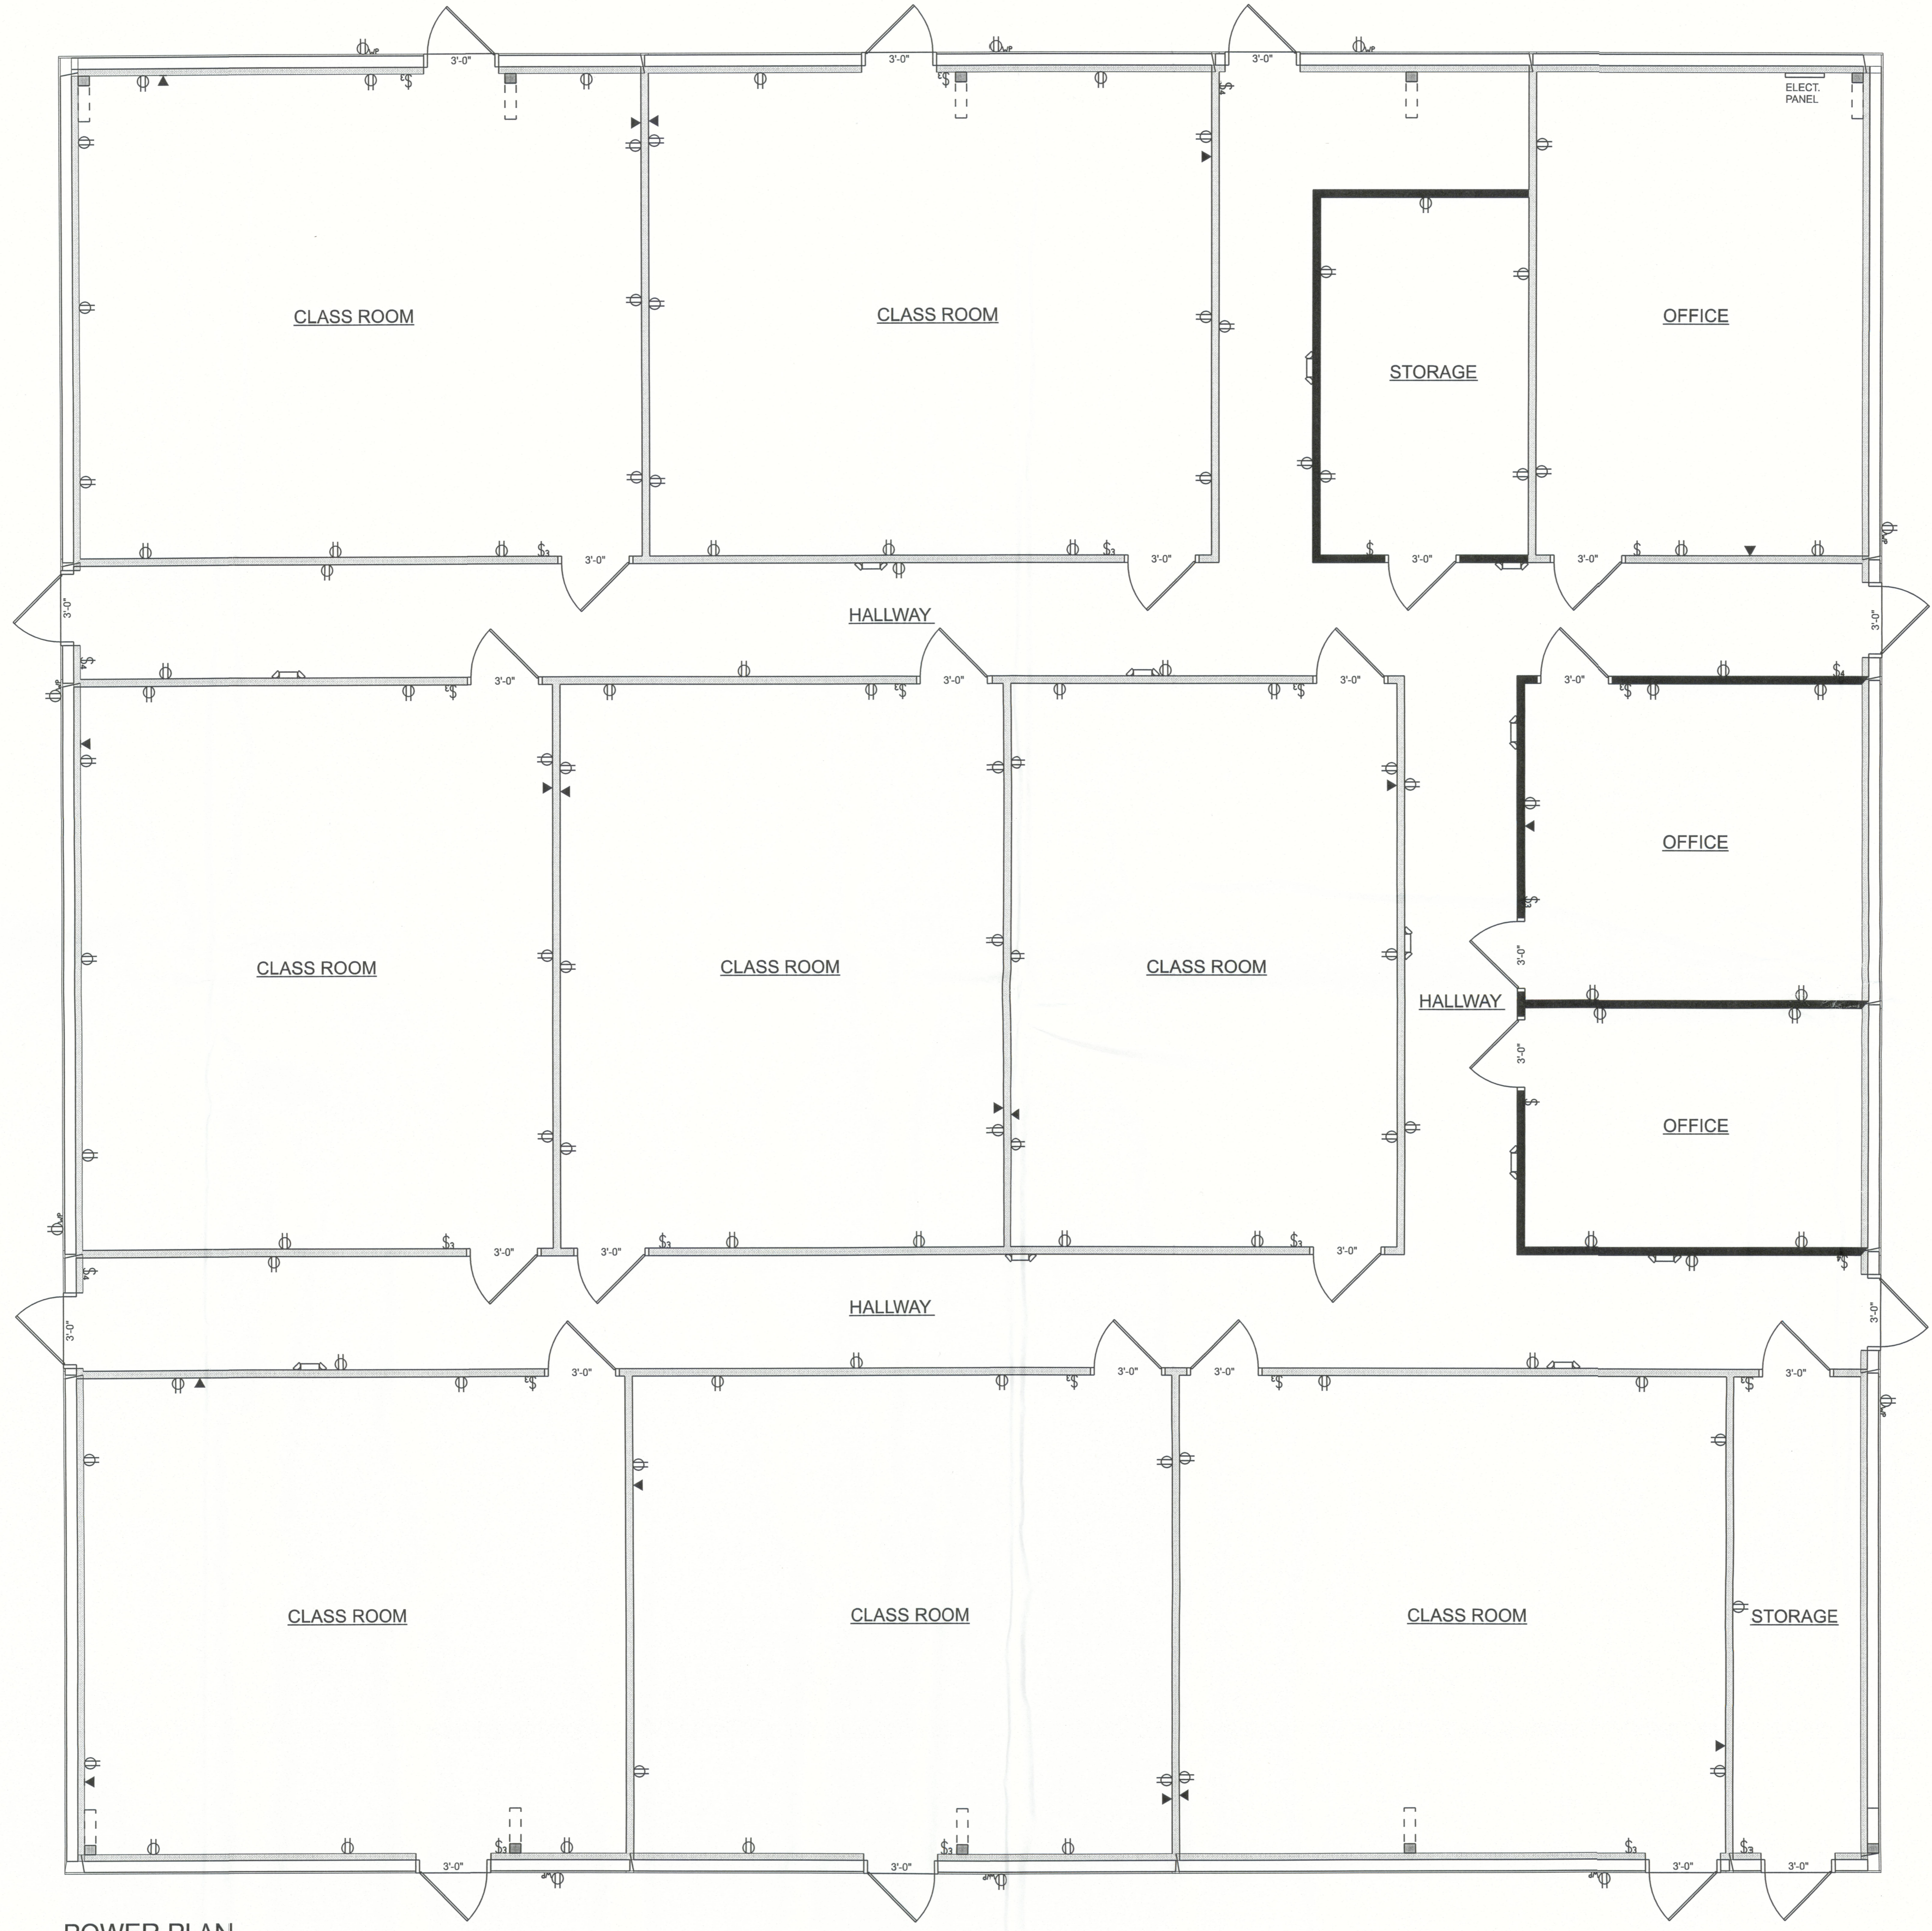

POWER PLAN
SCALE: 1/4" = 1'-0"

ELECTRICAL LEGEND	
ELECTRICAL	SYMBOL
Emergency Light	
LAN CONNECTION	
OUTLET	
OUTLET WP	
SWITCH	
SWITCH 3 WAY	
SWITCH 4 WAY	