

the
rickman
partnership
inc

architecture and interior design

4328 NORTHWEST 29 TERRACE
GAINESVILLE, FL 32605
rickmanpartnership@att.net
(352) 339-1834

FLORIDA LICENSE-AAC00126
FLORIDA LICENSE-IB0000891



RESIDENCE
FOR

KIM McCONNELL
AND
DANIEL McCONNELL

18818 SOUTH US HIGHWAY 441
HIGH SPRINGS, FL 32643

DATE	DESCRIPTION

CONSTRUCTION DOCUMENTS

PROJECT NO. 2405

DATE: 11 OCTOBER 2024

SHEET:

A-01

OF: ELEVEN

PROJECT INFORMATION

CODE REFERENCE:

FLORIDA BUILDING CODE RESIDENTIAL 8TH EDITION (2023)

OCCUPANCY CLASSIFICATION:

GROUP R-3 (SINGLE FAMILY RESIDENCE)

CONSTRUCTION TYPE:

TYPE III

STRUCTURAL AND WIND LOAD DESIGN PARAMETERS:

RISK CATEGORY:

II

ULTIMATE DESIGN WIND SPEED:

140 MPH

WIND DIRECTIONALITY FACTOR, Kd:

0.85

EXPOSURE CATEGORY:

B

TOPOGRAPHIC FACTOR, Kzt:

1.0

GUST EFFECT FACTOR, G:

0.85

ENCLOSURE CLASS:

ENCLOSED (BY DEFINITION)

INT. PRESS. COEFF. GCpi:

+/- 0

MEAN ROOF HEIGHT:

20'

EXPOSURE COEFFICIENT, Kh:

0.10

NUMBER OF STORIES:

ONE

EXTERIOR WALLS:

CMU

SQUARE FOOTAGE

CONDITIONED SPACE2,058 SF

GARAGE416 SF

ENTRANCE PORCH160 SF

SCREENED PORCH416 SF

PROJECT DESCRIPTION AND SCOPE OF WORK:

NEW TWO BEDROOM, THREE BATH RESIDENCE

NEW WELL HOUSE

 
REMOVAL OF EXISTING MOBILE HOME AFTER COMPLETION OF CONSTRUCTION

DRAWING INDEX

A-01	GENERAL INFORMATION SHEET	A-08	SCHEDULES: DOOR, WINDOW, HARDWARE, PLUMBING FIXTURE, TILE PLUMBING RISER WINDOW TRIM DETAIL
A-02	SITE PLAN	A-09	EXTERIOR ELEVATIONS WELL HOUSE: SECTION
A-03	FOUNDATION PLAN ROOF PLAN FOOTING DETAILS "BUCK" STOVE HEARTH DETAIL		EXTERIOR ELEVATIONS PLAN FOUNDATION PLAN
A-04	FLOOR PLAN	A-10	INTERIOR ELEVATIONS KITCHEN APPLIANCE SCHEDULE
A-05	DIMENSION PLAN	A-11	SECTIONS
A-06	POWER PLAN ELECTRICAL CALCULATIONS ELECTRICAL SYMBOLS LEGEND ELECTRICAL RISER EXHAUST FAN SCHEDULE		
A-07	LIGHTING PLAN LIGHTING FIXTURE SCHEDULE		




Review for Code Compliance
Universal Engineering Science




PX270701/17/2025

Examiner-License No.

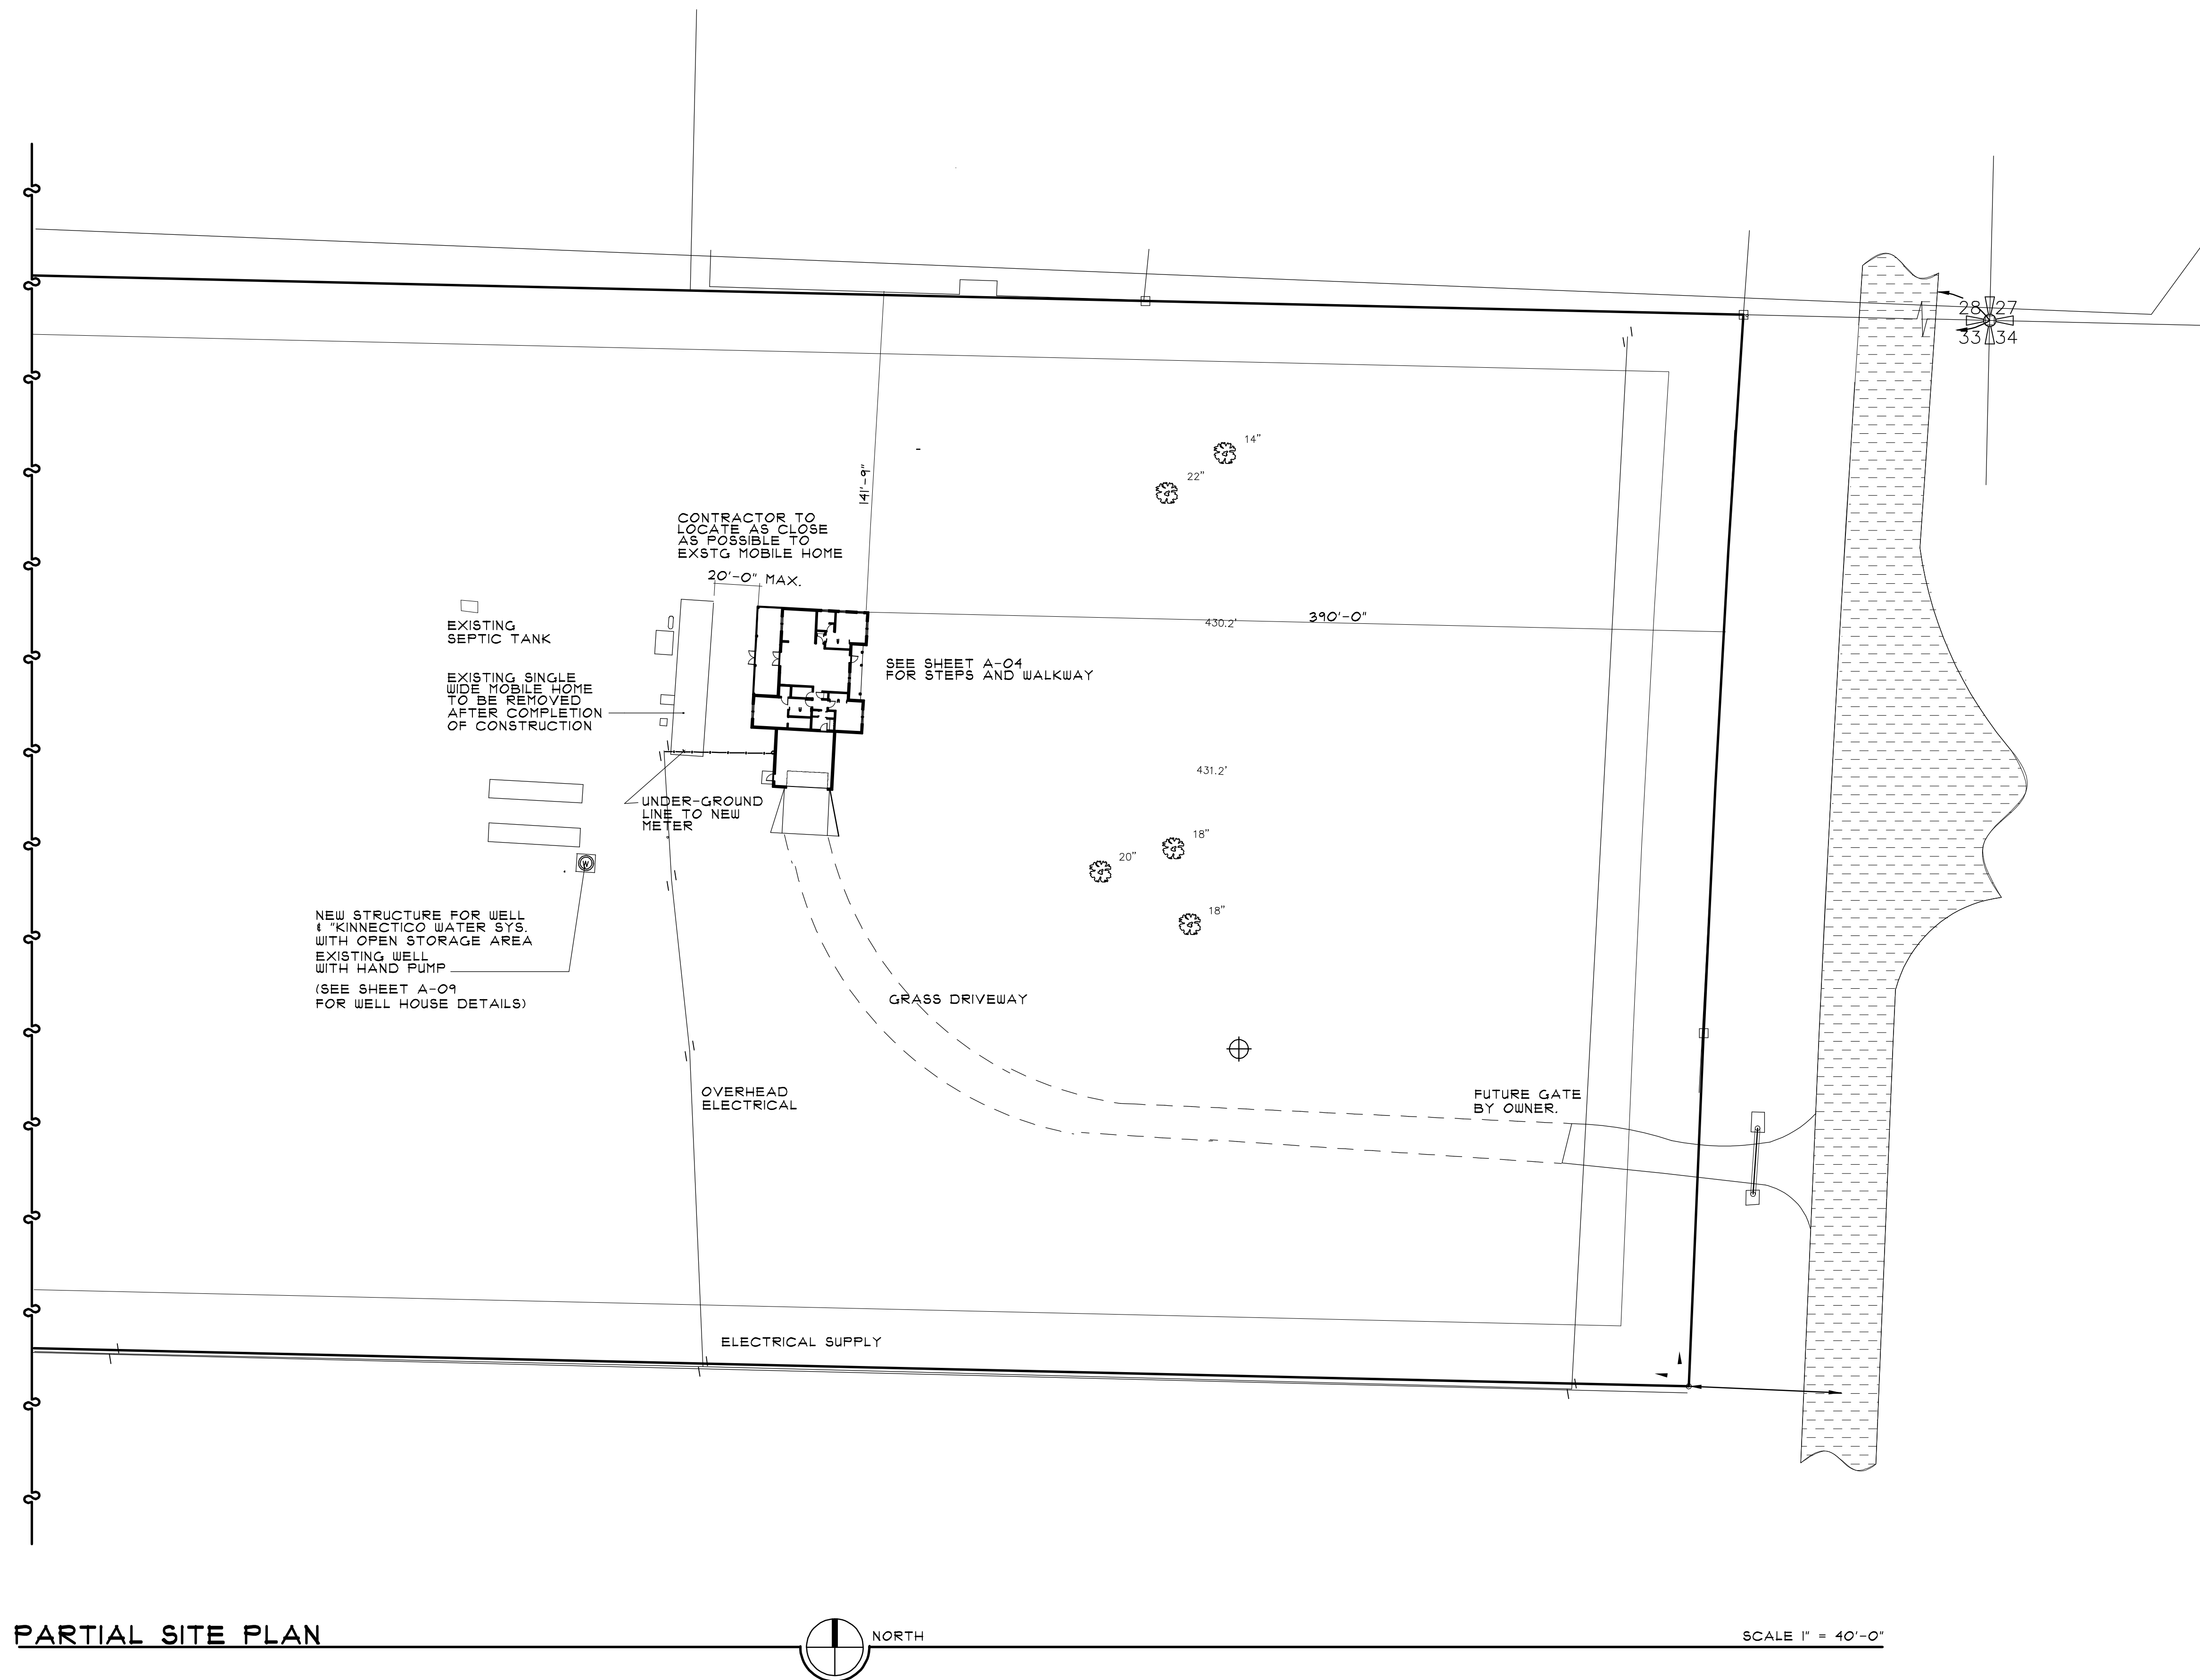

PARTIAL SITE PLAN

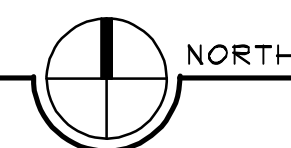

SCALE 1" = 40'-0"



Review for Code Compliance
Universal Engineering Science

Lawrence Perrell
Examiner-License No.

PX2707

01/17/2025

the
rickman
partnership
inc
architecture and interior design

4328 NORTHWEST 29 TERRACE
GAINESVILLE, FL 32605
rickmanpartnership@att.net
(352) 339-1834

FLORIDA LICENSE-AAC00126
FLORIDA LICENSE-IB0000891



RESIDENCE
FOR

KIM McCONNELL
AND
DANIEL McCONNELL

18818 SOUTH US HIGHWAY 441
HIGH SPRINGS, FL 32643

DATE	DESCRIPTION

CONSTRUCTION DOCUMENTS






PROJECT NO. 2405

DATE: 11 OCTOBER 2024

SHEET:

A-02

OF: ELEVEN

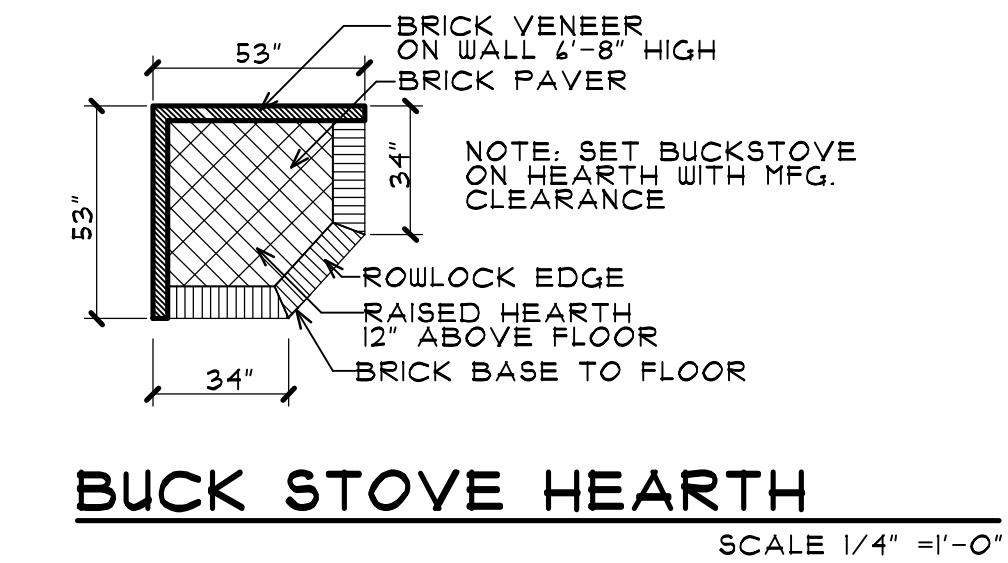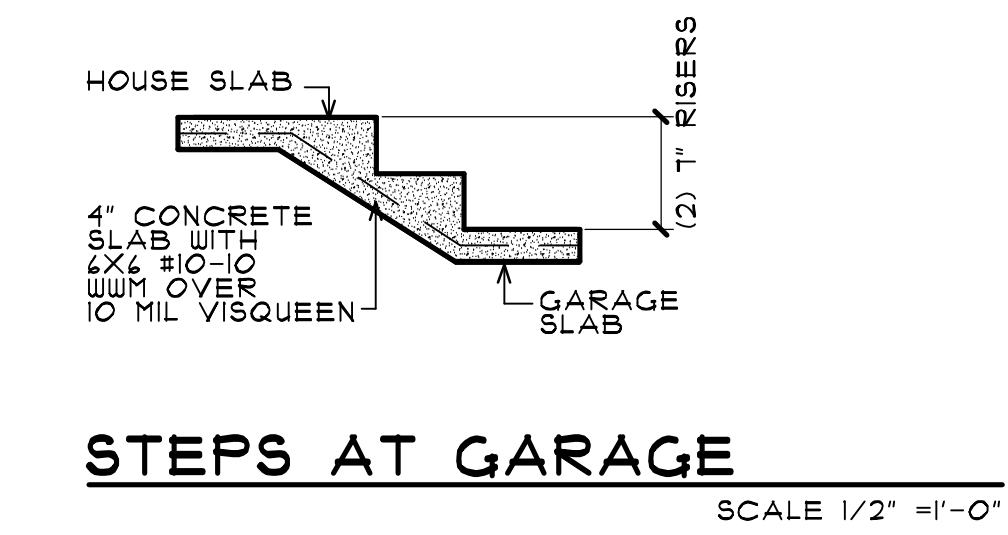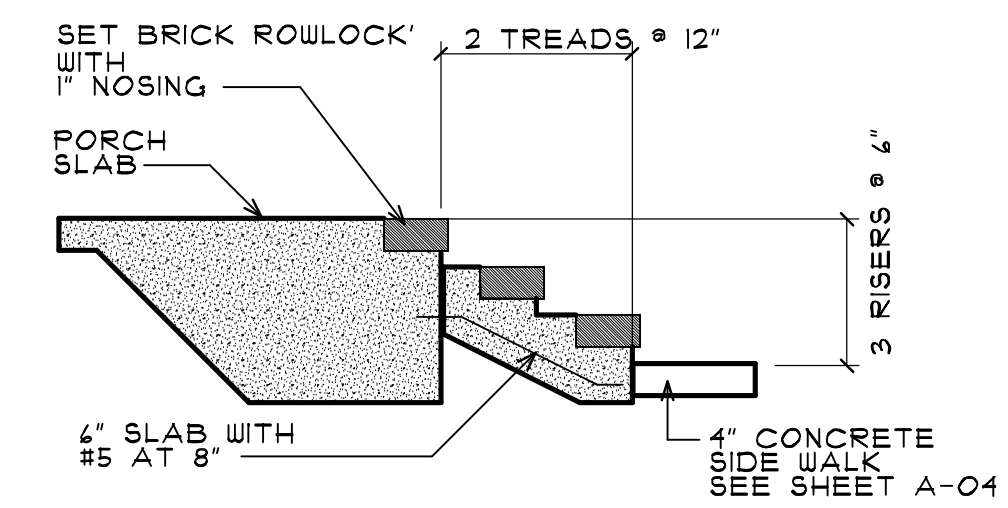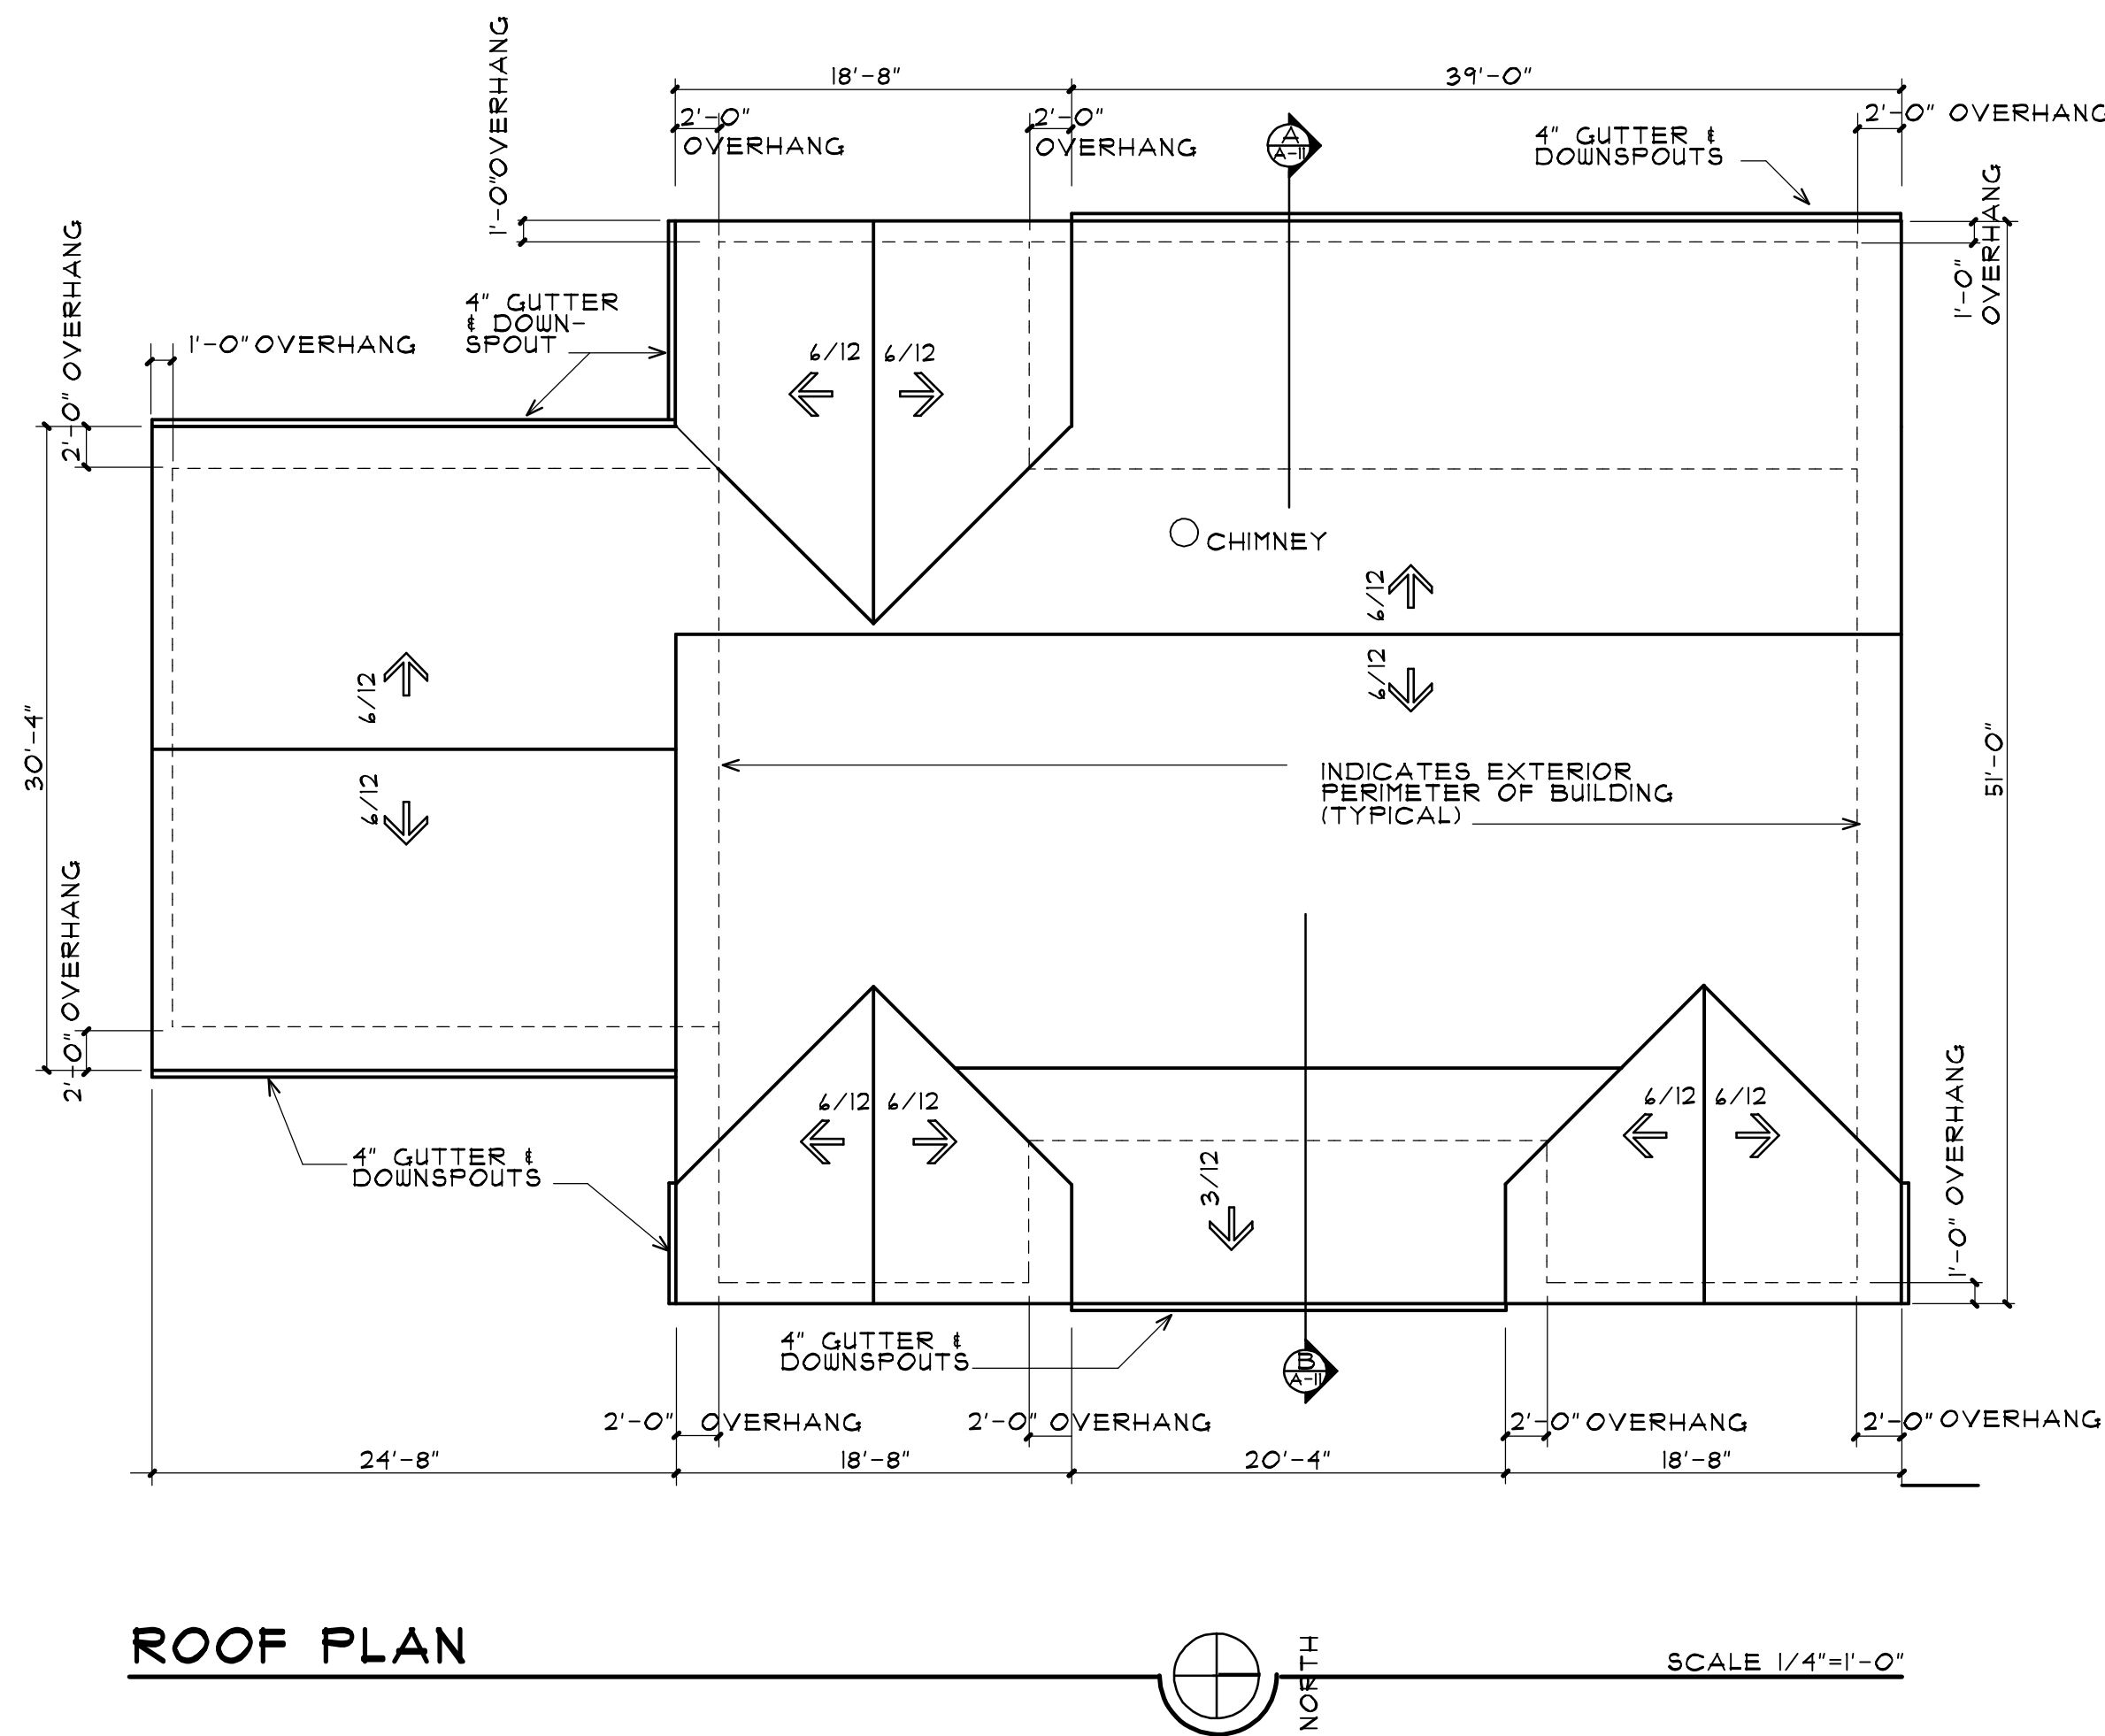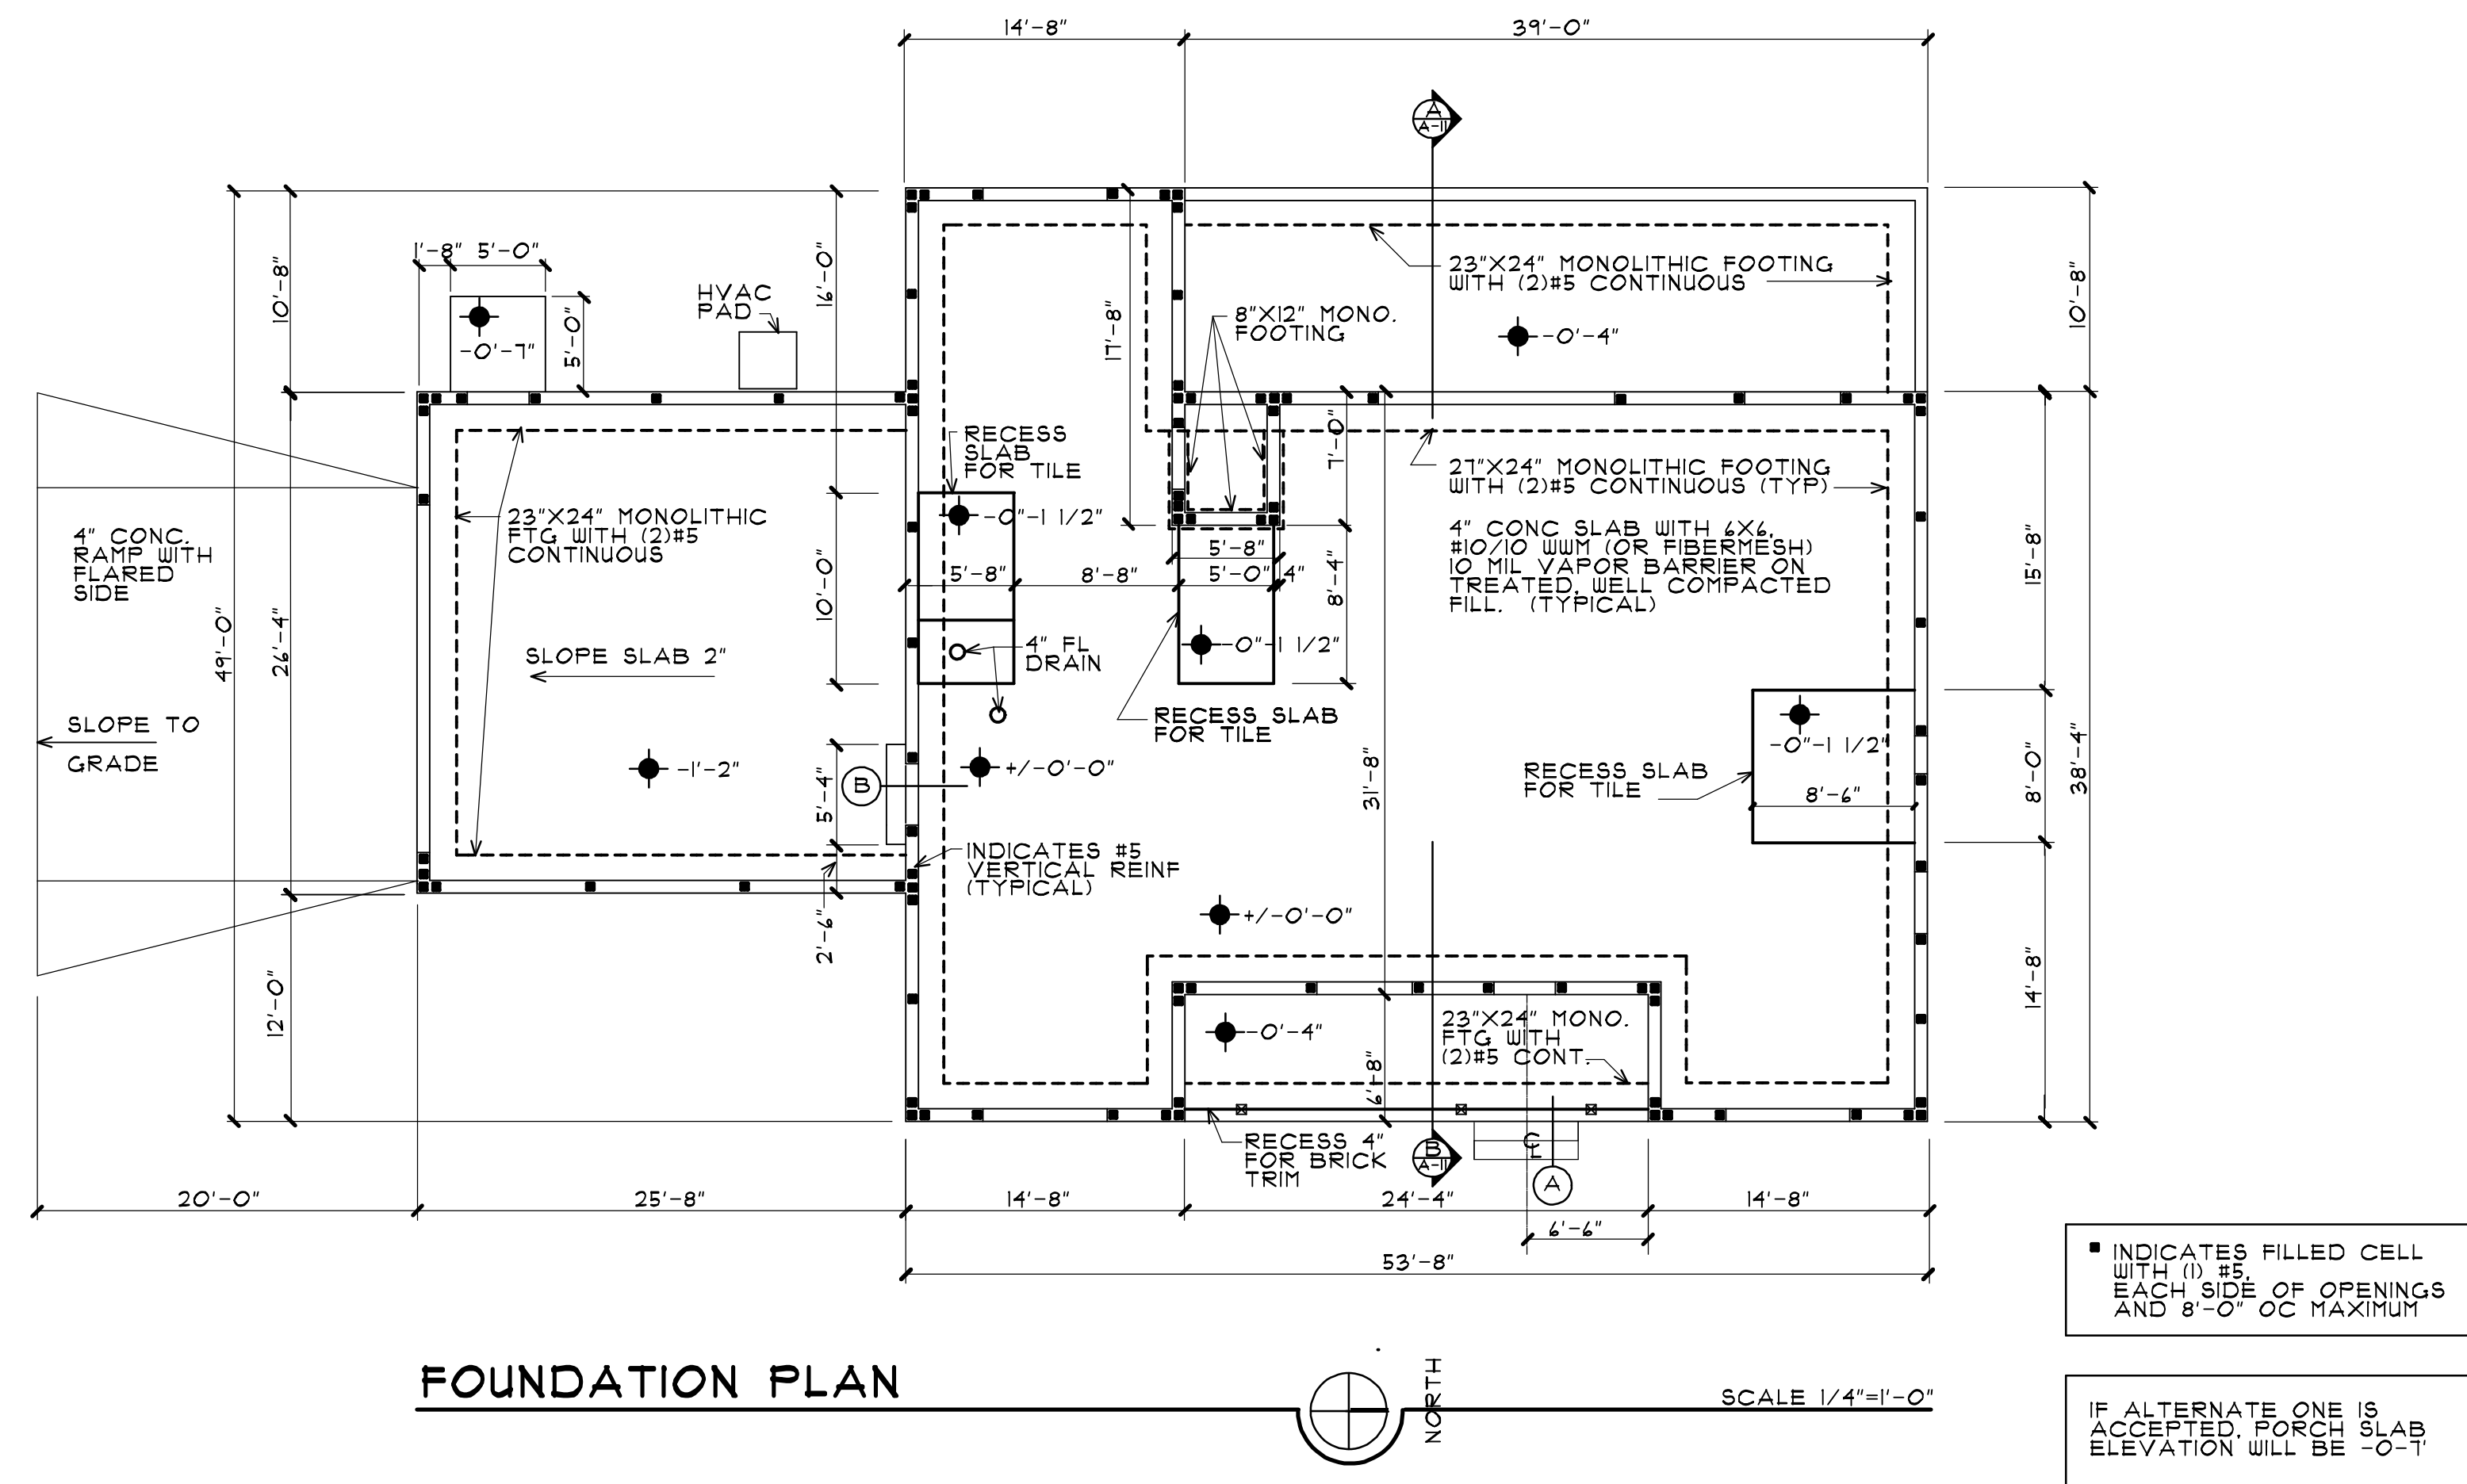

Review for Code Compliance
Universal Engineering Science

Lawrence Pennell PX2707 01/17/2025
Examiner-License No.

the
rickman
partnership
inc
architecture and interior design

4328 NORTHWEST 29 TERRACE
GAINESVILLE, FL 32605
rickmanpartnership@att.net
(352) 339-1834

FLORIDA LICENSE-AAC00124
FLORIDA LICENSE-IB0000891



RESIDENCE
FOR
KIM McCONNELL
AND
DANIEL McCONNELL

18818 SOUTH US HIGHWAY 441
HIGH SPRINGS, FL 32643

DATE	DESCRIPTION

CONSTRUCTION DOCUMENTS

PROJECT NO. 2405

DATE: 11 OCTOBER 2024

SHEET:
A-03
ELEVEN

the
rickman
partnership
inc

architecture and interior design

4328 NORTHWEST 29 TERRACE
GAINESVILLE, FL 32605
rickmanpartnership@att.net
(352) 339-1834

FLORIDA LICENSE-AAC000126
FLORIDA LICENSE-IB0000891



RESIDENCE
FOR
**KIM McCONNELL
AND
DANIEL McCONNELL**

18818 SOUTH US HIGHWAY 441
HIGH SPRINGS, FL 32643

DATE	DESCRIPTION

CONSTRUCTION DOCUMENTS


PROJECT NO. 2405

DATE: 11 OCTOBER 2024

SHEET:

A-04

OF: ELEVEN

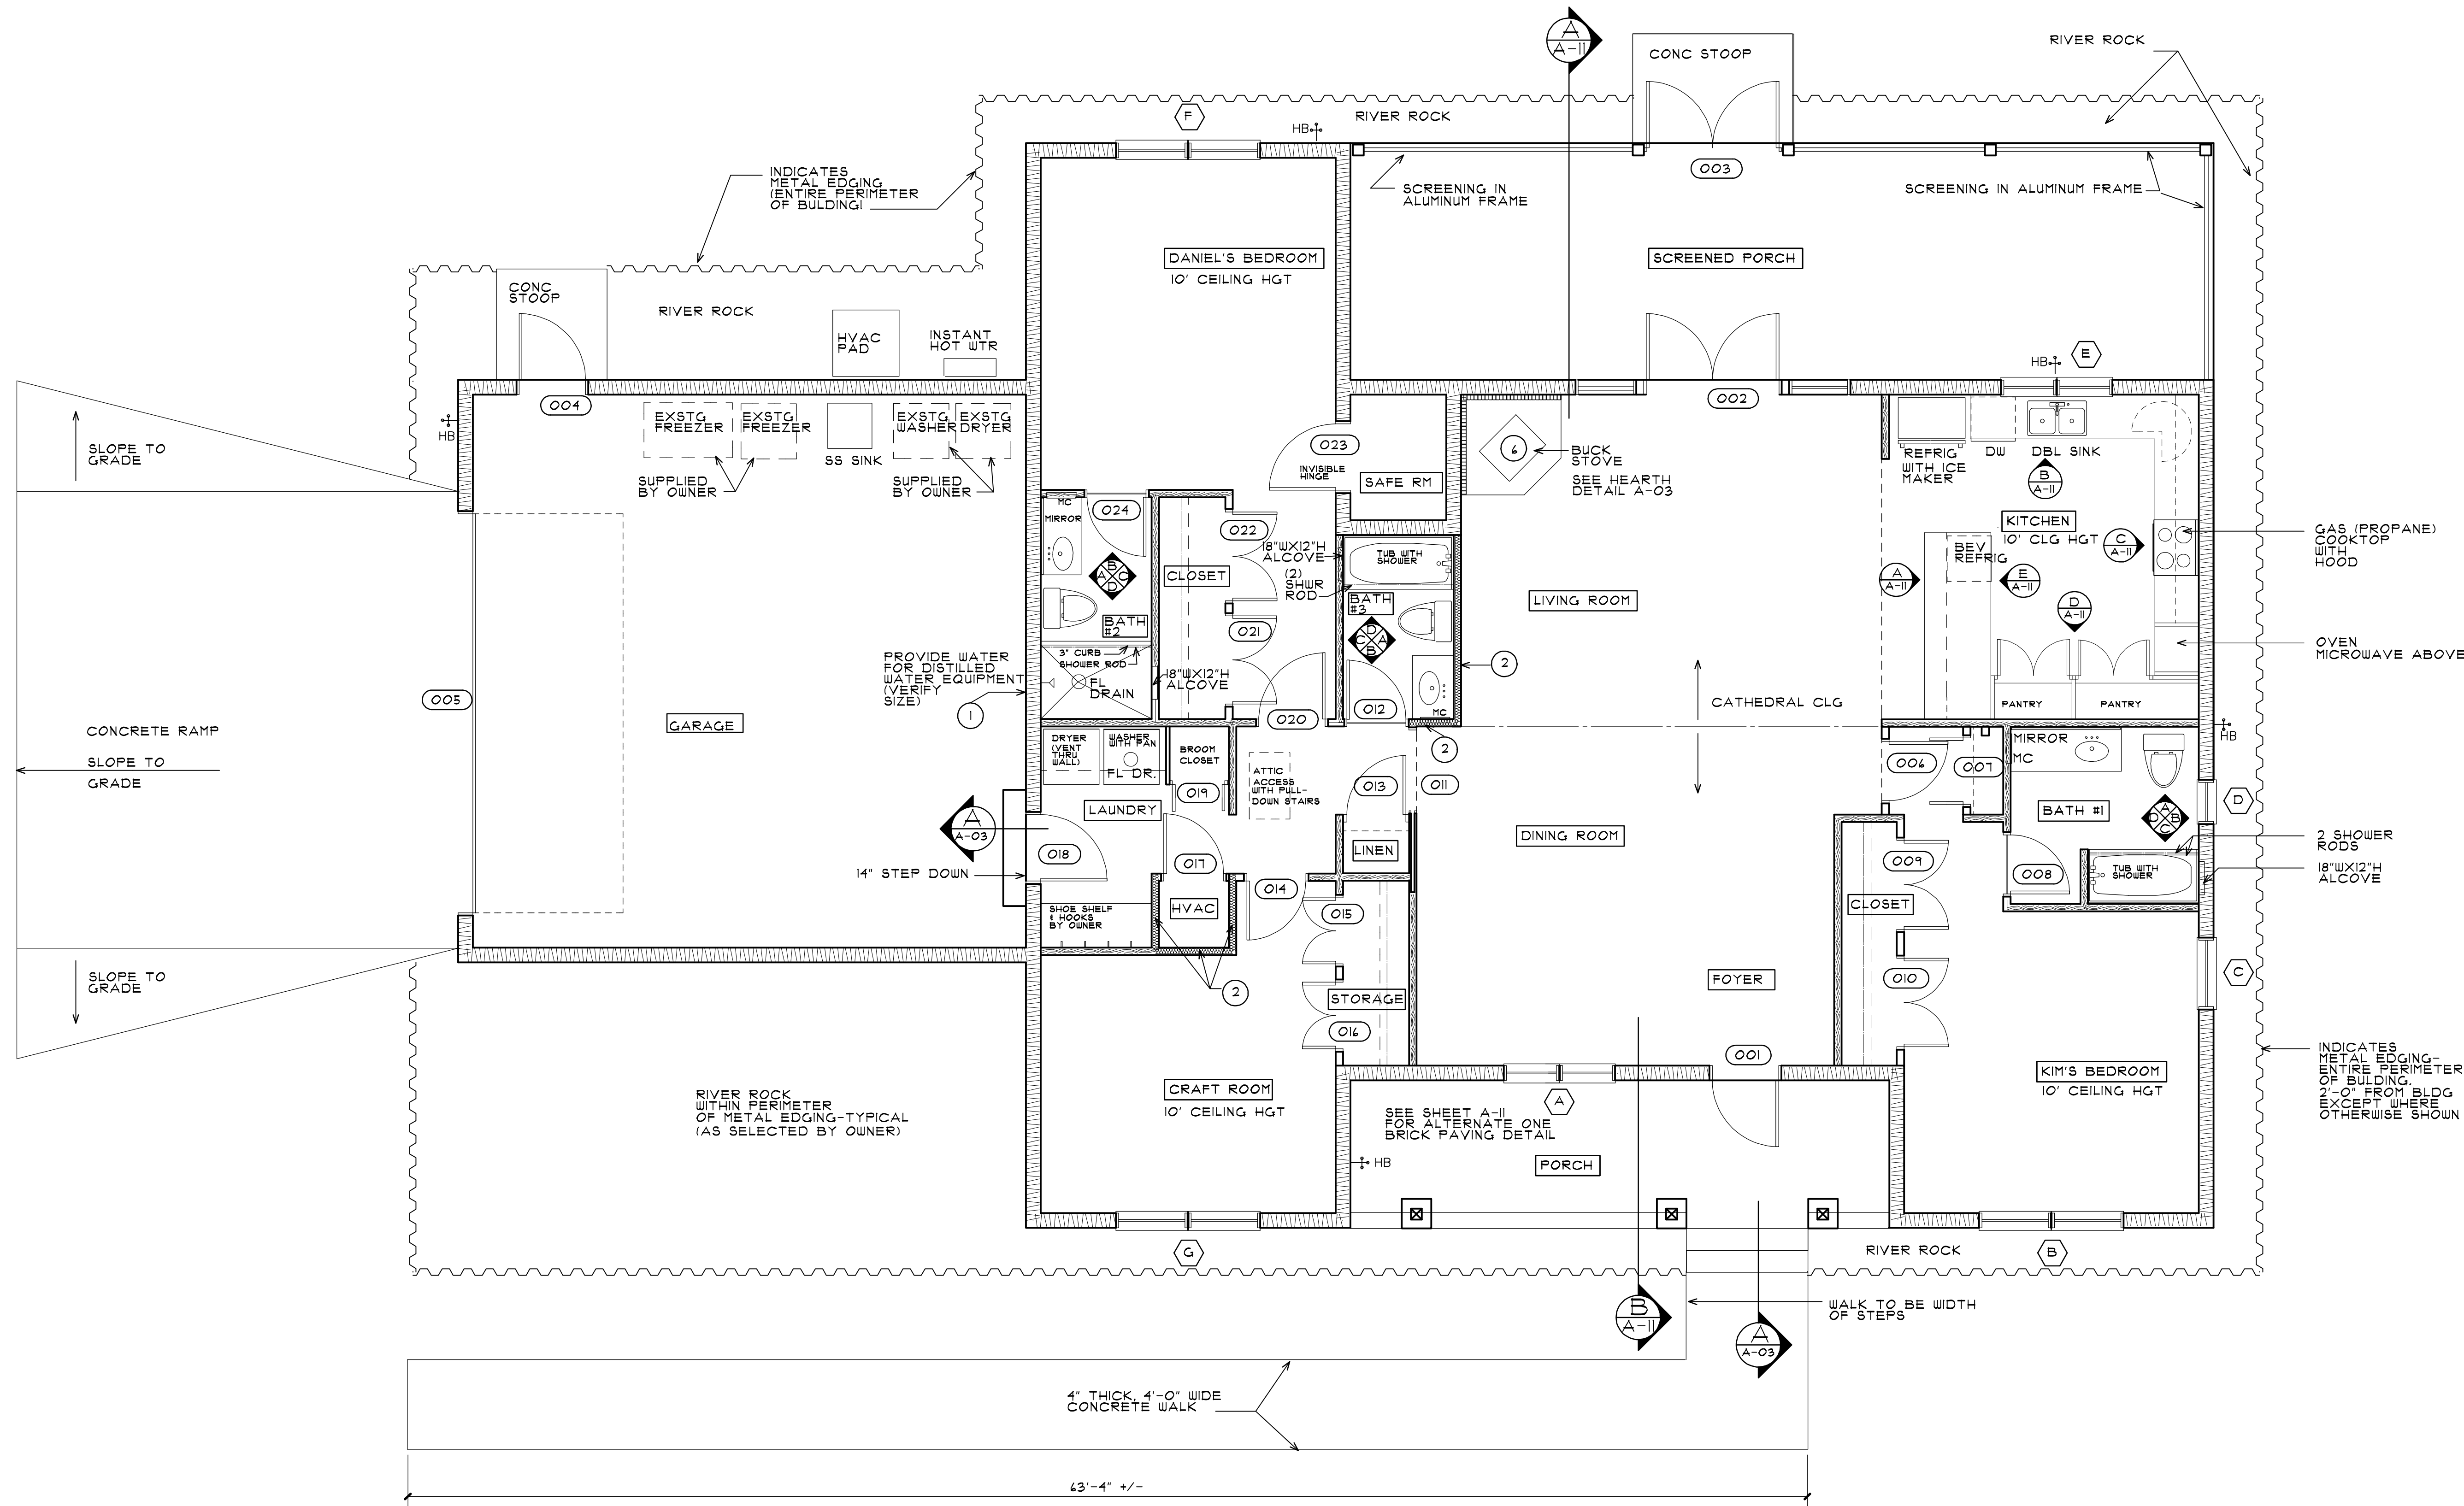

NOTES LEGEND

- CONTRACTOR TO INSTALL AND CONNECT TO PLUMBING AS REQUIRED-THE OWNER'S "WATER WEEK" DISTILLED WATER EQUIPMENT (IN GARAGE)
- SOUND ATTENUATION INSULATION-SEE PLAN FOR LOCATION
- ALL CABINETS AND SHELVING WILL BE PROVIDED AND INSTALLED BY OWNER. CONTRACTOR IS RESPONSIBLE FOR INSTALLATION OF ELECTRICAL AND PLUMBING WITHIN THOSE CABINETS AS REQUIRED AND COORDINATION WITH OWNER'S CABINET COMPANY.
- CONTRACTOR WILL SUPPLY AND INSTALL KITCHEN APPLIANCES.
- 2X12 VERTICAL CONTINUOUS BLOCKING SHALL BE ADDED IN STUD WALLS FOR FUTURE GRAB BARS. SEE INTERIOR ELEVATIONS FOR LOCATIONS.
- BUCK STOVE, MODEL 14-GOLD, FREE STANDING MODEL, WITH OPTIONAL PEDESTAL, BLOWER, FLUE SIZE 6"

FLOOR PLAN

SQUARE FOOTAGE

CONDITIONED SPACE	2,058 SF
GARAGE	474 SF
ENTRANCE PORCH	140 SF
SCREENED PORCH	414 SF



Review for Code Compliance
Universal Engineering Science

Lawrence Parnell
Examiner-License No.

PX2707

01/17/2025

Sleeping rooms shall have emergency escape
rescue openings per FBC R310
Provide handicap bathroom with with 29" clear
opening doors per FBC R320



RESIDENCE
FOR
KIM McCONNELL
AND
DANIEL McCONNELL

18818 SOUTH US HIGHWAY 441
HIGH SPRINGS, FL 32643

DATE	DESCRIPTION

CONSTRUCTION DOCUMENTS


PROJECT NO. 2405

DATE: 11 OCTOBER 2024


SHEET:

A-05

OF: ELEVEN

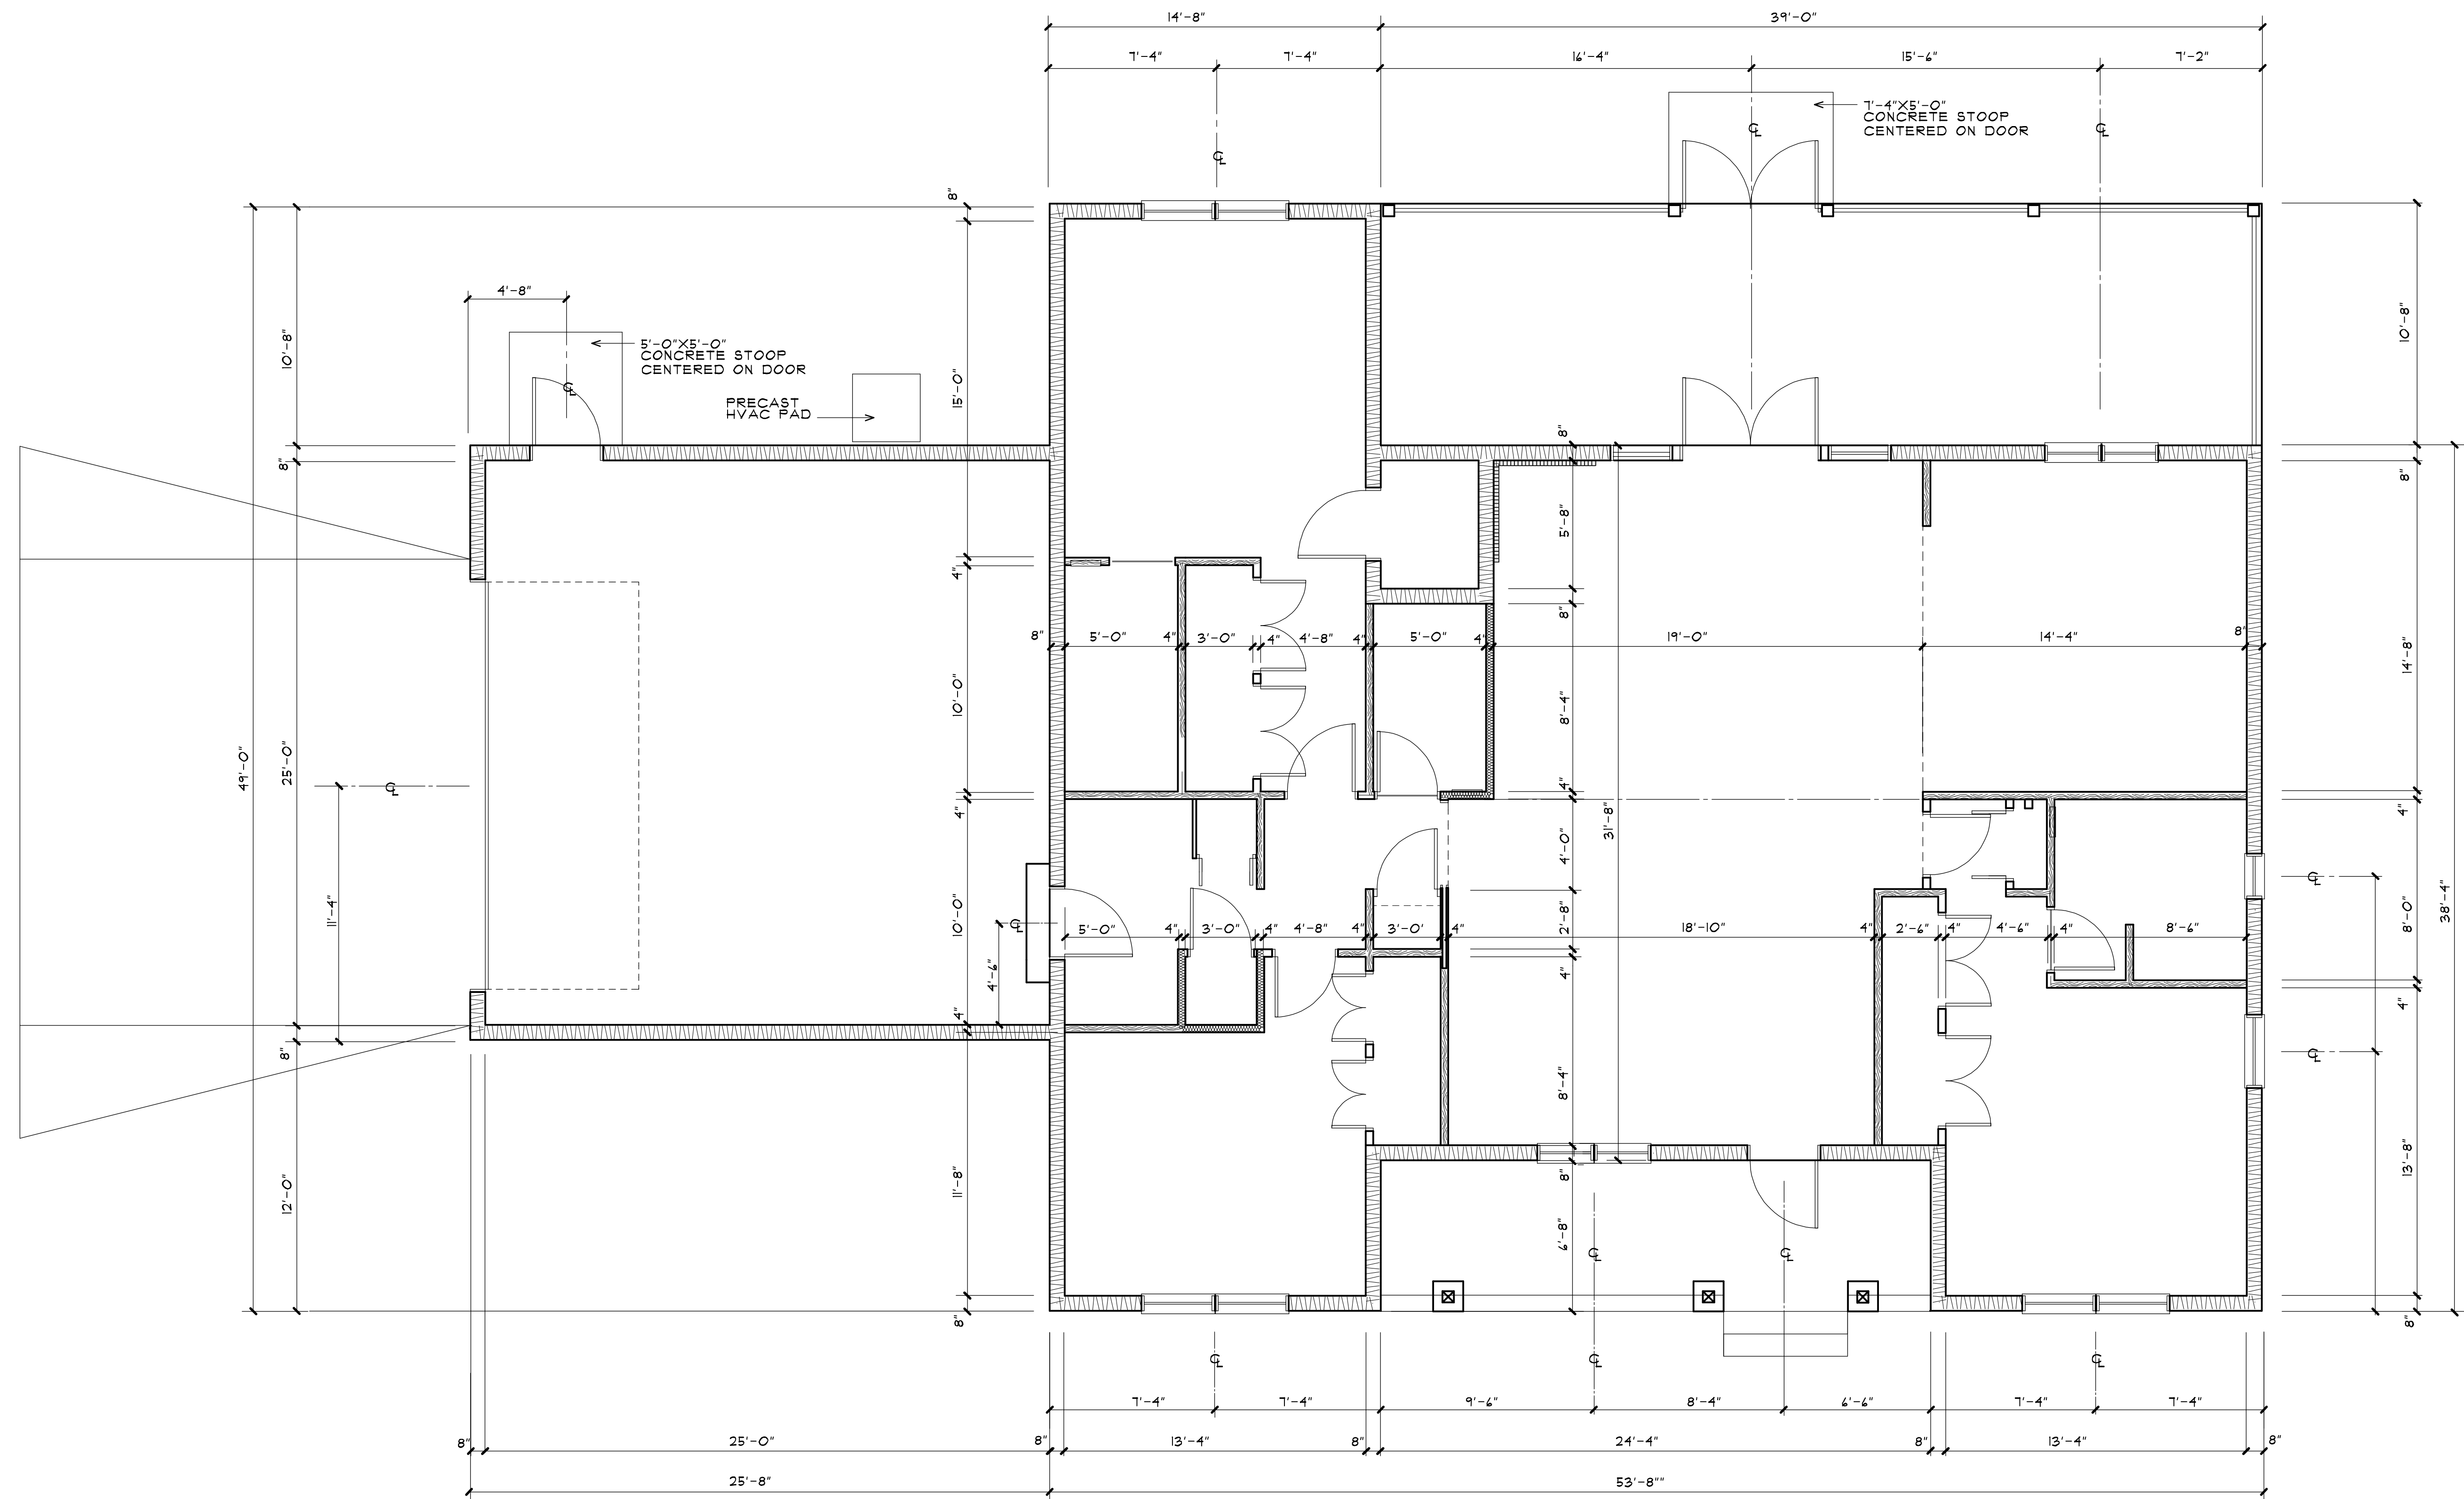

DIMENSION PLAN

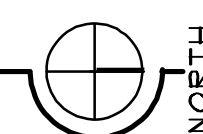

SCALE 1/4"=1'-0"



Review for Code Compliance
Universal Engineering Science

Lawrence Parnell
Examiner-License No.

PX2707

01/17/2025




Review for Code Compliance
Universal Engineering Science

Leander Parnell
Examiner-License No.

PX2707

01/17/2025

Smoke and carbon alarms
required outside all BDRM's per
FBC R314 and R315

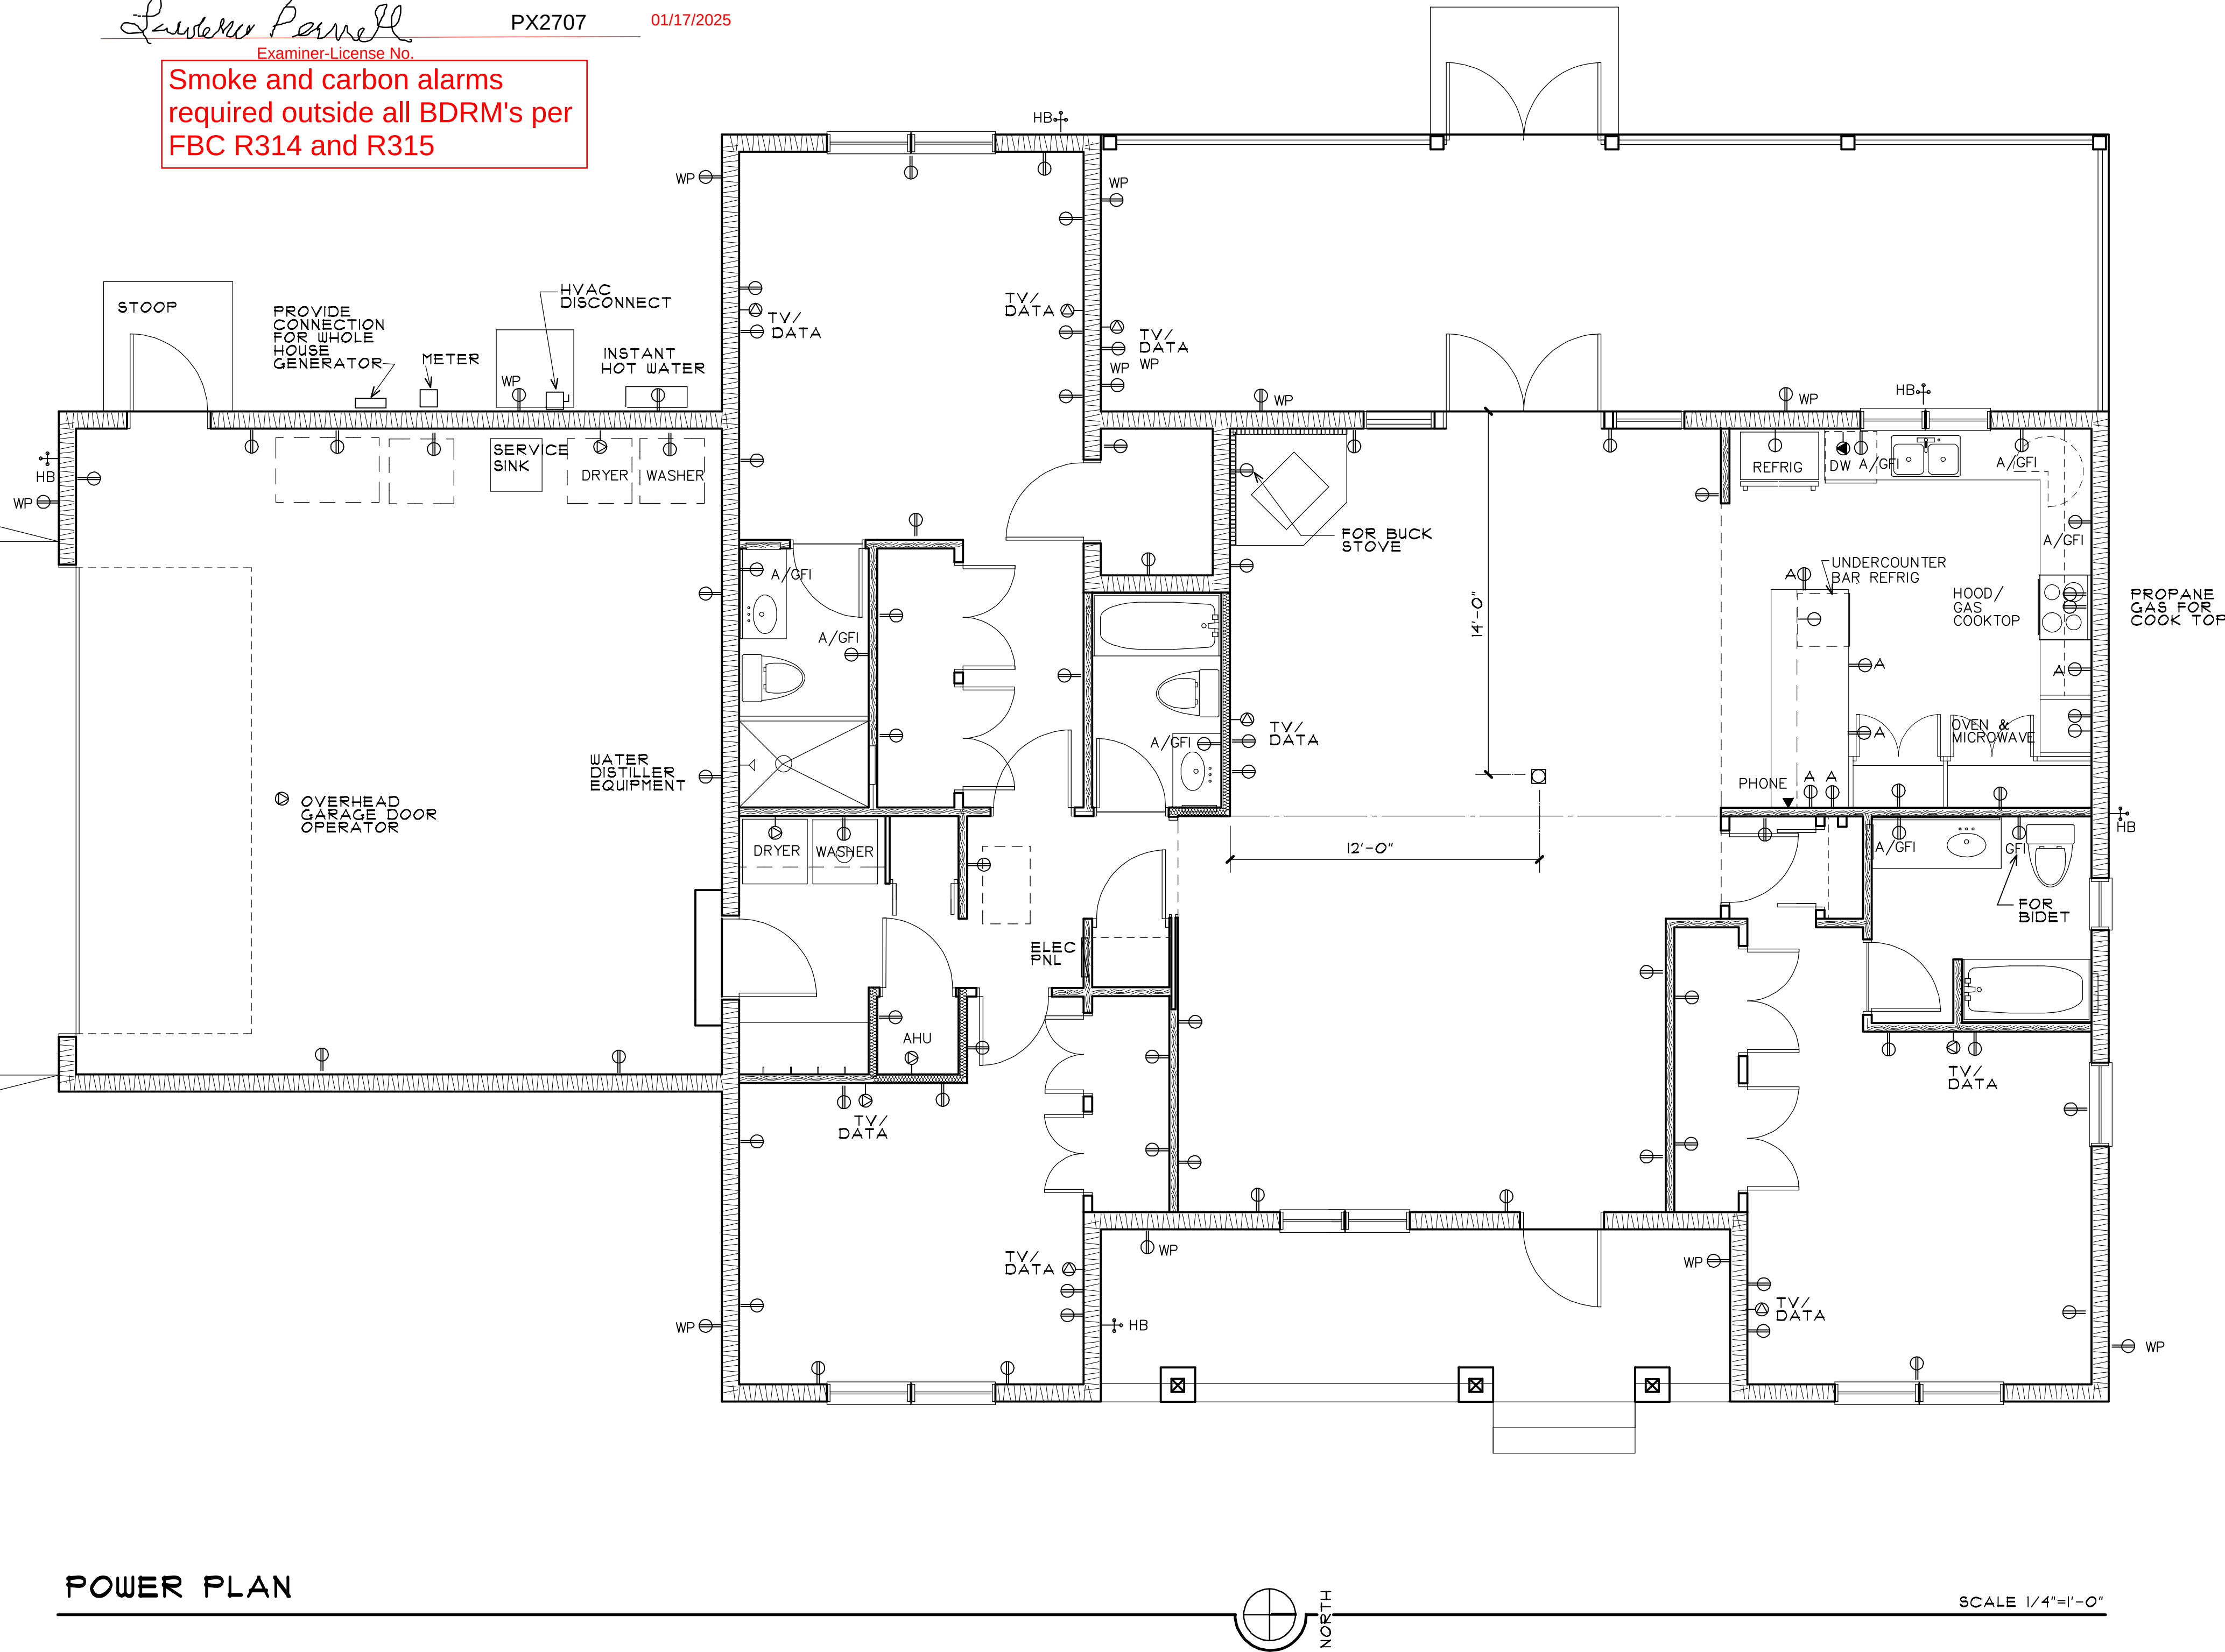

POWER PLAN

EXHAUST FAN SCHEDULE					SUBMITTALS TO BE APPROVED BY OWNER PRIOR TO ORDERING			
MARK	MANUFACTURER TYPE & MODEL	CFM	ELECTRICAL		MOUNTING	MAXIMUM SONES ALLOWED	SERVES	REMARKS
			AMPS	VOLT				
EF-B TYP.	BROAN MODEL BHF110	110	14	120	CEILING	2	(3) BATHROOMS & DANIEL BEDRM	1,2,3,4,5
			HEATER: 1500 WATTS FAN: 35 WATTS					
NOTE: PROVIDE EXHAUST FANS WITH CONTROLS, ROUGH-IN HOUSING, ETC. AS RECOMMENDED BY MANUFACTURER FOR A COMPLETE INSTALLATION PACKAGE					REMARKS: 1. PROVIDE WITH UNIT MOUNTED DISCONNECT 2. PROVIDE WITH WHITE CEILING GRILLE 3. PROVIDE WITH BACKDRAFT DAMPER 4. INTERLOCK WITH LIGHT SWITCH AS NOTED 5. POWER HEAT			

ELECTRICAL CALCULATIONS

TOTAL ENCLOSED AREA 2,135 SF * 3 VA/SF	8,205 VA
SMALL APPLIANCE (12) * 1500 VA/EA	18,000 VA
LAUNDRY (1) * 1500 VA EA	1,500 VA
DRYER	5,000 VA
RANGE/GAS	4,500 VA
WATER HEATER	4,500 VA
DISHWASHER	400 VA
SUB-TOTAL	38,105 VA
FIRST 10,000 VA * 100%	10,000 VA
28,105 VA * 40%	11,242 VA
HVAC (VERIFY)	4,000 VA
TOTAL VA LOAD	25,242 VA
25,242 VA/240 PROVIDE 200 AMP SERVICE	104 AMPS

POWER LEGEND

⊕	15 AMP DOUBLE CONVENIENCE OUTLET
⊕ A/GFI	20 AMP DOUBLE CONVENIENCE OUTLET GROUND FAULT INTERRUPTER
⊕ GFI	15 AMP DOUBLE CONVENIENCE OUTLET GROUND FAULT INTERRUPTER
⊕ A	20 AMP DOUBLE CONVENIENCE OUTLET
⊕ WP	15 AMP DOUBLE CONVENIENCE OUTLET WATER PROOF
⊕	15 AMP SINGLE CONVENIENCE OUTLET SINGLE CIRCUIT
⊕ TV/DATA	TV/DATA CAT 6
⊕ AHU	AIR HANDLER UNIT / VERIFY
⊕ DRYER	CLOTHES DRYER
⊕ DW	DISH WASHER
⊕ RANGE	RANGE OUTLET / VERIFY
⊕	15 AMP DOUBLE CONVENIENCE FLOOR OUTLET
NOTE: ALL DOUBLE CONVENIENCE OUTLETS TO BE ARC FAULT	


LIGHTING LEGEND

○	SURFACE OR RECESSED CEILING MOUNTED FIXTURE AS SELECTED
⊕	CEILING MOUNTED FIXTURE WITH MOTION CONTROL SWITCH
⊕ EF	EXHAUST FAN CONNECTED TO LIGHT FIXTURE
⊕	2 X 4 SURFACE MOUNTED FIXTURE
⊕	1 X 4 SURFACE MOUNTED FIXTURE
⊕ M	SOFFIT MOUNTED MOTION ACTIVATED WATERPROOF FIXTURE
⊕	WALL MOUNTED WATERPROOF FIXTURE
⊕	SOFFIT MOUNTED WATERPROOF FIXTURE
S	SINGLE POLE SWITCH
S ²	MULTI POLE SWITCH AS REQUIRED
S ^D	SWITCH WITH DIMMER

LIFE SAFETY LEGEND

⊕ SD	HARD WIRED SMOKE DETECTOR AND CARBON MONOXIDE DETECTOR
------	---

ELECTRICAL RISER

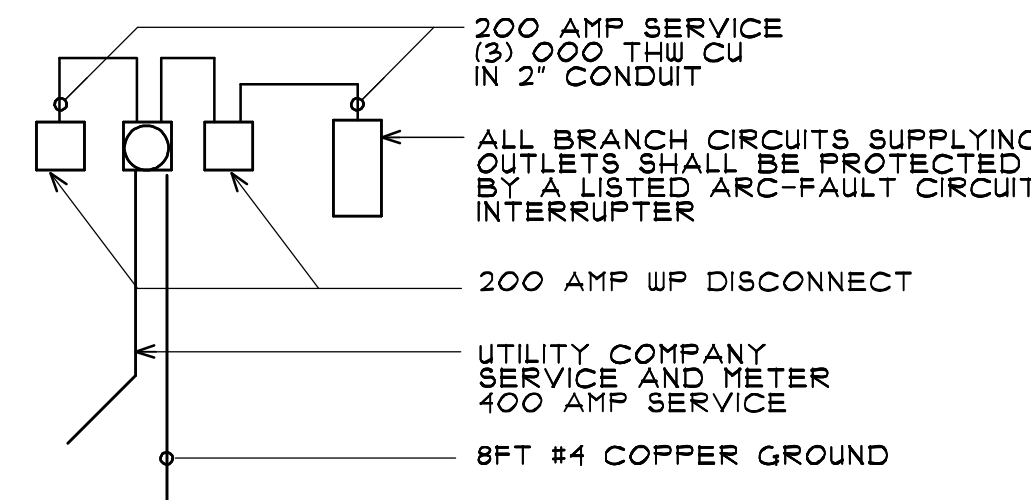

the
rickman
partnership
inc

architecture and interior design

4328 NORTHWEST 29 TERRACE
GAINESVILLE, FL 32605
rickmanpartnership@att.net
(352) 339-1834

FLORIDA LICENSE-AAC00126
FLORIDA LICENSE-IB00000891



RESIDENCE
FOR

KIM McCONNELL
AND
DANIEL McCONNELL

18818 SOUTH US HIGHWAY 441
HIGH SPRINGS, FL 32643

DATE	DESCRIPTION

CONSTRUCTION DOCUMENTS

PROJECT NO. 2405


DATE: 11 OCTOBER 2024

SHEET:

A-06

OF: ELEVEN

Smoke and carbon alarms required outside
all BDRM's per FBC R314 and R315

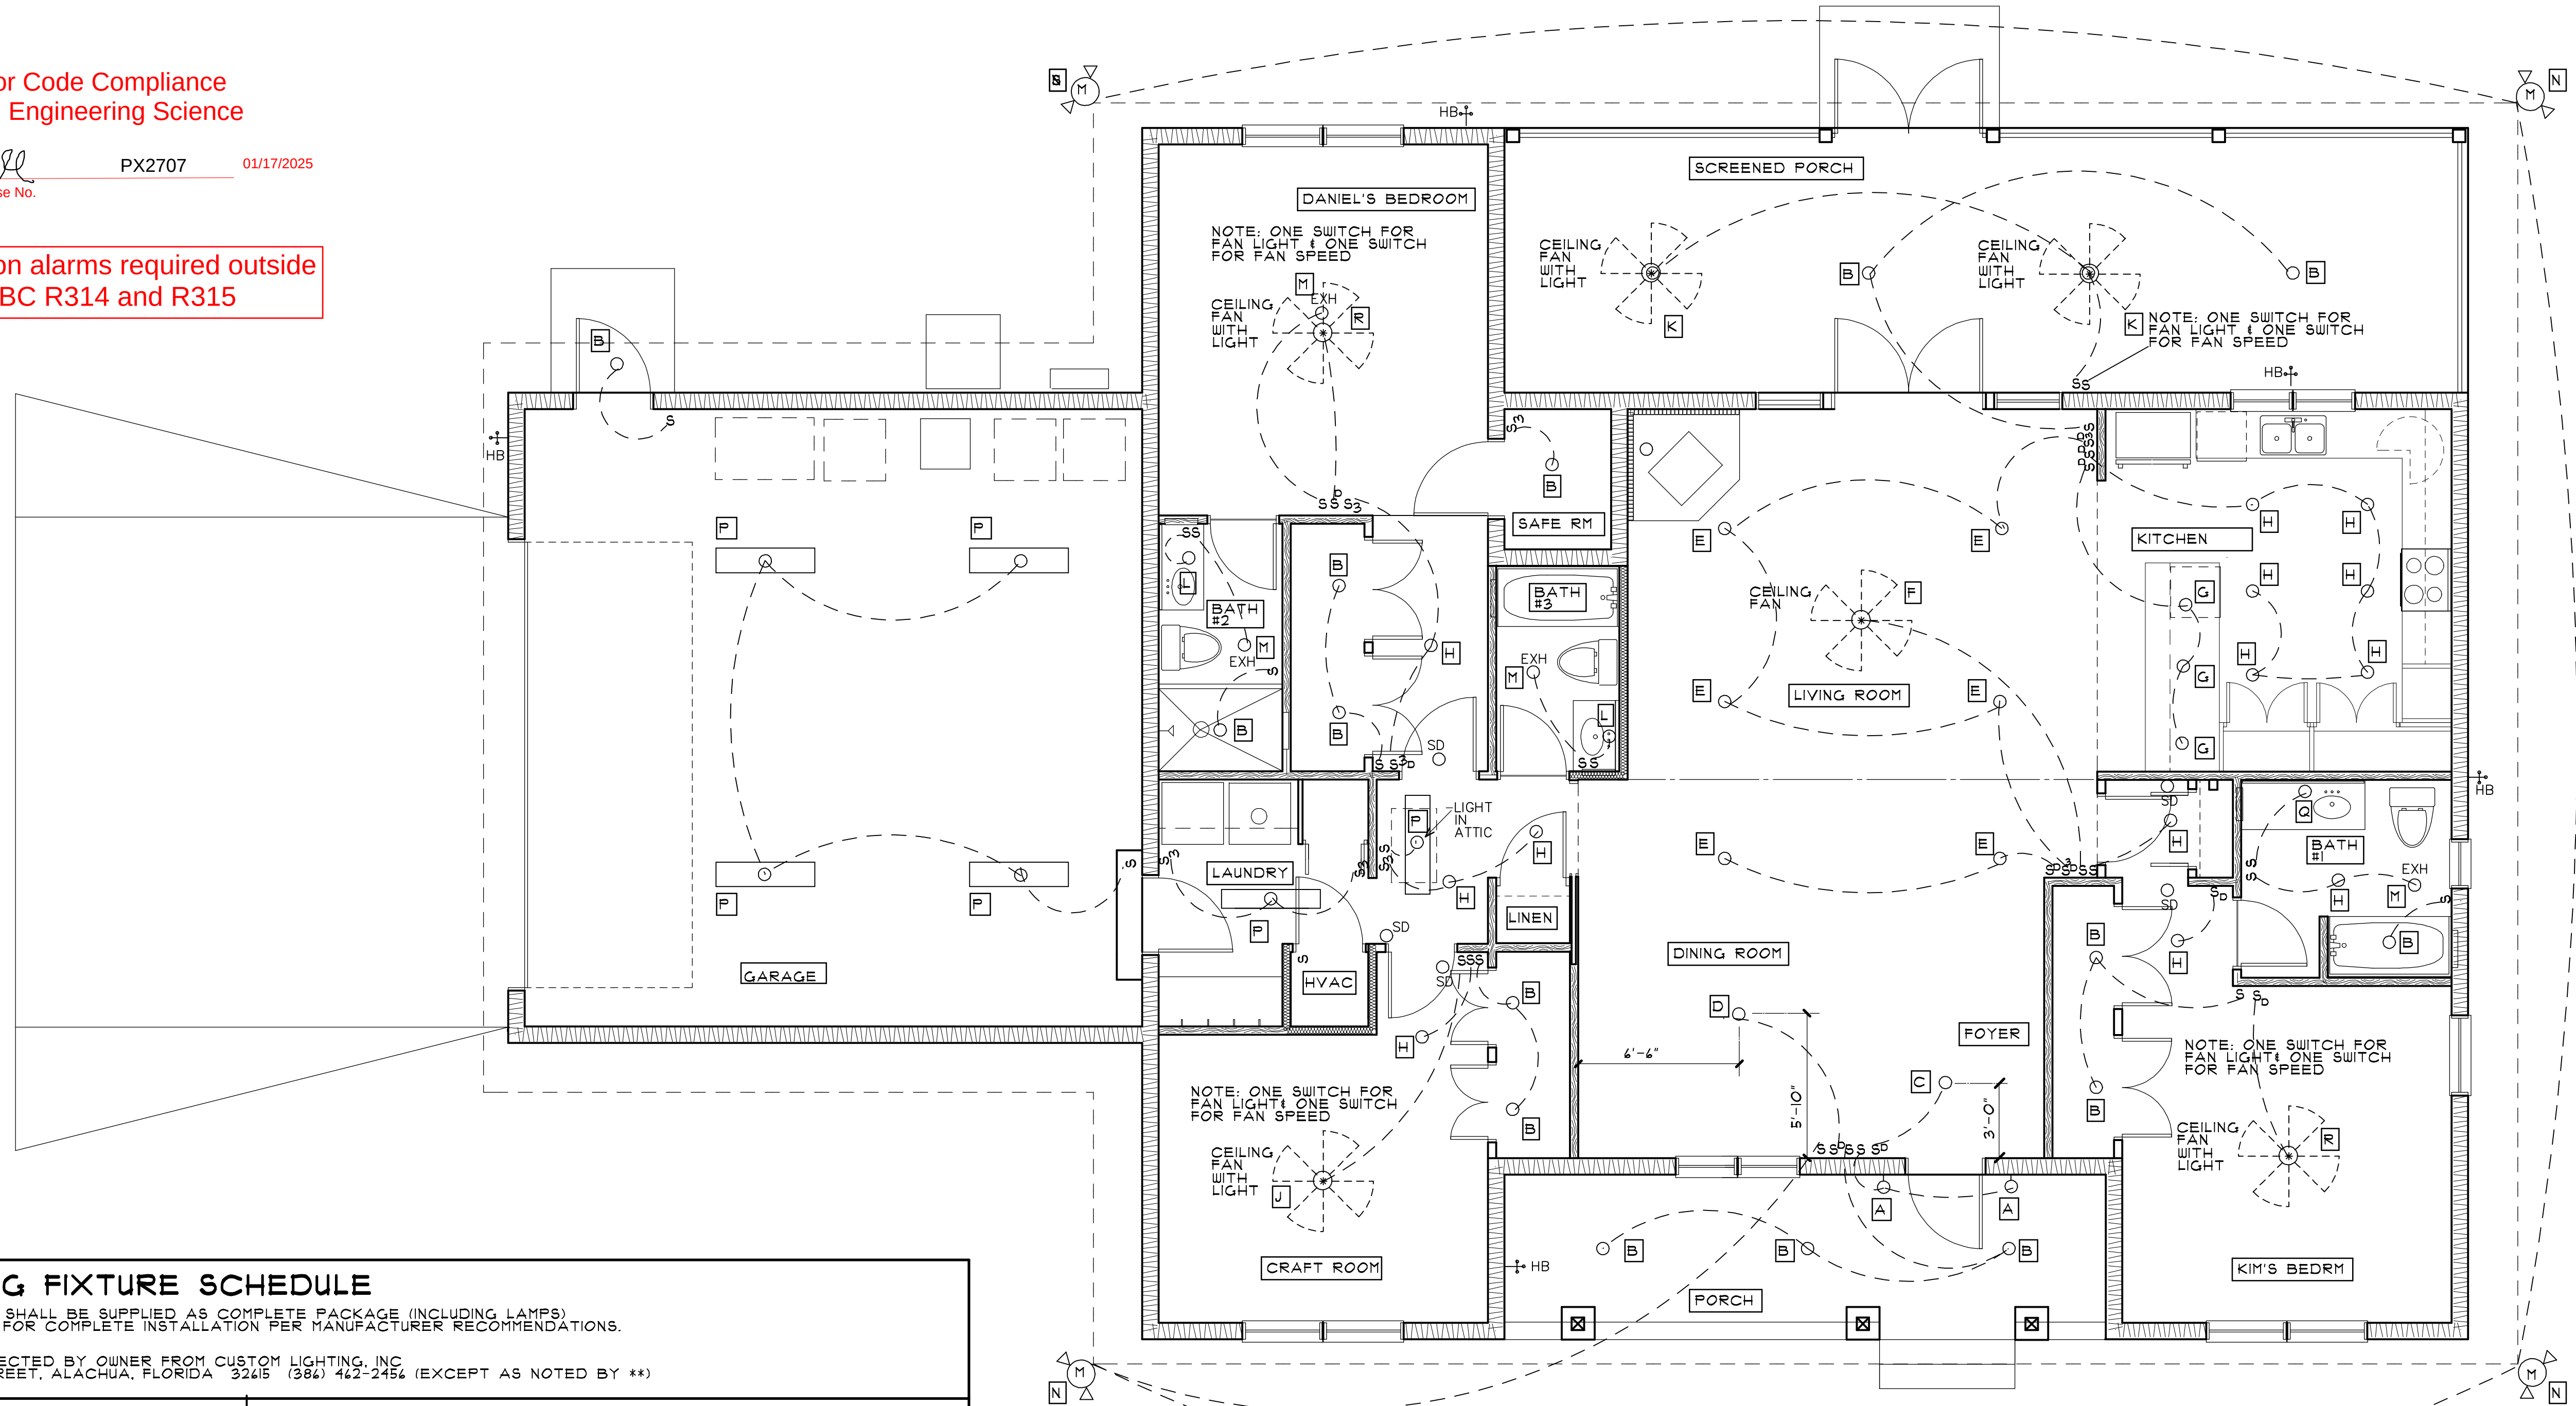

LIGHTING FIXTURE SCHEDULE

ALL FIXTURES SHALL BE SUPPLIED AS COMPLETE PACKAGE (INCLUDING LAMPS)
AS REQUIRED FOR COMPLETE INSTALLATION PER MANUFACTURER RECOMMENDATIONS.

FIXTURES SELECTED BY OWNER FROM CUSTOM LIGHTING, INC.
14545 MAIN STREET, ALACHUA, FLORIDA 32415 (386) 422-2454 (EXCEPT AS NOTED BY **)

MARK	FIXTURE	DESCRIPTION
A	WALL MOUNTED FIXTURE/EXTERIOR	2150 OZ
B	RECESSED FIXTURE/INT, EXT	HALO QUICKLINK/LT4-DM TRIAC LOW VOLTAGE KIT WITH DRIVER**
C	CLG HUNG CHANDLIER ON ROD	538131 WG
D	CLG HUNG CHANDLIER ON ROD	4386 MG
E	RECESSED FIXTURES/SLOPED CLG	HALO HL6 SERIES/ALLSLOPE LED RECESSED **
F	CLG FAN ON ROD	78605-86 CHATEAUZ 60" OILED BRONZE WITH WALNUT/OILED BRONZE BLADES
G	KITCHEN PENDANTS	206-AB-G18 FROSTED
H	RECESSED FIXTURES/FLAT CLG	HALO QUICKLINK/LT4-DM TRIAC LOW VOLTAGE LIGHTING KIT **
J	CLG FAN WITH LIGHT ON ROD	F695-WH
K	W/F CLG FAN WITH LIGHT ON ROD	F589-MW
L	CLG MOUNT FIXTURE OVER LAV	205-AB-G18I FROSTED
M	EXHAUST FAN	SEE SCHEDULE/SHEET A-04
N	MOTION SENSOR EAVE MOUNTED	DEFIANT, 1400 LUMEN, TWIN HEAD WHITE MOTION SENSOR, 180 DEGREE LED SECURITY FLOOD LIGHT **
O	NOT USED	NOT USED
P	CLG MOUNT IX4 LED	COMMERCIAL ELECTRIC, LED IX4 FRAMELESS PANEL WITH DIMMER **
Q	CLG MOUNT FIXTURE OVER LAV	215-AB-G18I FROSTED
R	CLG FAN WITH LIGHT ON ROD	F696-WH

LAMPS AND ACCESSORIES FOR FIXTURES

LAMPS FOR FIXTURES:
A, C, D, F, G, K, L, J, O, R
WILL BE PROVIDED BY CUSTOM LIGHTING, INC
IN PACKAGE AS SELECTED BY OWNER.


LAMPS FOR FIXTURES "B, E, H"
RECEIVER ONLY FOR LIGHT KIT K9115L

WARM COLOR RANGE
LO01041010

LAMPS FOR FIXTURE "P"

COOL COLOR RANGE

LIGHTING PLAN

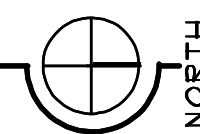

SCALE 1/4"=1'-0"

the
rickman
partnership
inc

architecture and interior design

4328 NORTHWEST 29 TERRACE
GAINESVILLE, FL 32605
rickmanpartnership@att.net
(352) 339-1824

FLORIDA LICENSE-AAC000126
FLORIDA LICENSE-IB00000891



RESIDENCE
FOR

KIM McCONNELL
AND
DANIEL McCONNELL

18818 SOUTH US HIGHWAY 441
HIGH SPRINGS, FL 32643

DATE	DESCRIPTION

CONSTRUCTION DOCUMENTS

PROJECT NO. 2405

DATE: 11 OCTOBER 2024

SHEET:

A-01

OF: ELEVEN

WINDOW SCHEDULE					WINDOW NUMBER 	SUBMITTALS TO BE APPROVED BY OWNER PRIOR TO ORDERING CONTRACTOR TO VERIFY ALL WINDOW SIZES PRIOR TO ORDERING
WIN NO.	WIDTH x HEIGHT	FRAME	GLAZING	REMARKS		
A	(2) 2'-6" X 5'-0" NOMINAL	VINYL	LOW E HIGH IMPACT	YKK AP AMERICA INC. SINGLE HUNG FPA# FL8I14.1		
B	(2) 3'-0" X 5'-0" NOMINAL	VINYL	LOW E HIGH IMPACT	YKK AP AMERICA INC. SINGLE HUNG FPA# FL8I14.4		
C	3'-0" X 3'-0" NOMINAL	VINYL	LOW E HIGH IMPACT	YKK AP AMERICA INC. SINGLE HUNG FPA# FL8I14.4		
D	2'-0" X 3'-0" NOMINAL	VINYL	LOW E HIGH IMPACT	YKK AP AMERICA INC. SINGLE HUNG FPA# FL8I14.4		
E	(2) 2'-6" X 3'-0" NOMINAL	VINYL	LOW E HIGH IMPACT	YKK AP AMERICA INC. BI-PASS FPA# FL12284.1		
F	(2) 3'-0" X 5'-0" NOMINAL	VINYL	LOW E HIGH IMPACT	YKK AP AMERICA INC. SINGLE HUNG FPA# FL8I14.4		
G	(2) 3'-0" X 5'-0" NOMINAL	VINYL	LOW E HIGH IMPACT	YKK AP AMERICA INC. SINGLE HUNG FPA# FL8I14.4		


DOOR SCHEDULE							DOOR NUMBER 	SUBMITTALS TO BE APPROVED BY OWNER PRIOR TO ORDERING CONTRACTOR TO VERIFY ALL DOOR SIZES PRIOR TO ORDERING
DOOR NO.	WIDTH x HEIGHT	THRESHOLD	FRAME		DOOR		REMARKS	
			MATERIAL	FINISH	MATERIAL	FINISH		
001	3'-0" X 4'-8"	ALUMINUM	FIBERGLASS	PREFINISHED	FIBERGLASS	PREFINISHED	JELD WEN DESIGN PRO; 6 PANEL, ALL PANEL FL13541.1	
002	(2) 3'-0" X 4'-8"	ALUMINUM	FIBERGLASS	PREFINISHED	FIBERGLASS	PREFINISHED	JELD WEN DESIGN PRO; 6 PANEL, ALL PANEL FL13541.3	
003	(2) 3'-0" X 4'-8"	ALUMINUM	FIBERGLASS	PREFINISHED	FIBERGLASS	PREFINISHED	SCREEN DOORS SUPPLIED BY SCREEN ENCLOSURE SUPPLIER	
004	3'-0" X 4'-8"	ALUMINUM	FIBERGLASS	PREFINISHED	FIBERGLASS	PREFINISHED	JELD WEN DESIGN PRO; 6 PANEL, ALL PANEL FL13541.1	
005	18'-0" X 1'-0"	-	-	-	-	-	OVERHEAD THERMACORE 5145 SERIES, WINDLOAD, FL38451	
006	2'-8" X 4'-8"	NONE	WOOD	PAINT	WOOD	PAINT	FIVE RECESSED PANELS/OGEE TRIM	
007	3'-0" X 4'-8" OPENING	NONE	WOOD	PAINT	WOOD	PAINT	FIVE RECESSED PNLS-OGEE TRIM, (2) DR BI-FOLD	
008	2'-8" X 4'-8"	MARBLE	WOOD	PAINT	WOOD	PAINT	FIVE RECESSED PANELS/OGEE TRIM	
009	(2) 2'-0" X 4'-8"	NONE	WOOD	PAINT	WOOD	PAINT	FIVE RECESSED PANELS/OGEE TRIM	
010	(2) 2'-0" X 4'-8"	NONE	WOOD	PAINT	WOOD	PAINT	SOLID CORE WITH FIVE RECESSED PANELS/OGEE TRIM	
011	4'-0" X 4'-8"	NONE	WOOD	PAINT	WOOD	PAINT	FIVE RECESSED PNLS/OGEE TRIM, POCKET DR WITH JOHNSON 1500 HD SERIES POCKET DR FRAME, SOFT CLOSE	
012	2'-8" X 4'-8"	MARBLE	WOOD	PAINT	WOOD	PAINT	FIVE RECESSED PANELS/OGEE TRIM	
013	2'-8" X 4'-8"	NONE	WOOD	PAINT	WOOD	PAINT	FIVE RECESSED PANELS/OGEE TRIM	
014	2'-8" X 4'-8"	NONE	WOOD	PAINT	WOOD	PAINT	FIVE RECESSED PANELS/OGEE TRIM	
015	(2) 1'-4" X 4'-8"	NONE	WOOD	PAINT	WOOD	PAINT	FIVE RECESSED PANELS/OGEE TRIM	
016	(2) 1'-6" X 4'-8"	NONE	WOOD	PAINT	WOOD	PAINT	FIVE RECESSED PANELS/OGEE TRIM	
017	2'-8" X 4'-8"	NONE	WOOD	PAINT	WOOD	PAINT	FIVE RECESSED PNLS/OGEE TRIM WITH ACOUSTICAL SEAL	
018	3'-0" X 4'-8"	ALUMINUM	WOOD	PAINT	WOOD	PAINT	FIVE RECESSED PANELS/OGEE TRIM	
019	2'-4" X 4'-8"	NONE	WOOD	PAINT	WOOD	PAINT	FIVE RECESSED PNLS/OGEE TRIM, (2) DR BI-FOLD	
020	2'-8" X 4'-8"	NONE	WOOD	PAINT	WOOD	PAINT	FIVE RECESSED PANELS/OGEE TRIM	
021	(2) 2'-0" X 4'-8"	NONE	WOOD	PAINT	WOOD	PAINT	FIVE RECESSED PANELS/OGEE TRIM	
022	(2) 2'-0" X 4'-8"	NONE	WOOD	PAINT	WOOD	PAINT	FIVE RECESSED PANELS/OGEE TRIM	
023	3'-0" X 4'-8"	NONE	METAL	PAINT	METAL	PAINT	METAL FLUSH DOOR	
024	2'-8" X 4'-8"	MARBLE	WOOD	PAINT	WOOD	PAINT	FIVE RECESSED PANELS/OGEE TRIM	
-	-	-	-	-	-	-	-	

HARDWARE SCHEDULE	
ENTRANCE DOORS: 001, 004, 018 EXTERIOR HANDSET: SCHLAGE-BF SERIES FINISH: BRIGHT BRASS; STYLE: CAMELOT INTERIOR HANDSET: SCHLAGE-F SERIES DEADBOLT-DOUBLE CYLINDER, SCHLAGE B SERIES 1-1/2 PAIR BUTTS, 4X4 FBB, HRP THRESHOLD-PENKO 200BT SILL NOSING-PENKO 326/A	DOORS: 013, 017 PASSAGE LOCK, SCHLAGE FIO WITH TRIM ON ONE SIDE ONLY FINISH: BRIGHT BRASS; STYLE: CALLINGTON 1-1/2 PAIR 3-1/2X3-1/2 BUTTS DOOR 017: PENKO 350 CSR SOUND SEAL
BEDROOM, CRAFT ROOM DOORS: 004, 014, 020 PRIVACY: SCHLAGE F40 FINISH: BRIGHT BRASS; STYLE: CALLINGTON 1-1/2 PAIR BUTTS, 3-1/2 C 3-1/2 RC	DOOR: 002: LOCKSET, SCHLAGE FES95 KEYPAD WITH FLEXLOCK FINISH: BRIGHT BRASS; 1-1/2 PAIR 4X4 FBB BUTTS, NRP PER DOOR FLUSH BOLT TOP AND BOTTOM-IVES FB358 MANUAL FLUSH BOLT
BATHROOM DOORS: 024, 012, 008 PRIVACY: SCHLAGE F40 FINISH: BRIGHT BRASS; STYLE: CALLINGTON 1-1/2 PAIR 3-1/2X3-1/2 BUTTS RC MARBLE THRESHOLD	DOOR: 023 LOCKSET- BE449NX-TOUCHSCREEN DEADBOLT WITH ALARM FINISH: BRIGHT BRASS 50SS INVISIBLE HINGE 1-1/2 PAIR MODEL 416 SATIN BRASS
DOORS: 015, 016, 009, 010, 022, 021 PULL-TO BE SELECTED BY OWNER FINISH: BRIGHT BRASS 1-1/2 PAIR 3-1/2X3-1/2 RC BUTTS HARDWARE RESOURCES ISLD DOUBLE MAGNETIC CATCH	DOOR: 011 POCKET DOOR HARDWARE JOHNSON (1500HD SERIES) #154048 HEAVY DUTY POCKET DOOR HARDWARE FINISH: BRIGHT BRASS 1-3/8X2" RECTANGULAR PULL 150 EDGE PULL
GARAGE DOOR: 005 OVERHEAD THERMACORE 5145 SERIES WINDLOAD DOOR HARDWARE COMES WITH DOOR	DOOR: 001, 019 JOHNSON 1700 SERIES WHITE BI-FOLD DOOR TRACK AND HARDWARE SET WITH UNIVERSAL TOP GLIDE SET

PLUMBING FIXTURE SCHEDULE			PROVIDE COMPLETE FOR FINISHED INSTALLATION
FIXTURE TYPE	MANUFACTURE/NUMBER	REMARKS	
LAUNDRY SINK	TRANSOLID #5014110119 (LOWES)	22.1" X 28" ONE BASIN, BRUSHED SATIN, FREESTANDING WITH FAUCET & STAND	
WASHING MACHINE DRAIN PAN	AMERICAN BUILT PRO	30X28 PLASTIC DRAIN PAN WITH FLOOR DRAIN	
ALL PLUMBING FIXTURES AND FAUCETS SHALL BE SUPPLIED AS A PACKAGE THROUGH McCONNELLPROJECT@BUILD.COM (CONTACT PERSON: MALLORY NORTON) EXCEPT AS NOTED ABOVE.			

FINISH SCHEDULE							NOTE: FLOORING AS SELECTED BY OWNER.
ROOM NAME	WALLS: MATERIAL/FINISH	FLOORS: MATERIAL	BASE: MATERIAL/FIN	CEILING: MATERIAL/FINISH	CEILING HEIGHT	REMARKS	
ENTRY PORCH	HARDI LAP SIDING	BRICK	NONE	BEAD BD / PAINT	10'-0"	-	
DINING ROOM	DRYWALL / PAINT	LVP	WOOD/PAINT	DRYWALL / PAINT	10'-0"	-	
LIVING ROOM	DRYWALL / PAINT	LVP	WOOD / PAINT	DRYWALL / PAINT	VARIES	-	
KITCHEN	DRYWALL/ ENAMEL PAINT	LVP	WOOD / PAINT	DRYWALL / PAINT	10'-0"	ENAMEL PAINT	
KIM'S BEDROOM	DRYWALL / PAINT	LVP	WOOD / PAINT	DRYWALL / PAINT	10'-0"	-	
CLOSET 01	DRYWALL / PAINT	LVP	WOOD / PAINT	DRYWALL / PAINT	10'-0"	-	
BATHROOM 01	VINYL BEAD BD WAINSCOT	CERAMIC TILE	WOOD/PAINT ENAMEL PAINT	DRYWALL / PAINT ENAMEL PAINT	10'-0"	CERAMIC TILE ON WATERPROOF DRYWALL ON TUB WALLS	
DANIEL'S BR	DRYWALL / PAINT	LVP	WOOD / PAINT	DRYWALL / PAINT	10'-0"	-	
CLOSET 02	DRYWALL / PAINT	LVP	WOOD / PAINT	DRYWALL / PAINT	10'-0"	-	
BATHROOM 02	VINYL BEAD BD WAINSCOT	CERAMIC TILE	WOOD/PAINT ENAMEL PAINT	DRYWALL / PAINT ENAMEL PAINT	10'-0"	CERAMIC TILE ON WATERPROOF DRYWALL ON SHOWER WALLS	
SAFE ROOM	DRYWALL / PAINT	LVP	WOOD / PAINT	DRYWALL / PAINT	10'-0"	-	
BATHROOM 03	CER TILE WAINSCOT	CERAMIC TILE	CERAMIC TILE	DRYWALL / PAINT ENAMEL PAINT	10'-0"	CERAMIC TILE ON WATERPROOF DRYWALL ON TUB WALLS	
CRAFT ROOM	DRYWALL / PAINT	LVP	WOOD / PAINT	DRYWALL / PAINT	10'-0"	-	
STORAGE	DRYWALL / PAINT	LVP	WOOD / PAINT	DRYWALL / PAINT	10'-0"	-	
LAUNDRY	DRYWALL / PAINT	LVP	WOOD / PAINT	DRYWALL / PAINT	10'-0"	-	
SCR PORCH	HARDI BOARD	CONCRETE	WOOD / PAINT	BEAD BD / PAINT	10'-0"	-	
GARAGE	DRYWALL / PAINT	CONCRETE	WOOD / PAINT	DRYWALL / PAINT	10'-0"	-	

TILE SCHEDULE				TILE SELECTED BY OWNER FROM FLOOR DECOR STORE, GAINESVILLE (352) 420-8232
ROOM	LOCATION IN ROOM	DESCRIPTION	SKU #	
BATHROOMS #1, #3	WALLS OF BATHTUB	CALACATTA VECCHIA CERAMIC TILE; SIZE: 4"X4"	SKU# 101018103	
	FLOOR	TBD	TBD	
	ALCOVE IN TUB AREA	DECORATIVE TILE FOR ALCOVE WALL: (TBD)	TBD	
		PENCIL TILE FOR ALCOVE: (TBD)	TBD	
BATHROOMS #2	WALLS OF SHOWER	MANDALI NIGHT POLISHED PORCELAIN TILE; SIZE: 15"X30"	SKU# 10078630	
	FLOOR	TBD	TBD	
	ALCOVE IN TUB AREA	ARGENTO 2 IN. TUMBLER TRAVERTINE HEXAGON, MOSAIC; SIZE: 11"X12"	SKU# 100788033	
		PENCIL TILE FOR ALCOVE: (TBD)	TBD	
KITCHEN BACKSPLASH				TBD: TILE OR GRANITE/QUARTZ
				TBD

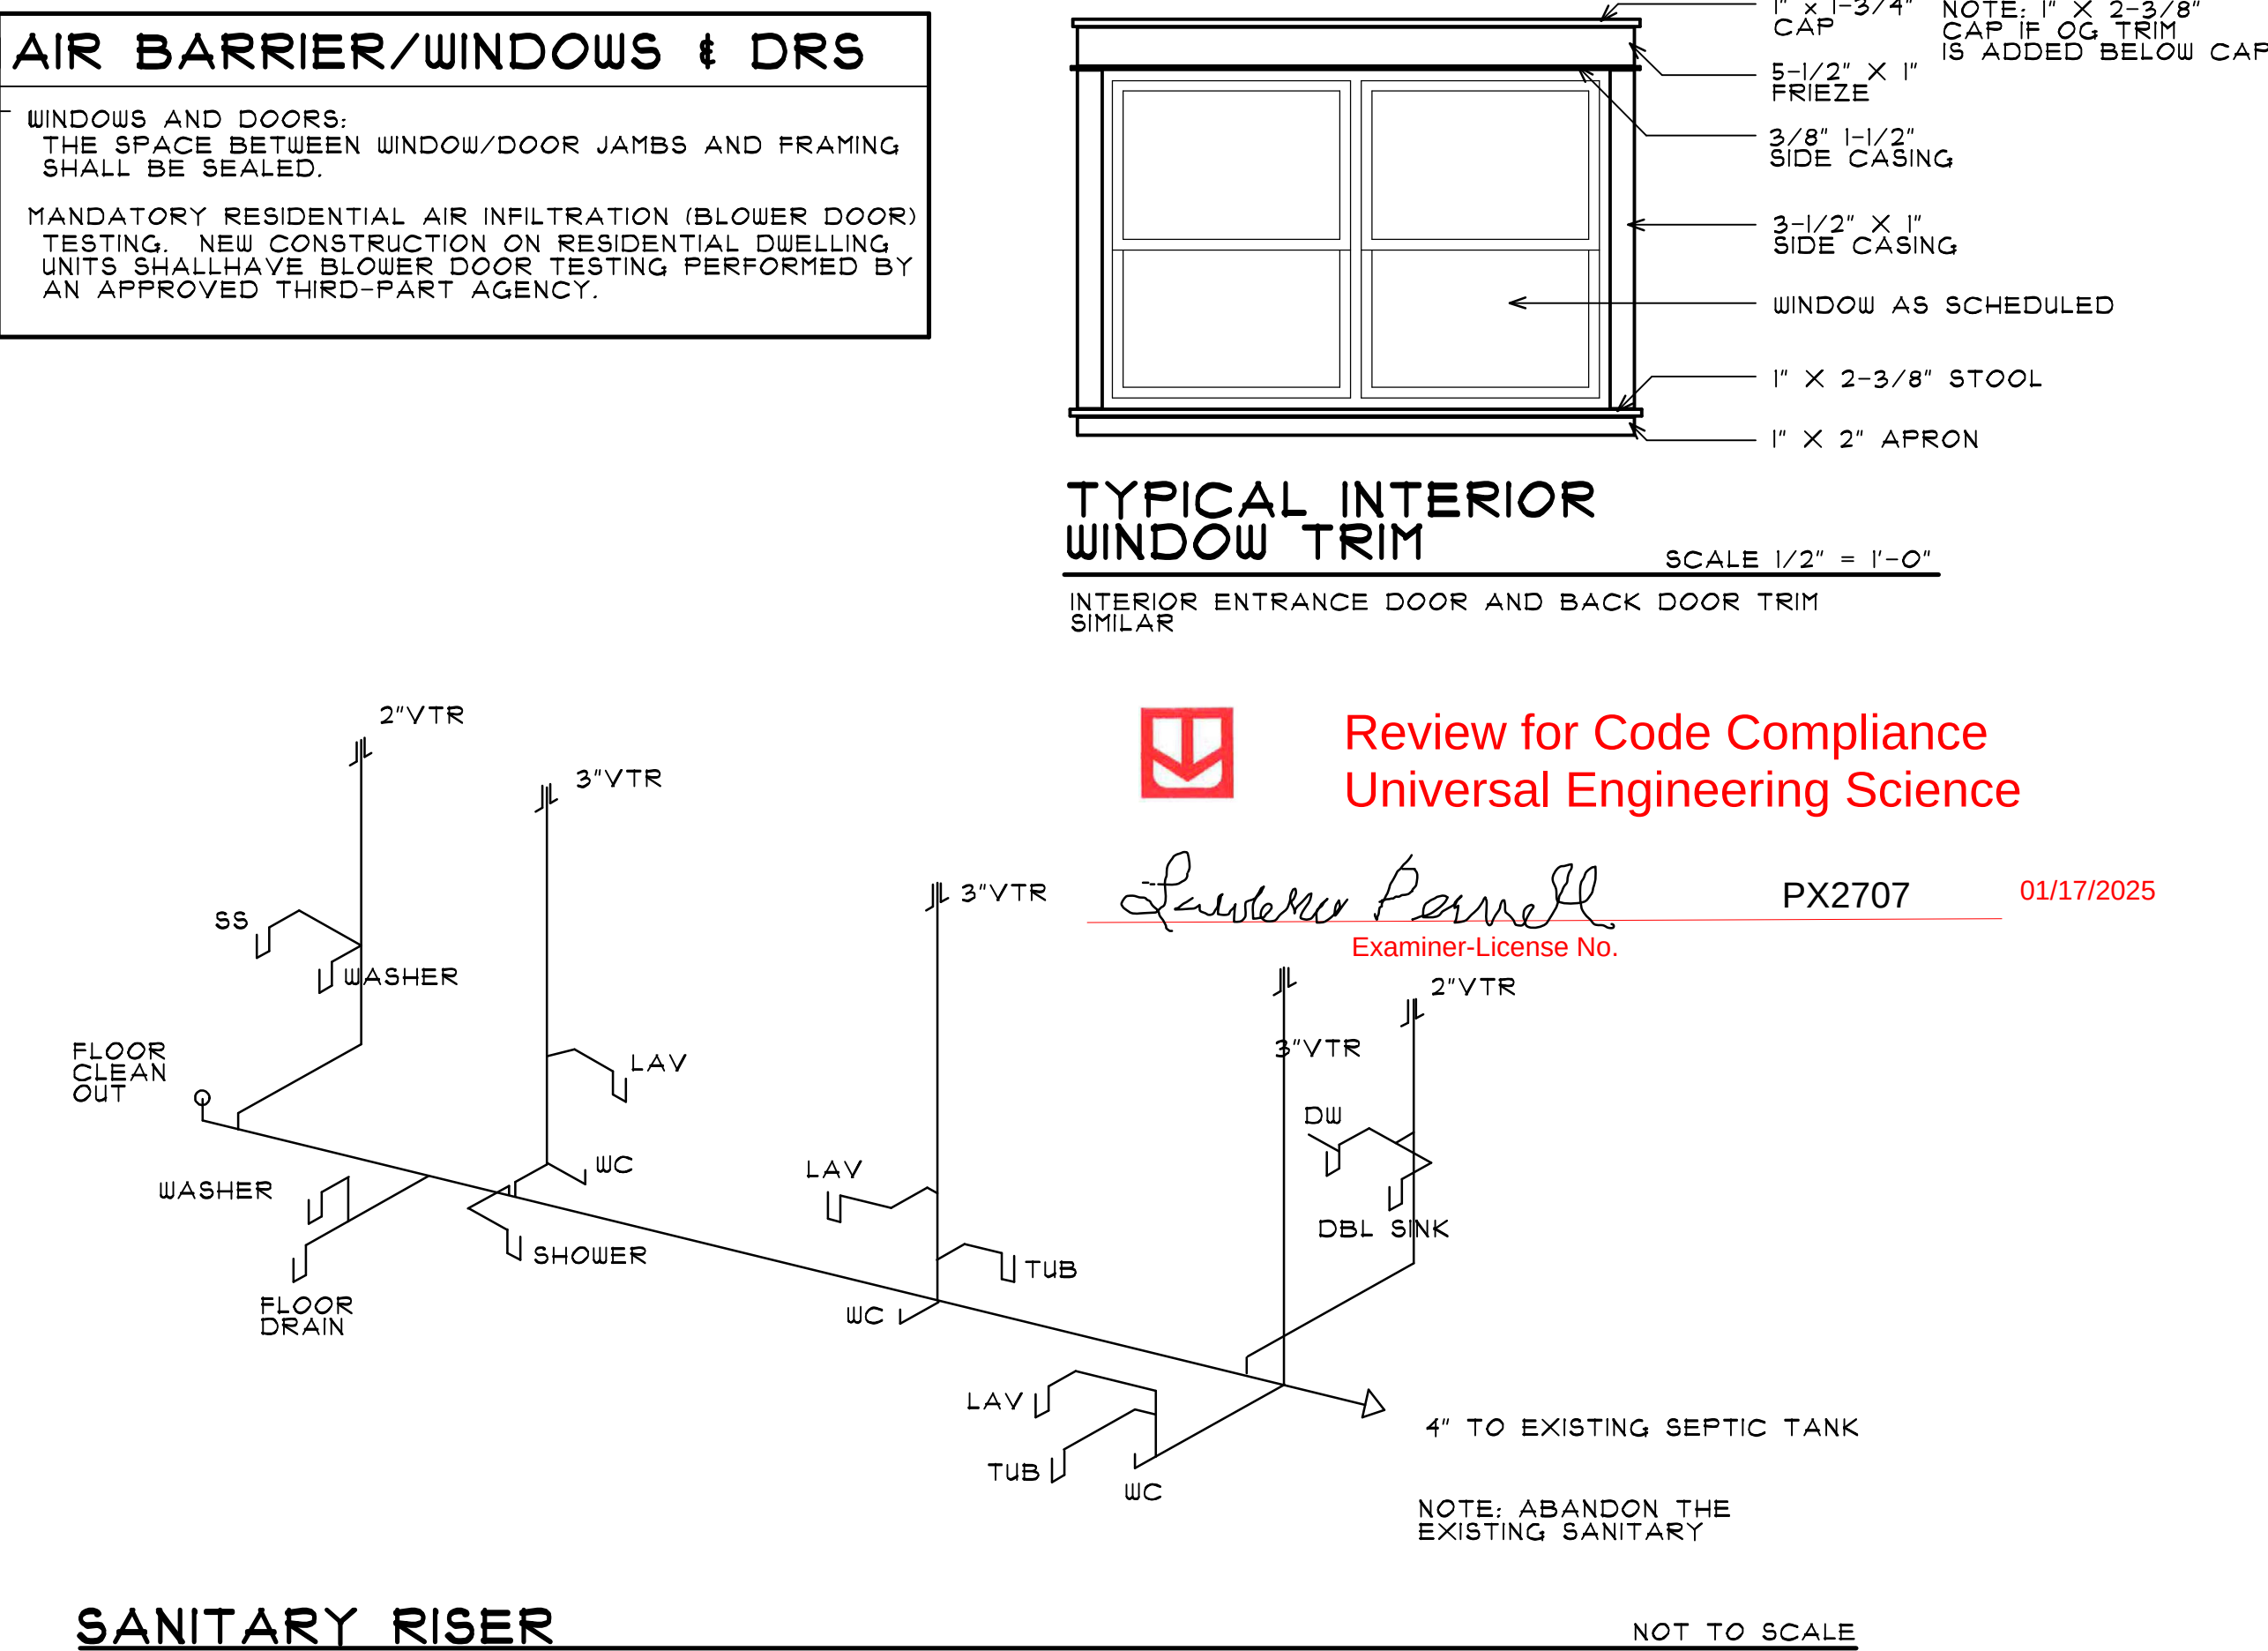

the
rickman
partnership
inc

architecture and interior design

4328 NORTHWEST 29 TERRACE
GAINESVILLE, FL 32605
rickmanpartnership@att.net
(352) 339-1834

FLORIDA LICENSE-AAC00126
FLORIDA LICENSE-IB0000891



RESIDENCE
FOR

KIM McCONNELL
AND
DANIEL McCONNELL

18818 SOUTH US HIGHWAY 441
HIGH SPRINGS, FL 32643





DATE	DESCRIPTION

CONSTRUCTION DOCUMENT


PROJECT NO. 2405

DATE: 11 OCTOBER 2024



SHEET:
A-08
OF: ELEVEN

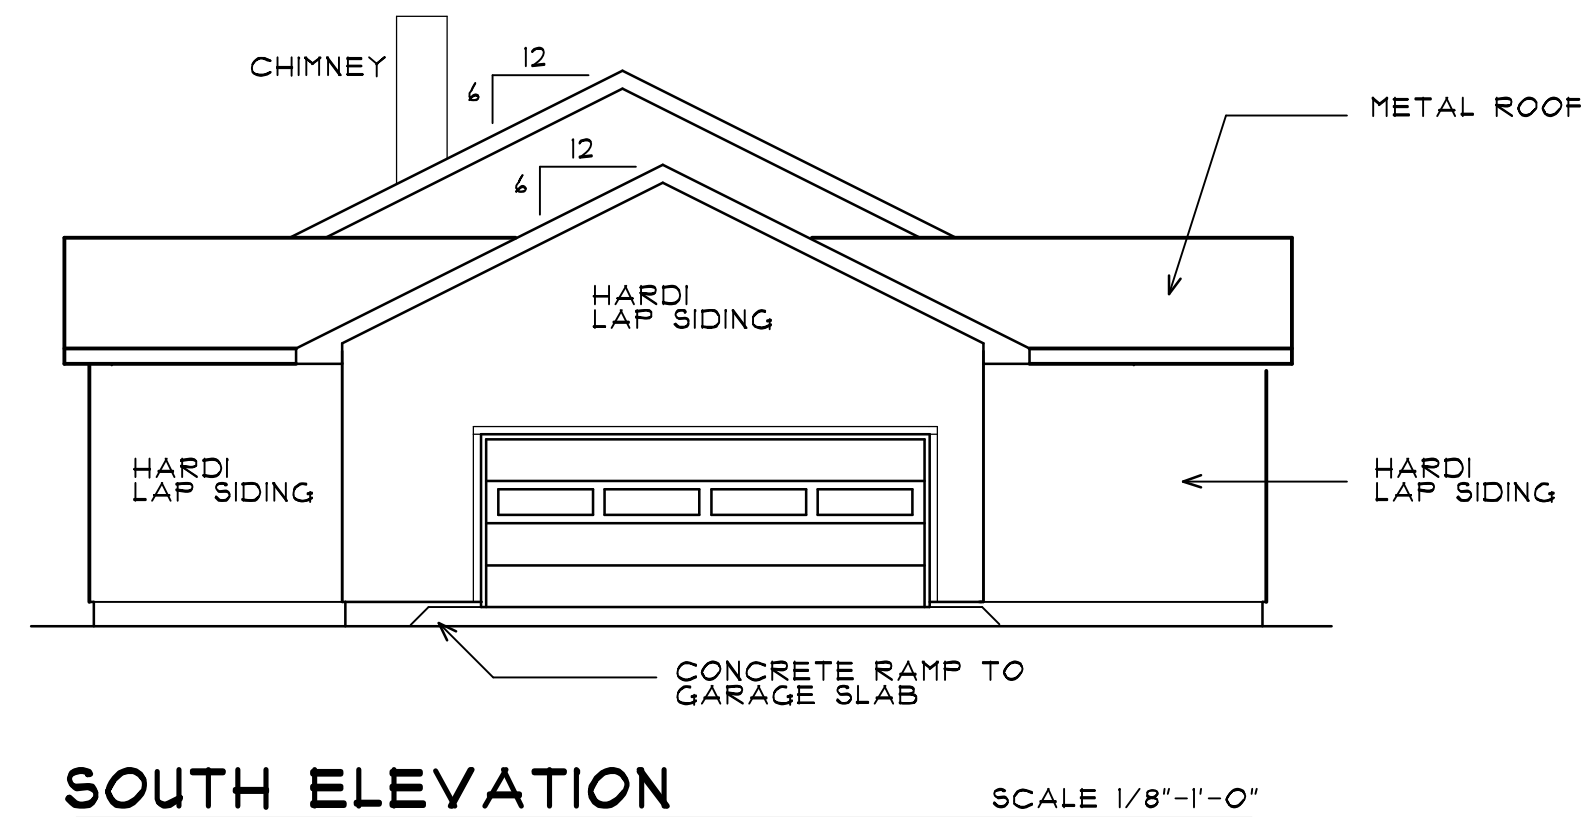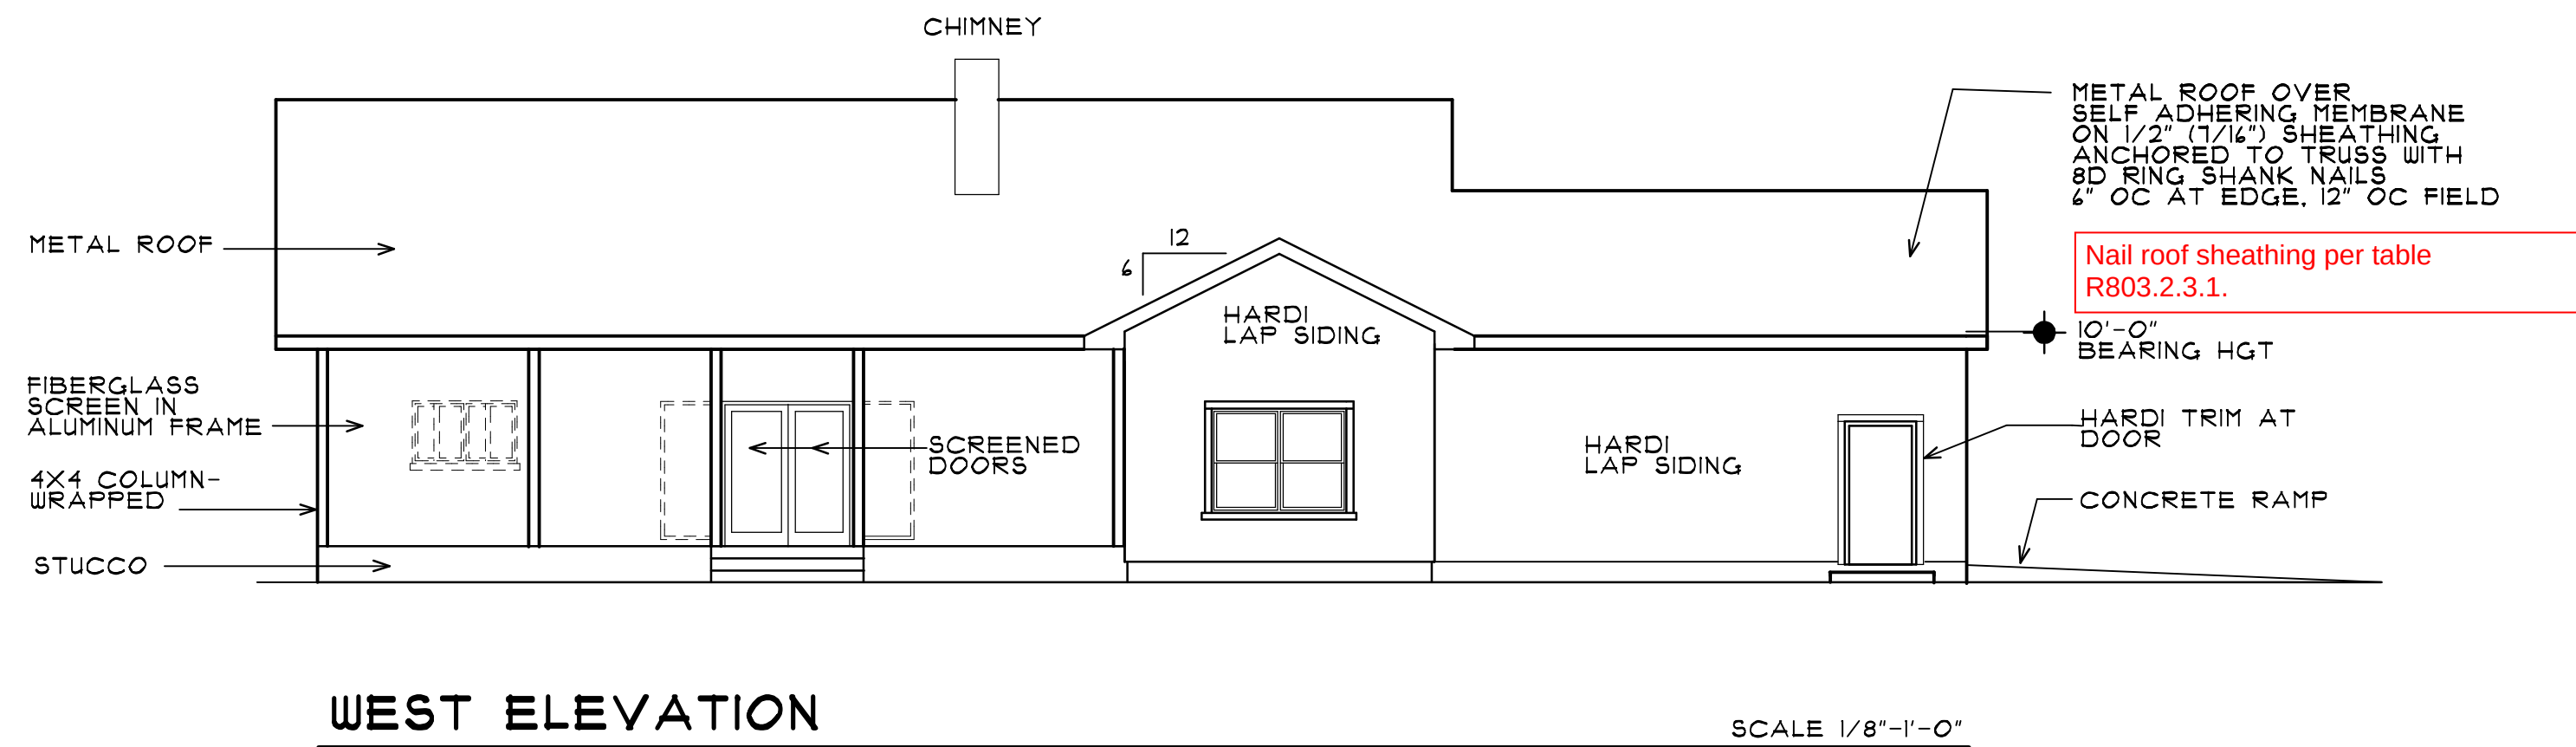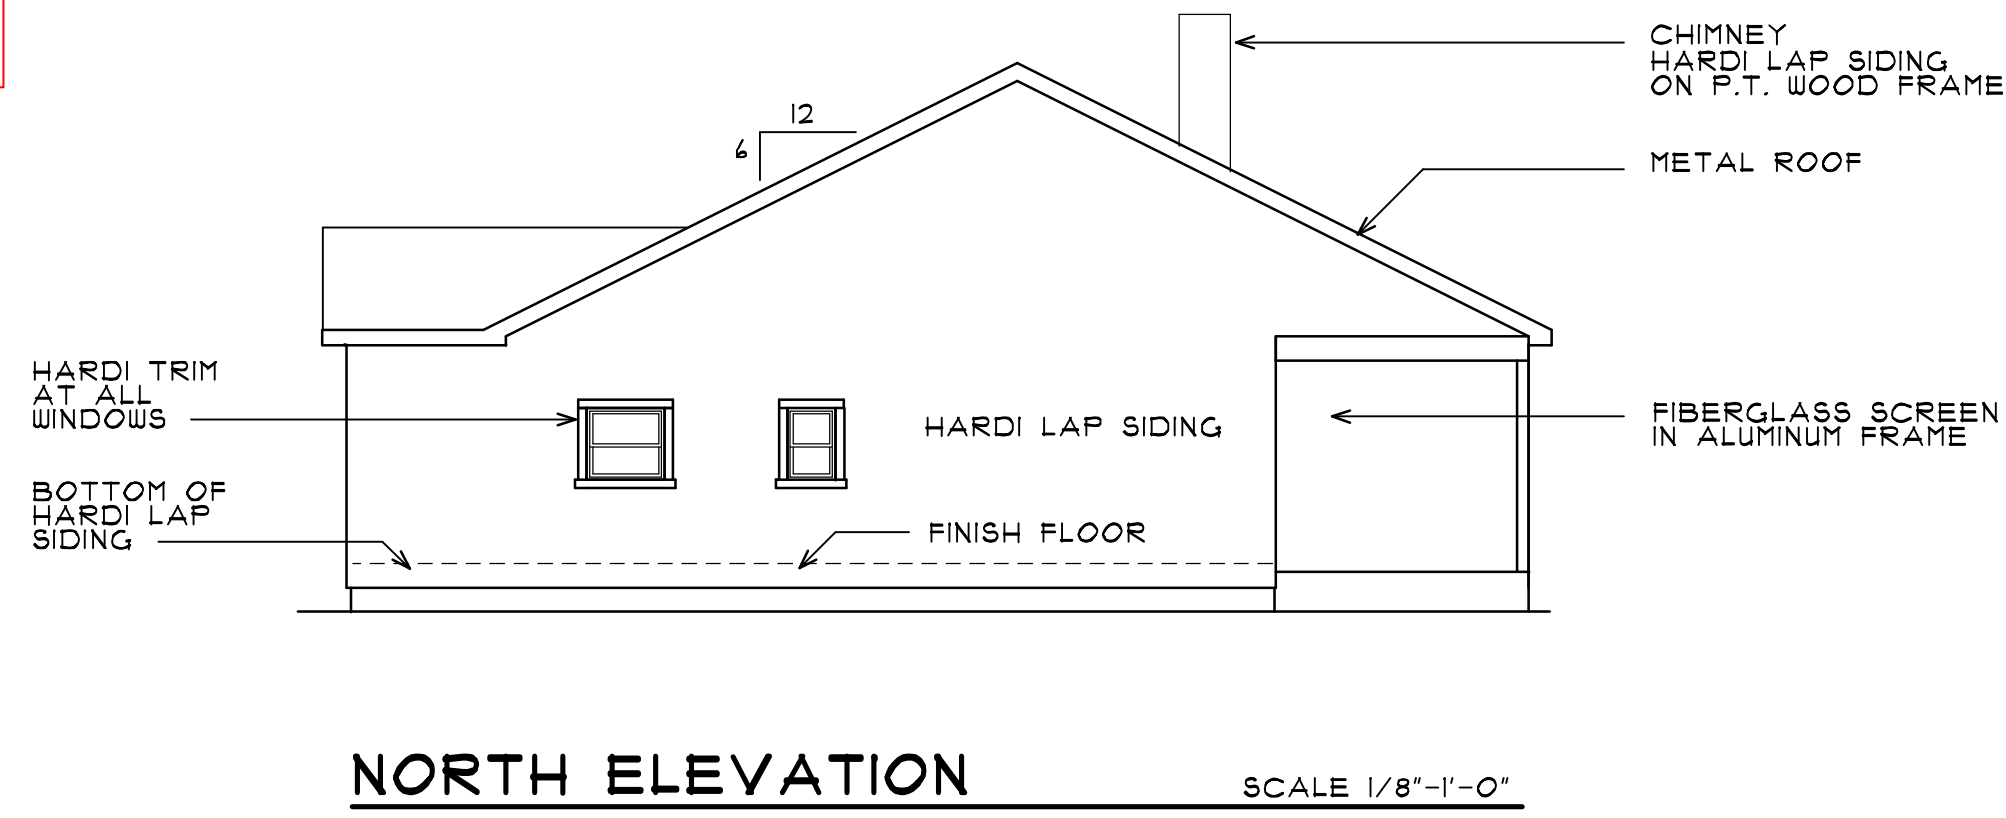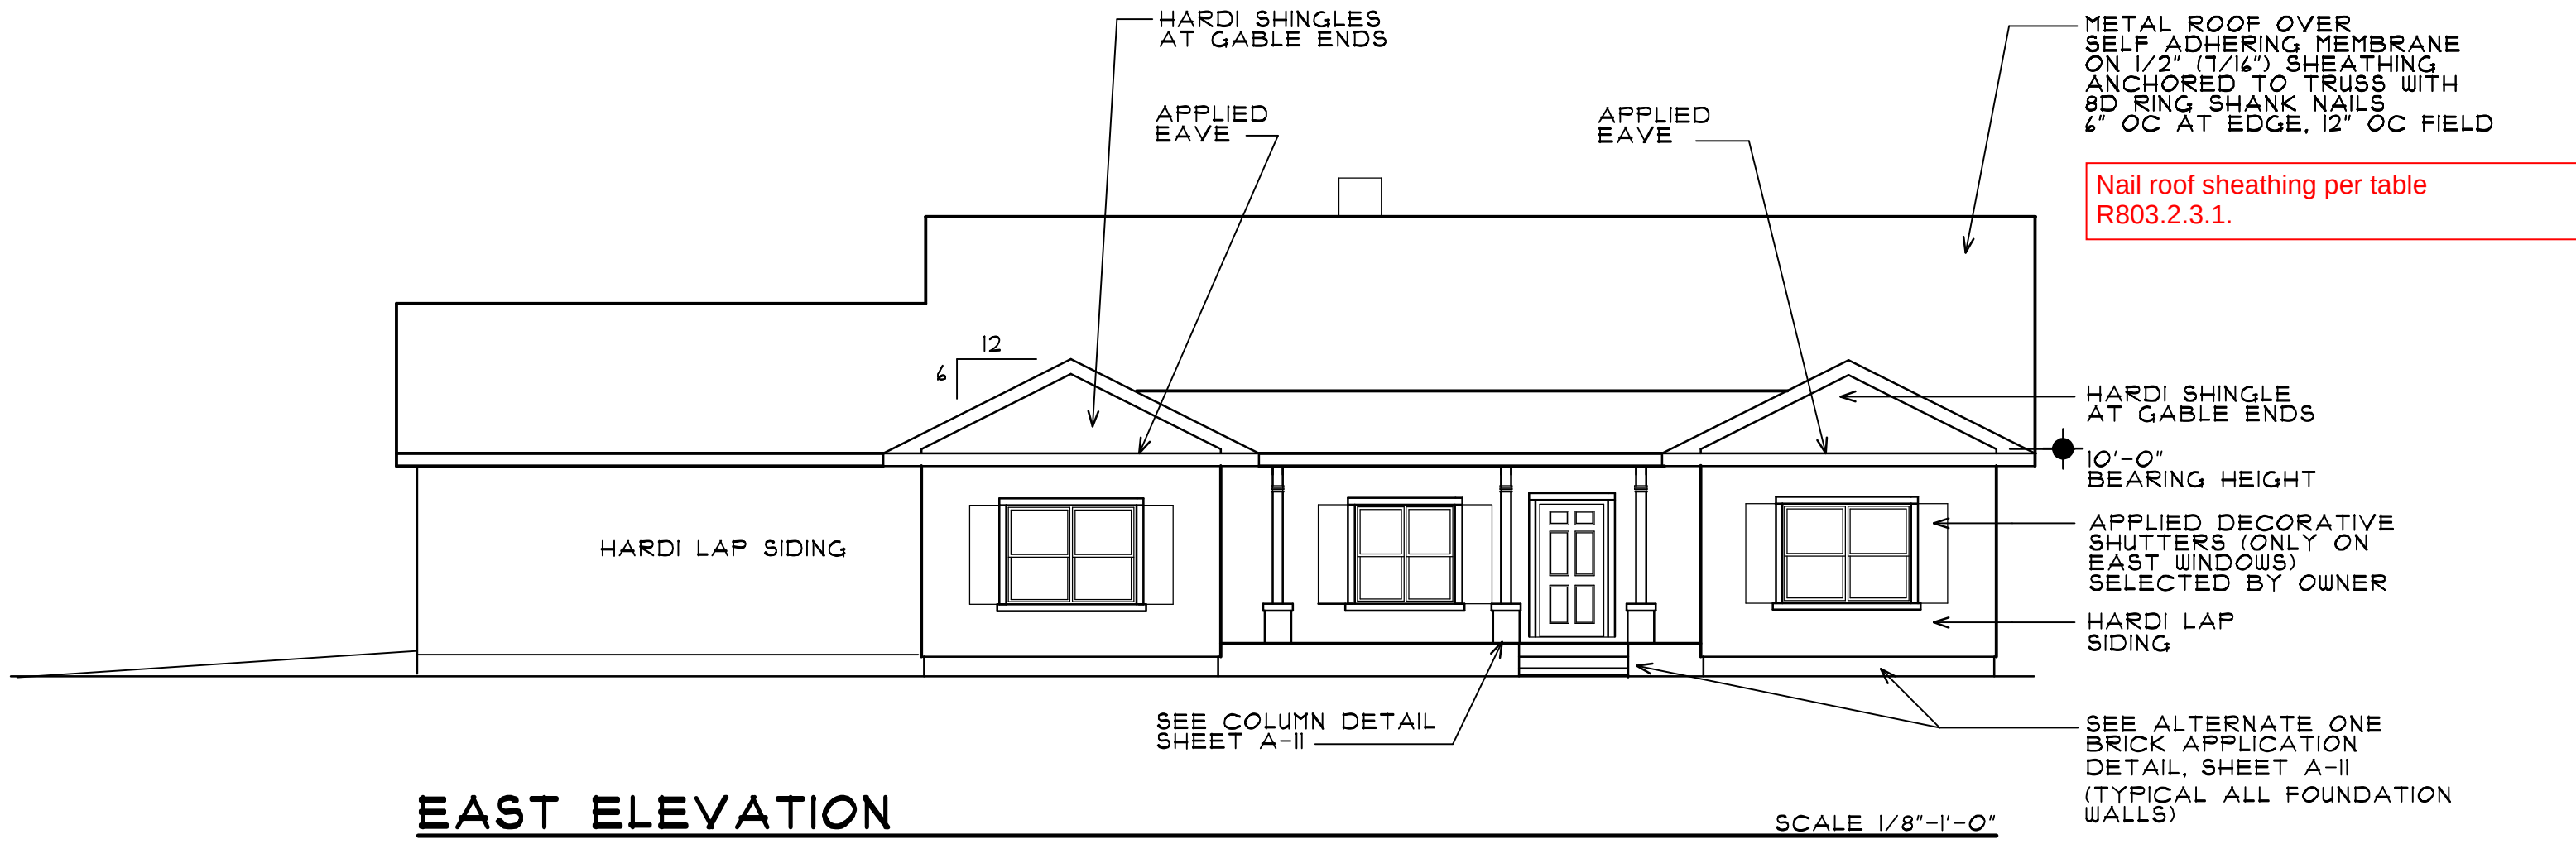

 Review for Code Compliance
Universal Engineering Science
Lawrence Pennell PX2707 01/17/2025
Examiner-License No.

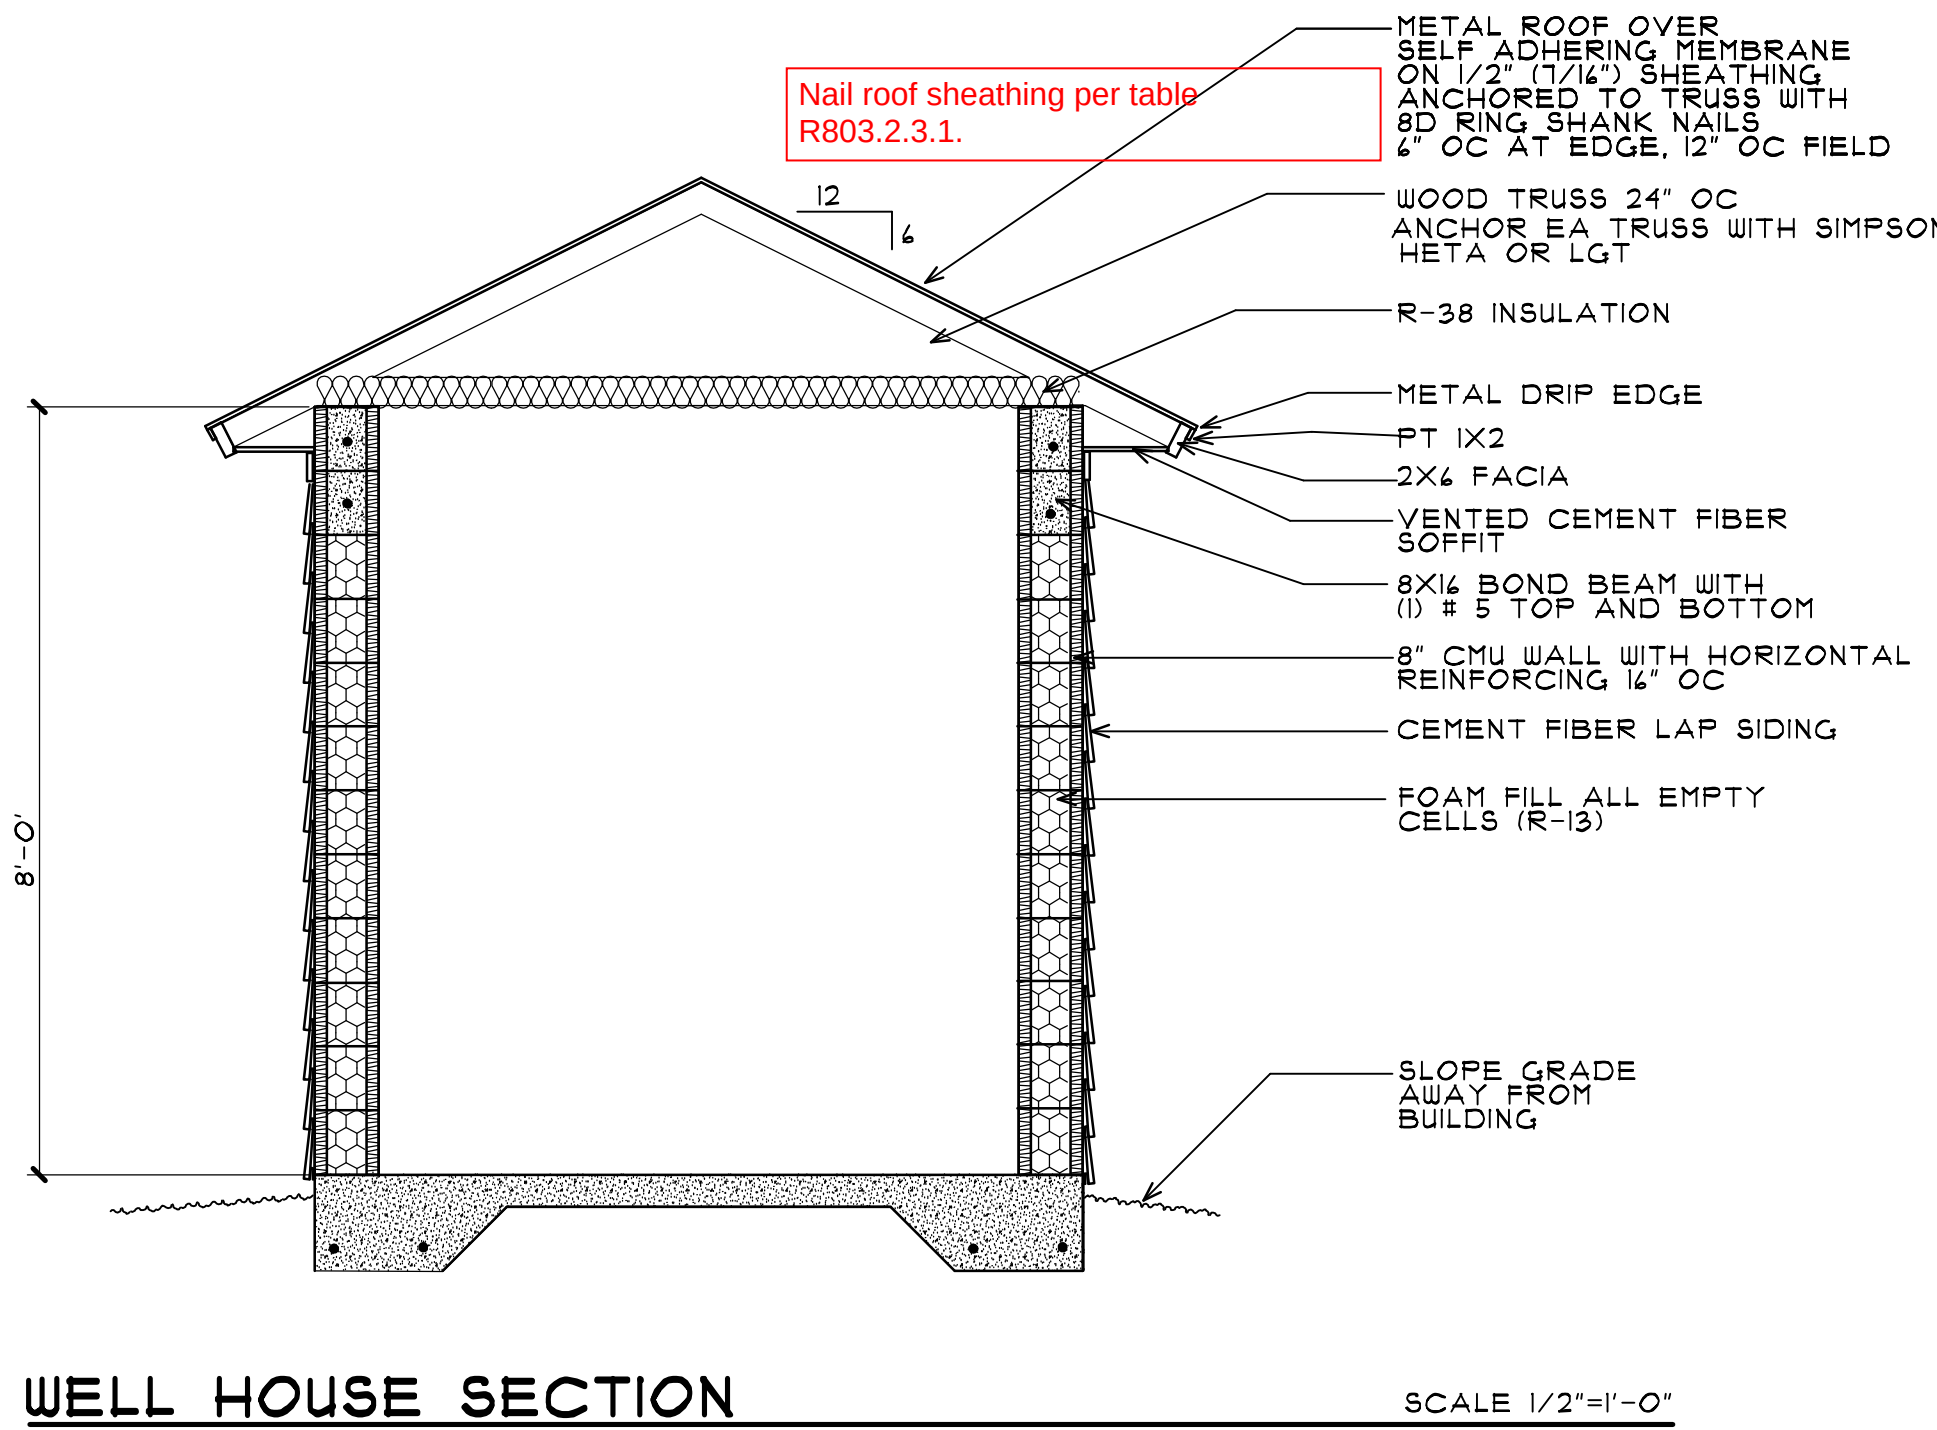

WELL HOUSE EXTERIOR ELEVATIONS

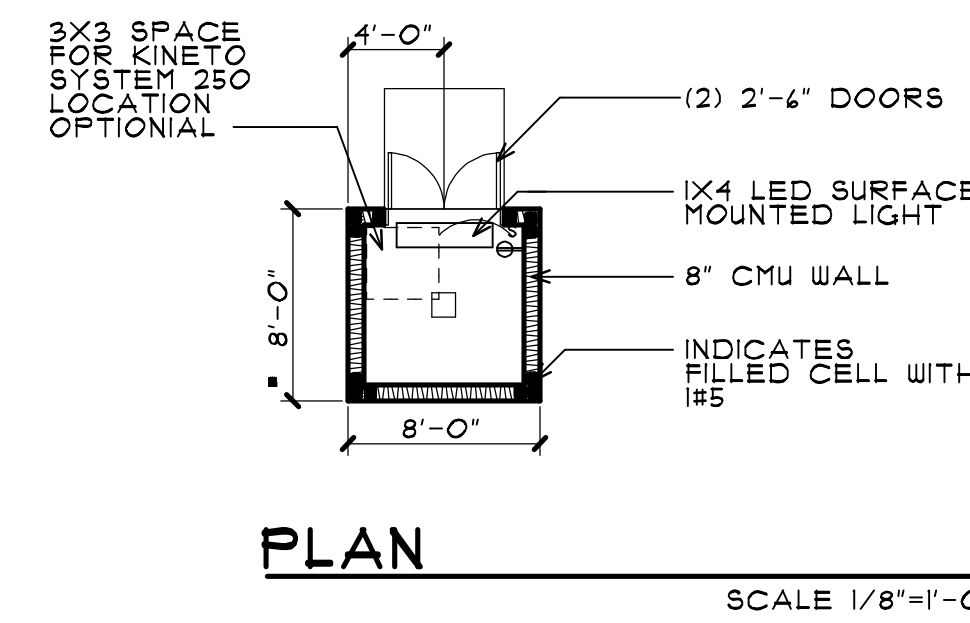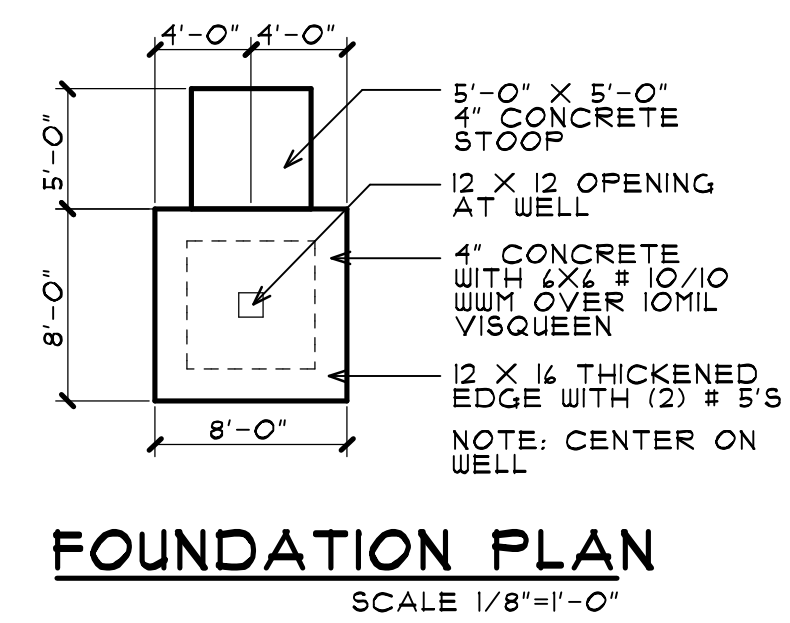

the
rickman
partnership
inc
architecture and interior design
4328 NORTHWEST 29 TERRACE
GAINESVILLE, FL 32605
rickmanpartnership@att.net
(352) 339-1834
FLORIDA LICENSE-AAC00126
FLORIDA LICENSE-IB0000891







RESIDENCE
FOR
KIM McCONNELL
AND
DANIEL McCONNELL

18818 SOUTH US HIGHWAY 441
HIGH SPRINGS, FL 32643

DATE	DESCRIPTION

CONSTRUCTION DOCUMENTS

PROJECT NO. 2405
DATE: 11 OCTOBER 2024
SHEET:
A-09
OF: ELEVEN

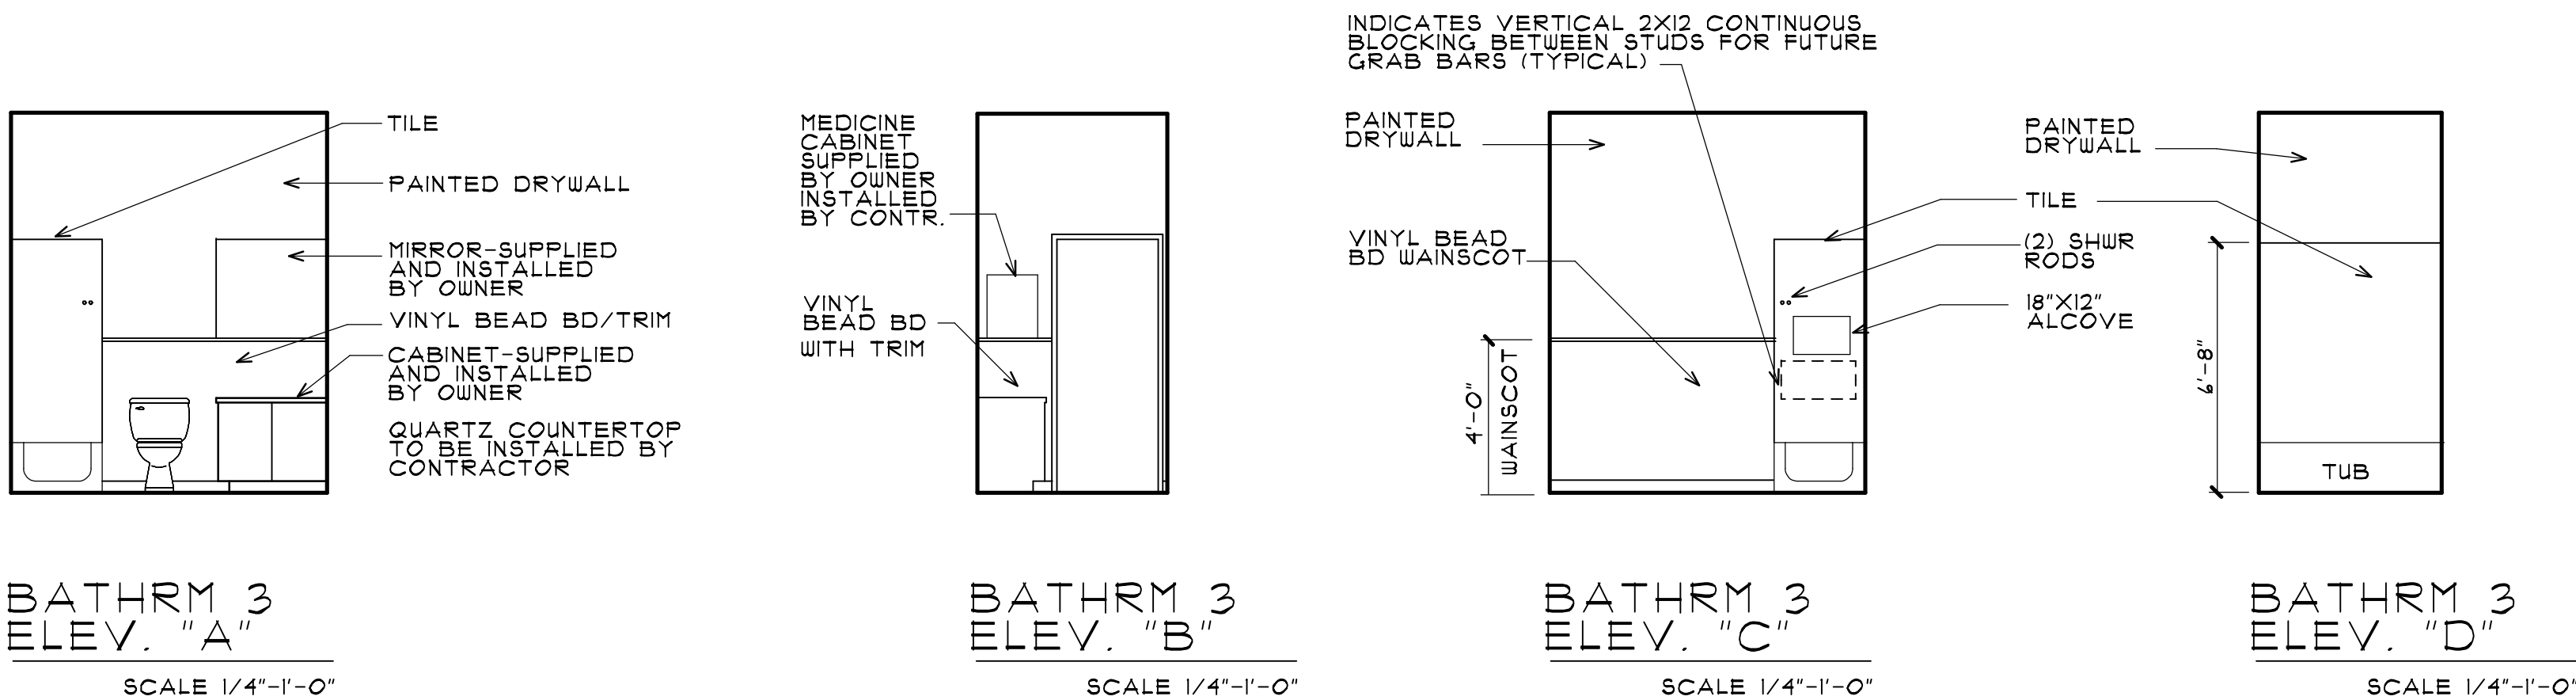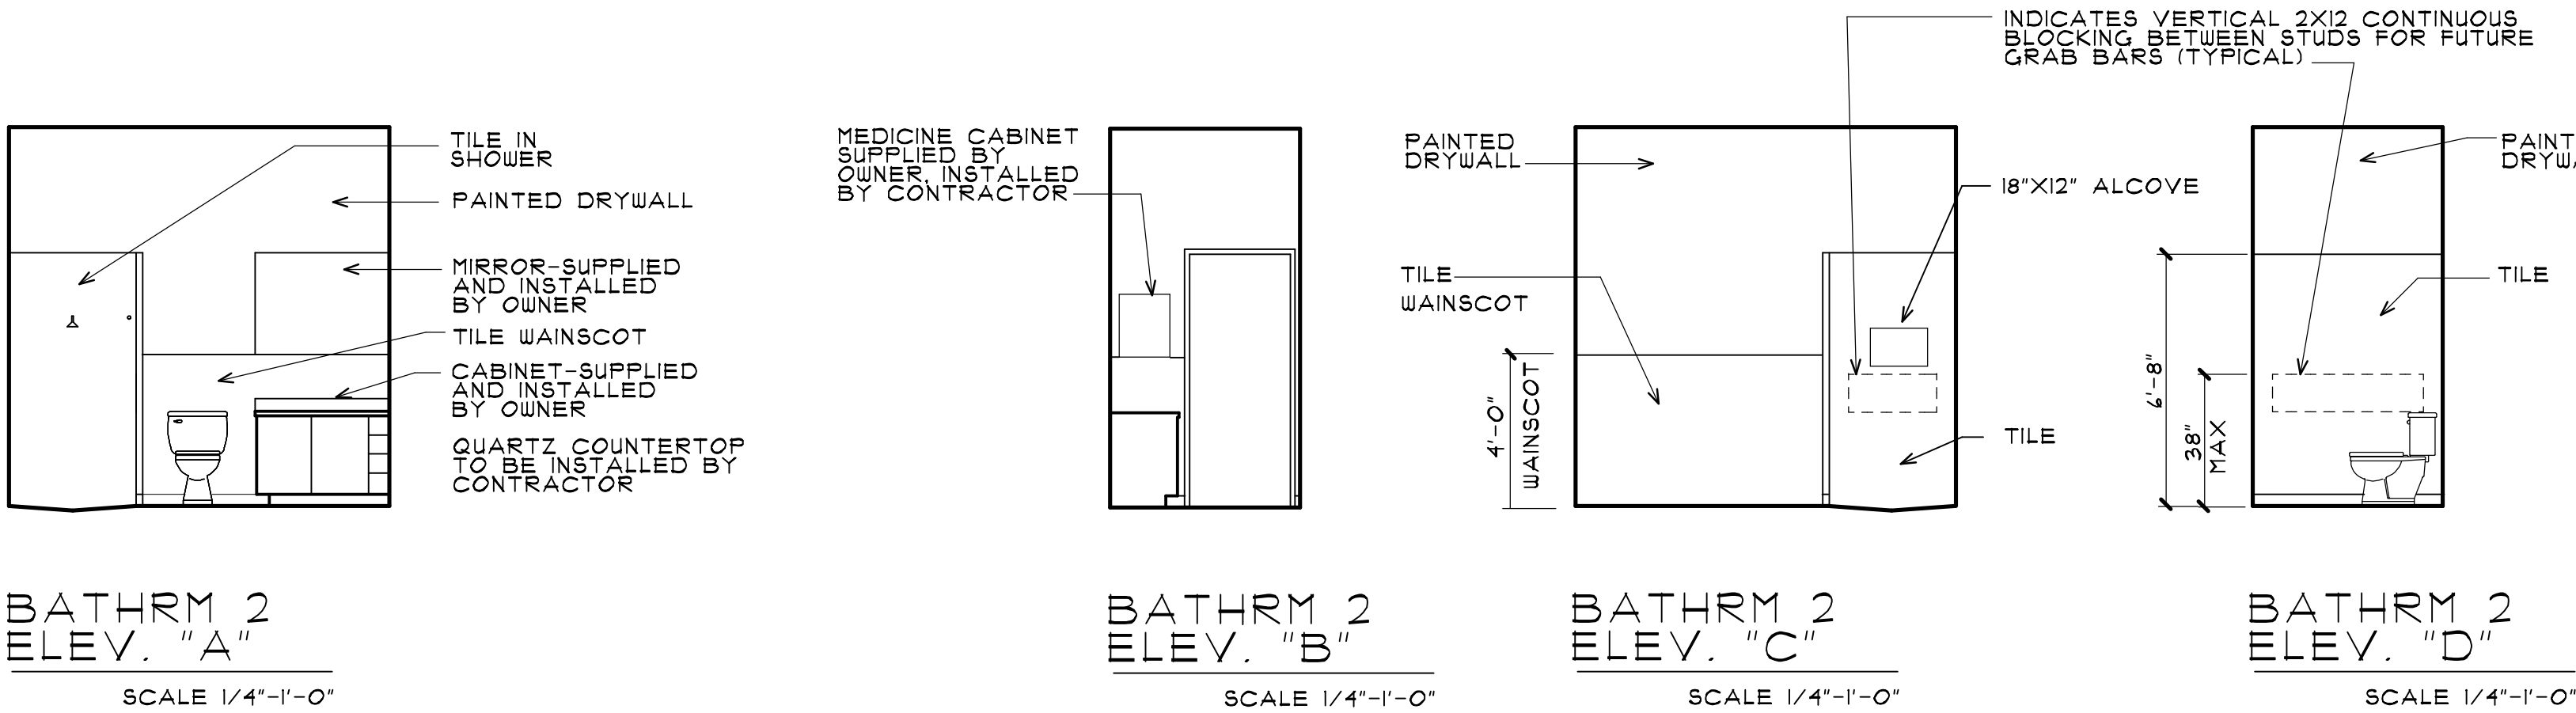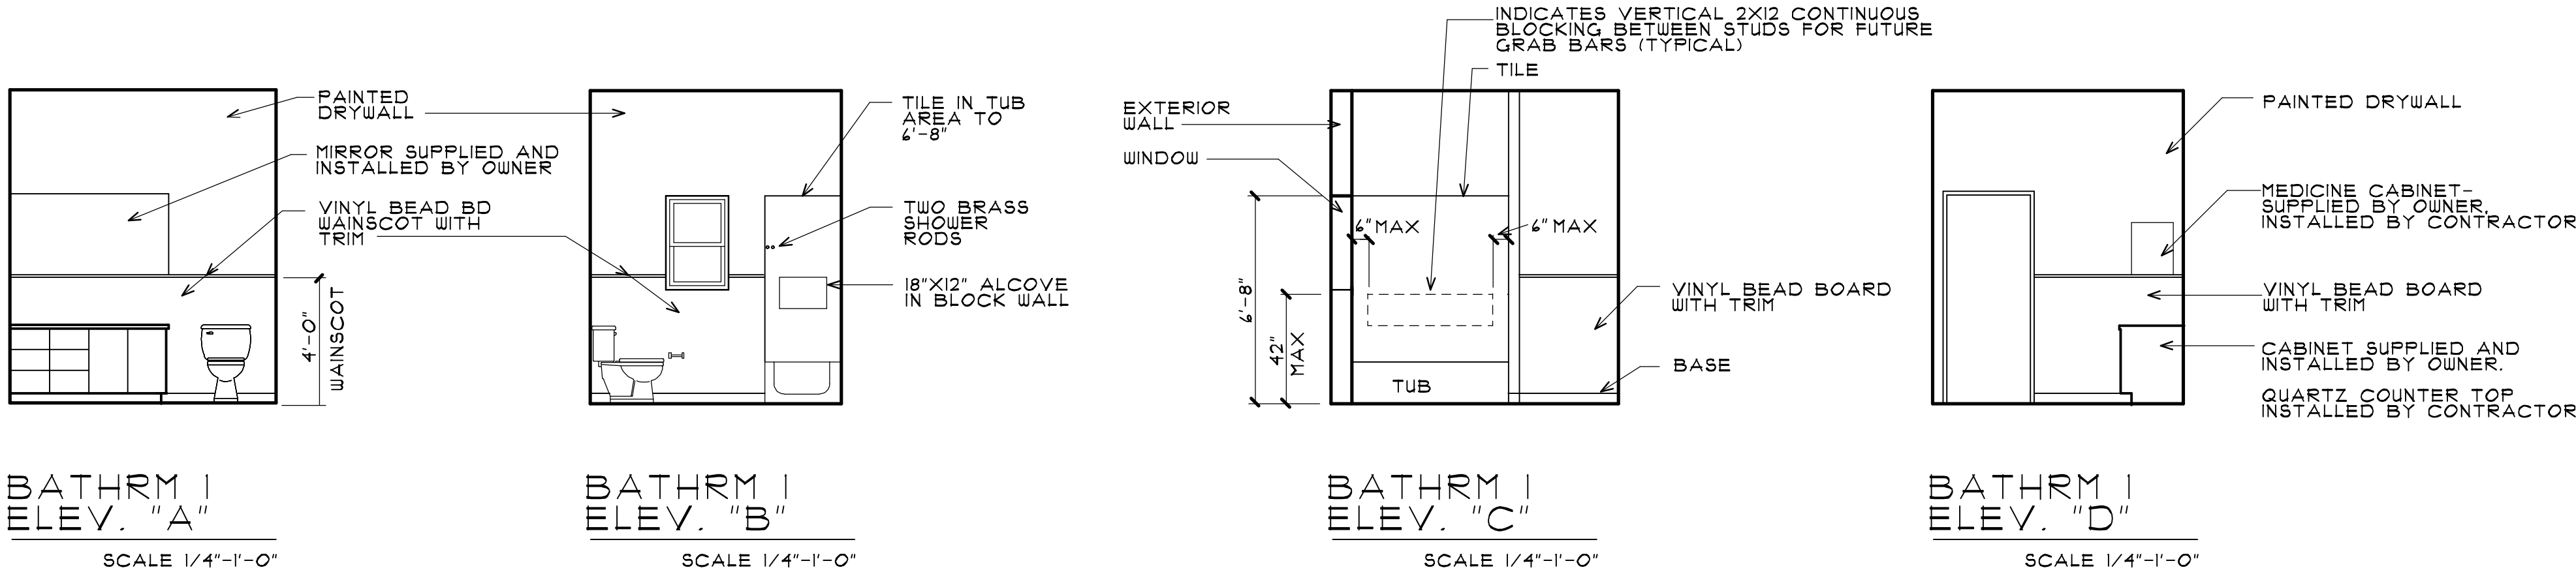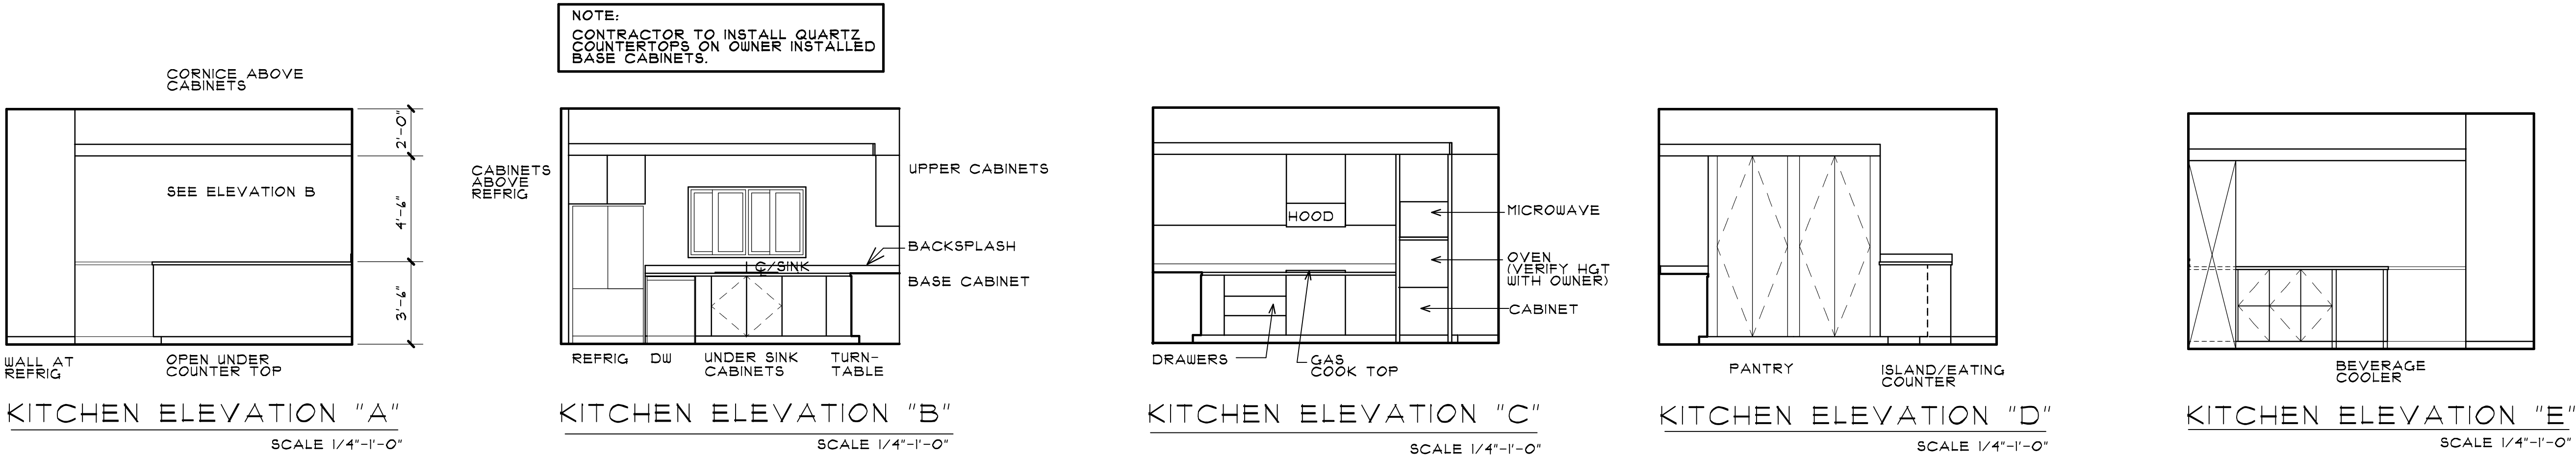

 Review for Code Compliance
Universal Engineering Science
Lawrence Parnell PX2707 01/17/2025
Examiner-License No.

BATHROOM ACCESSORIES			
ALL BATHROOMS TO HAVE: (2) TOWEL BARS (1) TOILET PAPER HOLDER (2) SHOWER RODS (BATHROOM 1 AND 3) (1) SHOWER ROD (BATHROOM 2) (1) MEDICINE CABINET (1) SOAP DISH ACCESSORIES TO BE SUPPLIED AS A PACKAGE THROUGH McCONNELLPROJECT@BUILD.COM (CONTACT PERSON: MALLORY NORTON)			
KITCHEN APPLIANCE LEGEND			
APPLIANCES SELECTED BY OWNER (CUSTOMER #3524439814) AT LOWE'S (ALACHUA/STORE #2984) CONTACT: ZACH JONES, SALES SPECIALIST			
MARK	APPLIANCE	MANUFACTURER	REMARKS
A	REFRIGERATOR	BOSCH MODEL B36CT8IENS COUNTER-DEPTH FINISH: STAINLESS STEEL	ICE MAKER AND ICE DISPENSER
B	BEVERAGE COOLER	HISENSE #HBC54D6A5 5.4 CU FT	SINGLE GLASS DOOR
C	SINGLE WALL OVEN	BOSCH MODEL HBL535IUC FINISH: STAINLESS STEEL OVEN CAPACITY 4.1 CU FT	30" NOMINAL WIDTH
D	BUILT-IN MICROWAVE OVEN	BOSCH MODEL HMB50I52UC FINISH: STAINLESS STEEL	30" NOMINAL WIDTH
E	DISHWASHER	BOSCH 800 SERIES	
F	RANGE HOOD	MAO CAO HOOM #BH-AE94W UNDER CABINET	30 INCH HEIGHT: 11.4 INCHES DEPTH: 11.5 INCHES
G	GAS COOKTOP	BOSCH 800 SERIES #NGM8059UC	5 BURNERS (PROVIDE PROPANE)

the
rickman
partnership
inc
architecture and interior design
4328 NORTHWEST 29 TERRACE
GAINESVILLE, FL 32605
rickmanpartnership@att.net
(352) 339-1834
FLORIDA LICENSE-AAC00126
FLORIDA LICENSE-IB0000891



RESIDENCE
FOR
KIM McCONNELL
AND
DANIEL McCONNELL

18818 SOUTH US HIGHWAY 441
HIGH SPRINGS, FL 32643

DATE	DESCRIPTION

PROJECT NO. 2405

DATE: 11 OCTOBER 2024

SHEET:

A-10

OF: ELEVEN




RESIDENCE
FOR

KIM McCONNELL
AND
DANIEL McCONNELL


18818 SOUTH US HIGHWAY 441
HIGH SPRINGS, FL 32643

DATE	DESCRIPTION


CONSTRUCTION DOCUMENTS

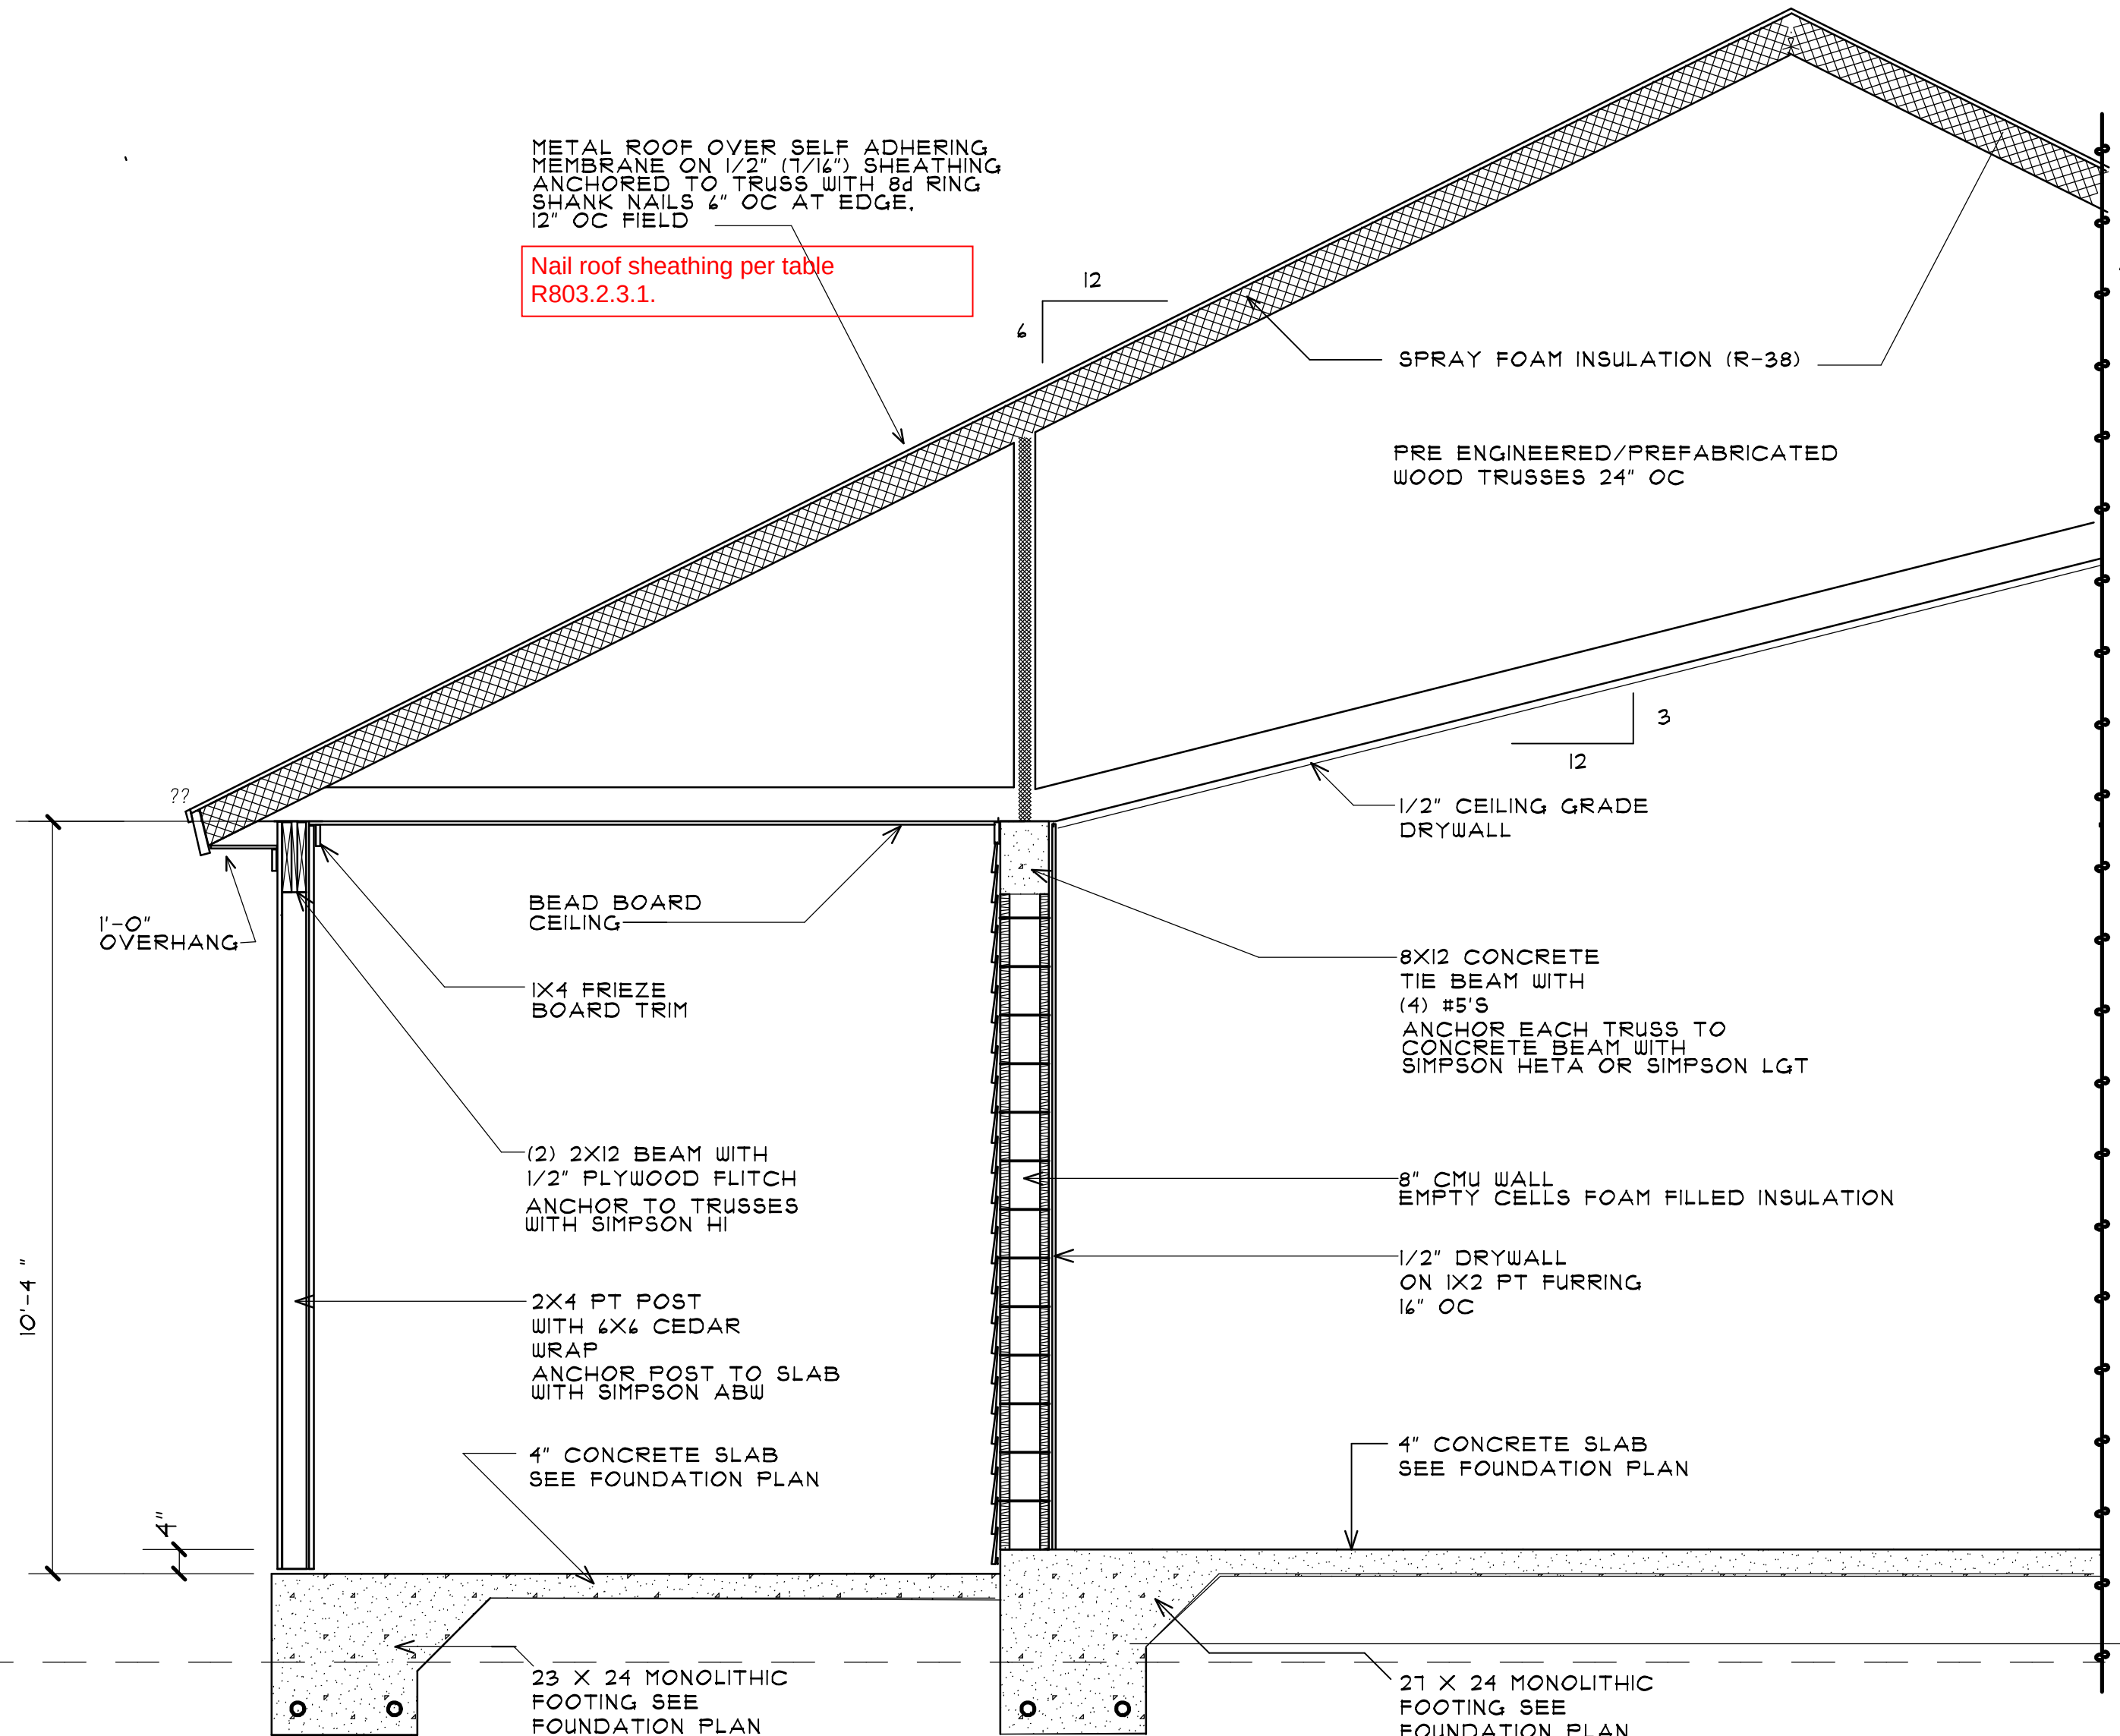


A SECTION THRU WEST SCREENED PORCH SCALE 1/2" = 1'-0"

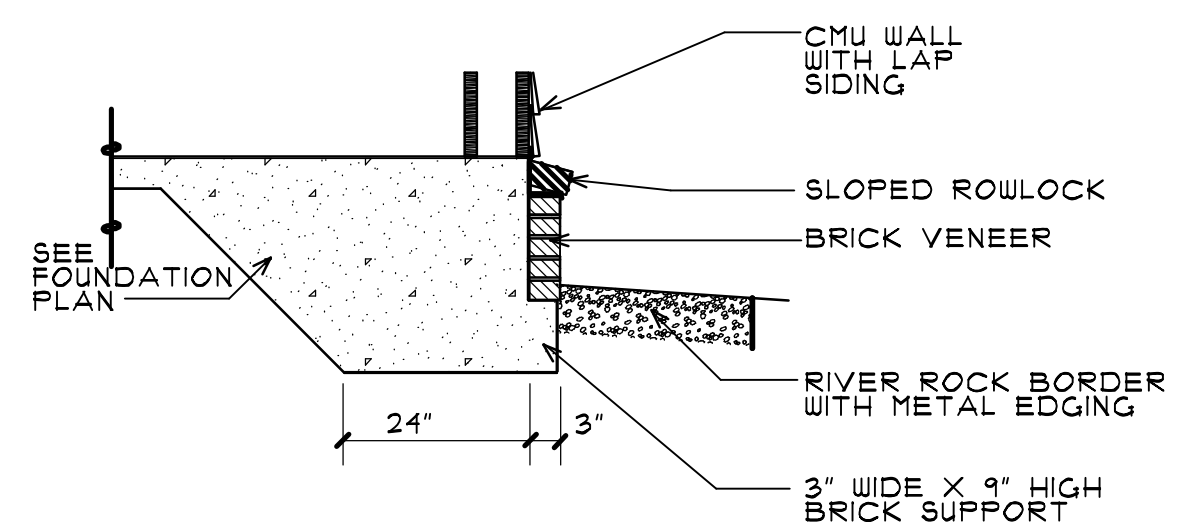

ALTERNATE ONE FOUNDATION WITH BRICK VENEER SCALE 1/2" = 1'-0"

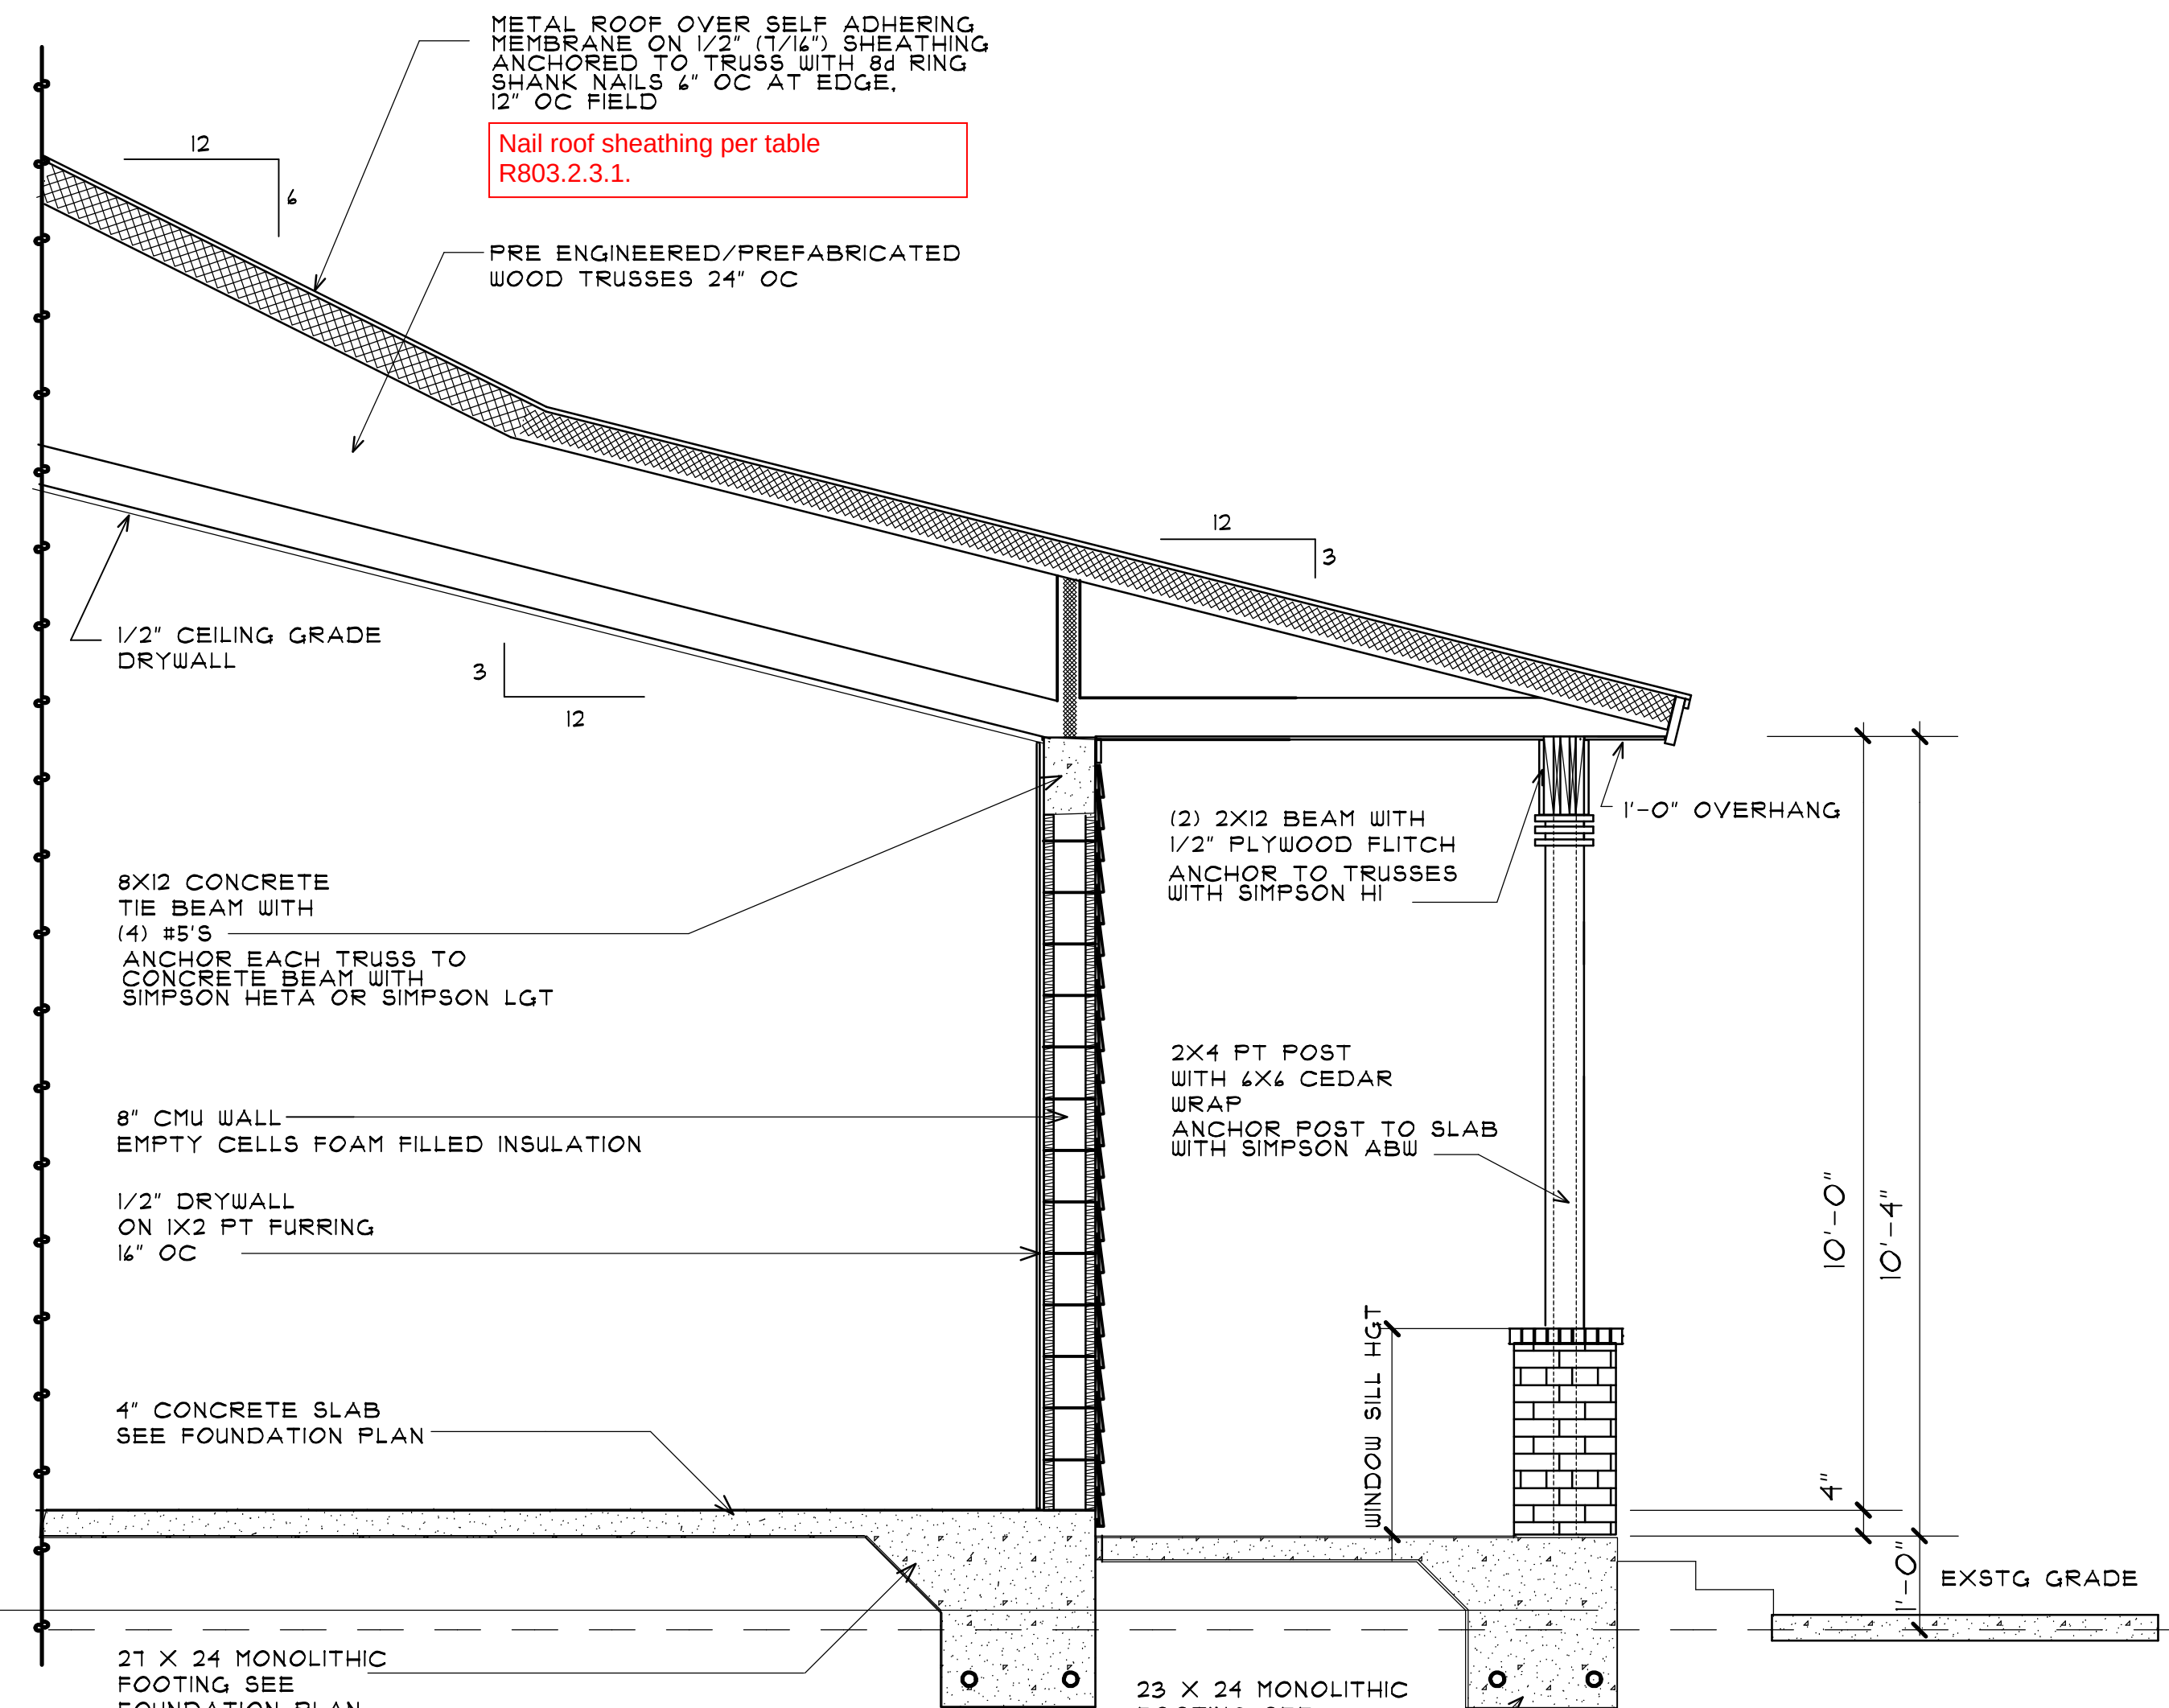

B SECTION THRU EAST PORCH SCALE 1/2" = 1'-0"

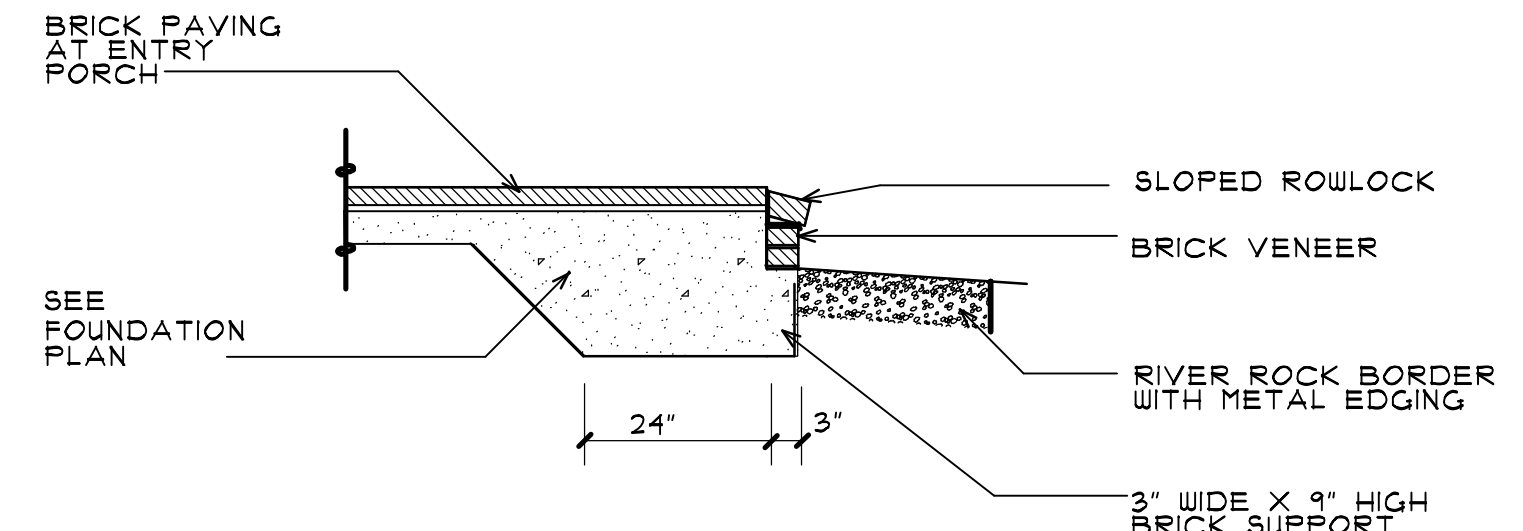

ALTERNATE ONE FRONT PORCH WITH BRICK VENEER AND PAVING SCALE 1/2" = 1'-0"