




- DESIGN CODES:
2020 FLORIDA BUILDING CODE (FBC)
ASCE 7-10, 2005
NDS, ACI, ATIC, AWPA, APA, ICC 600-08
- OCCUPANCY: COMMERCIAL
- NUMBER OF STORIES: 2
- TYPE OF CONSTRUCTION: TYPE I B, UNSPRINKLERED

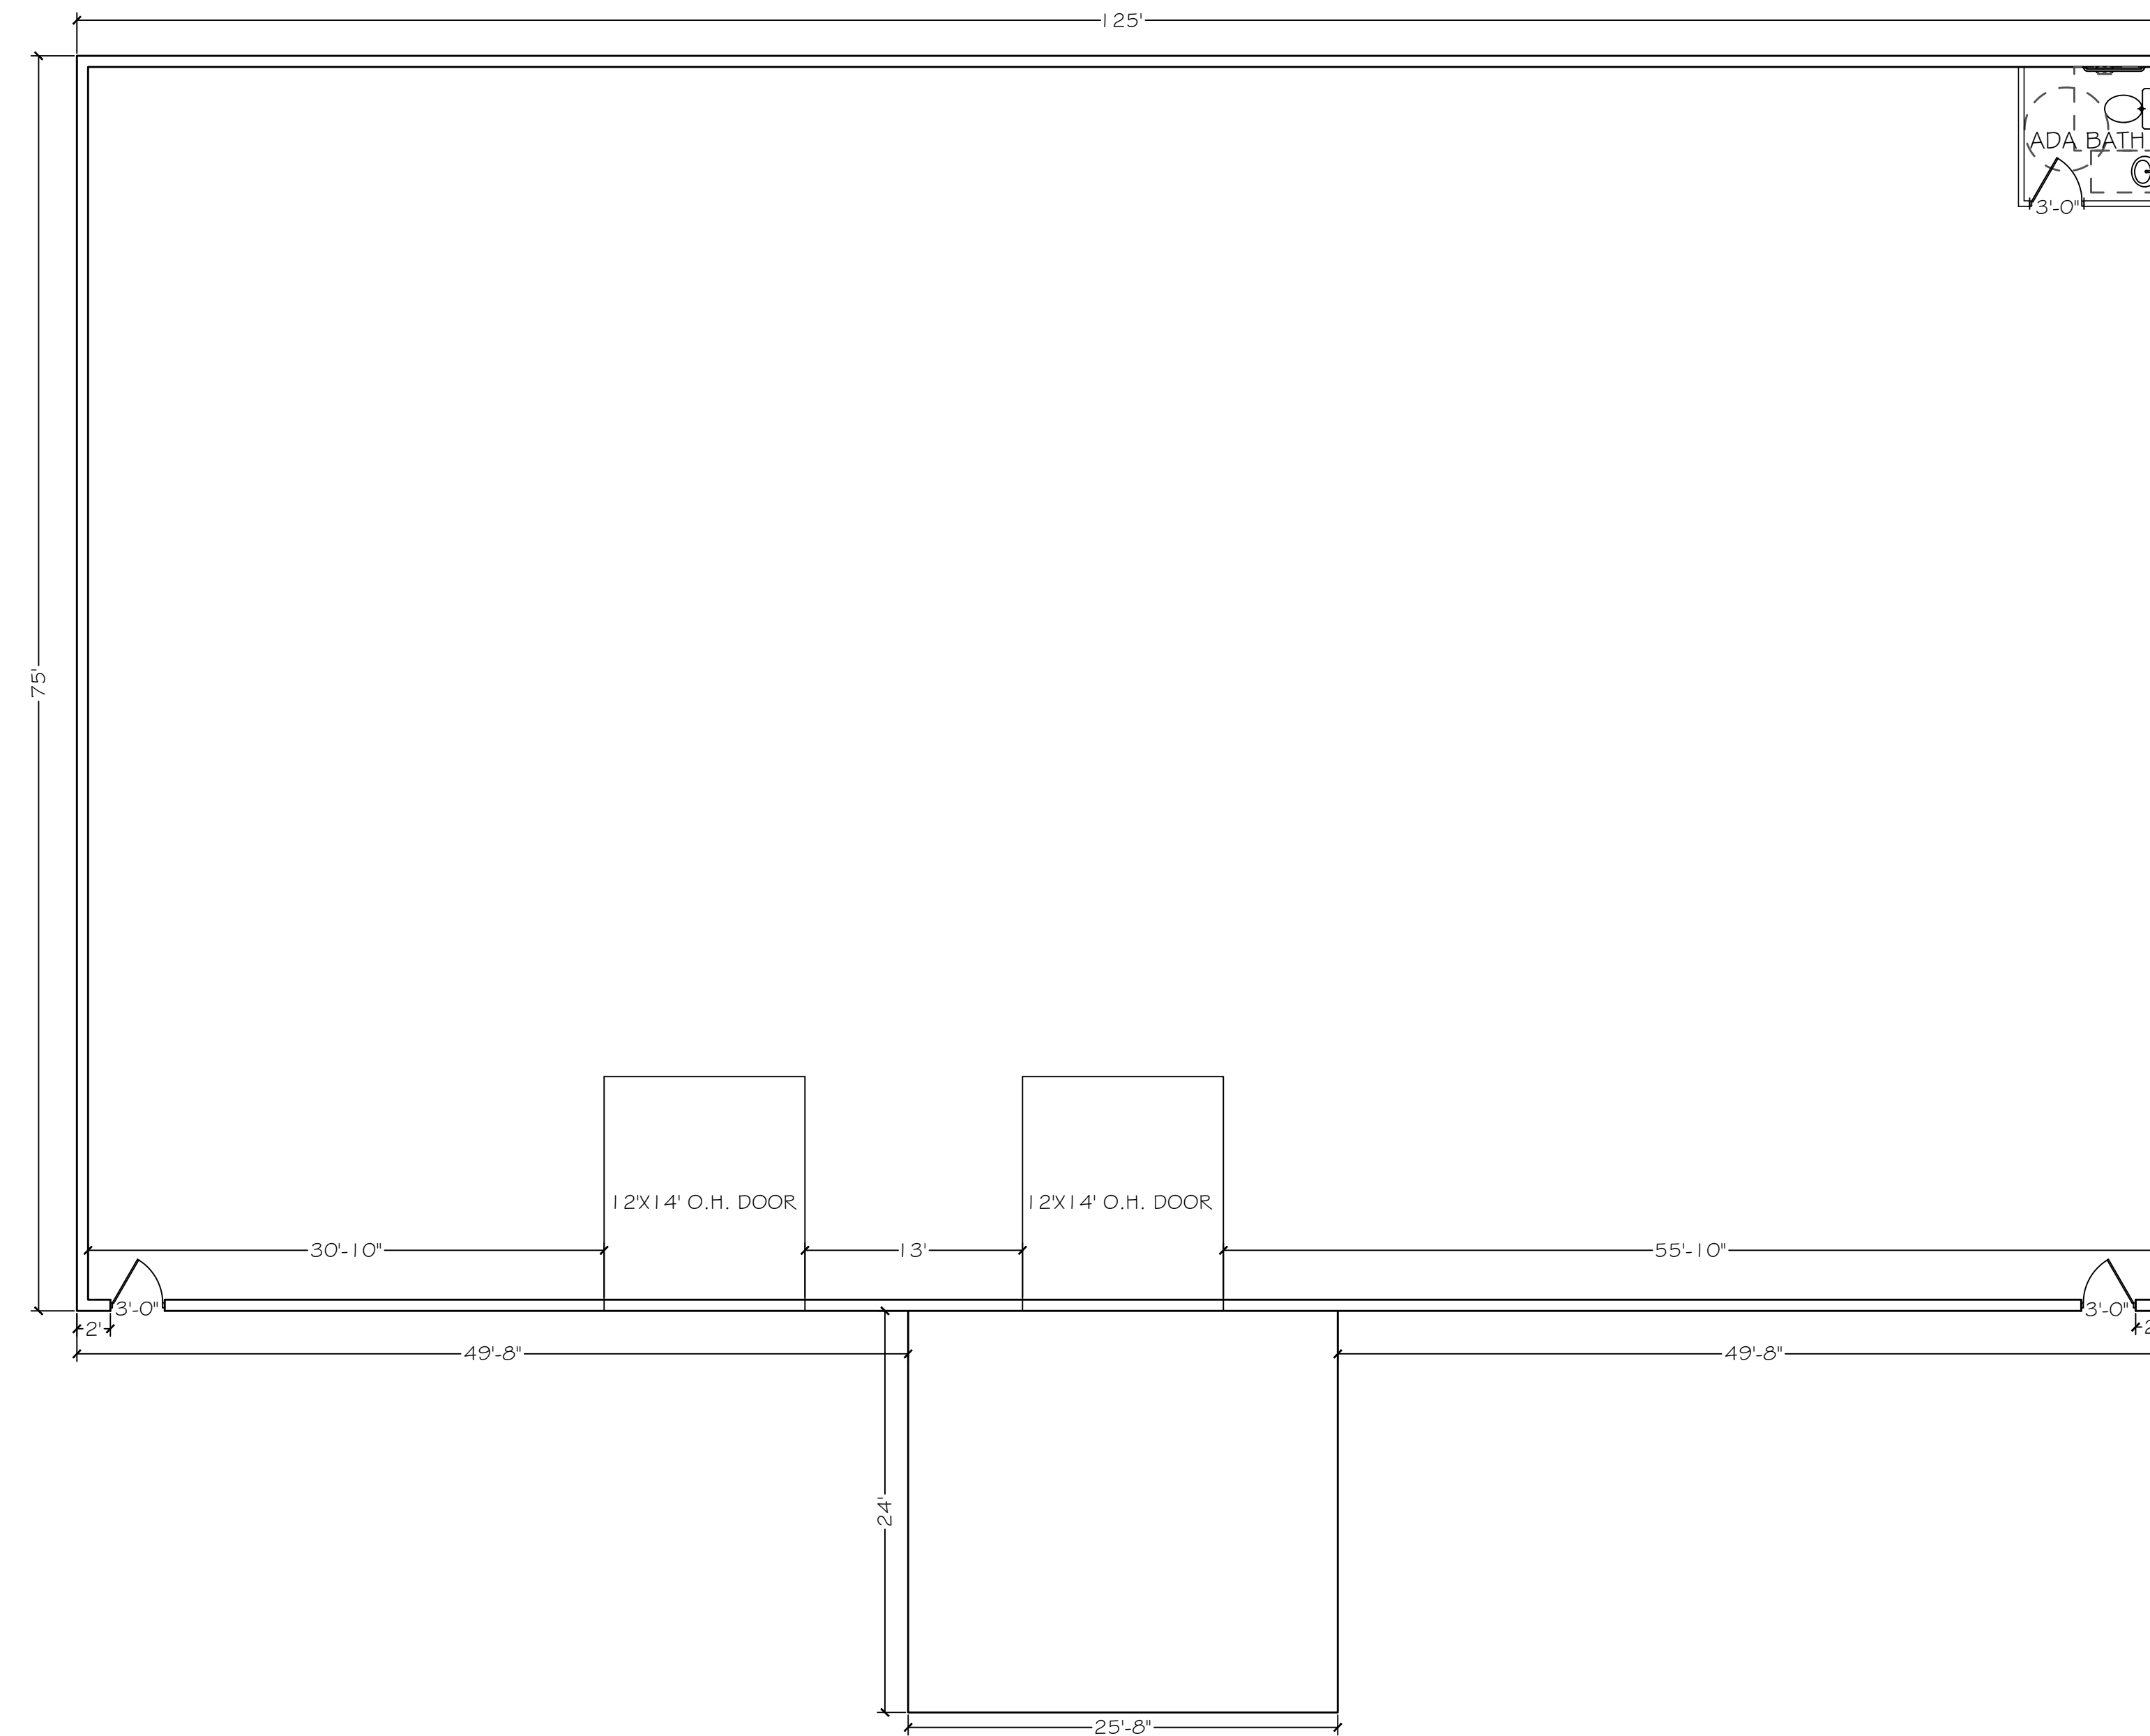


FLOOR PLAN
SCALE: 1/8" = 1'

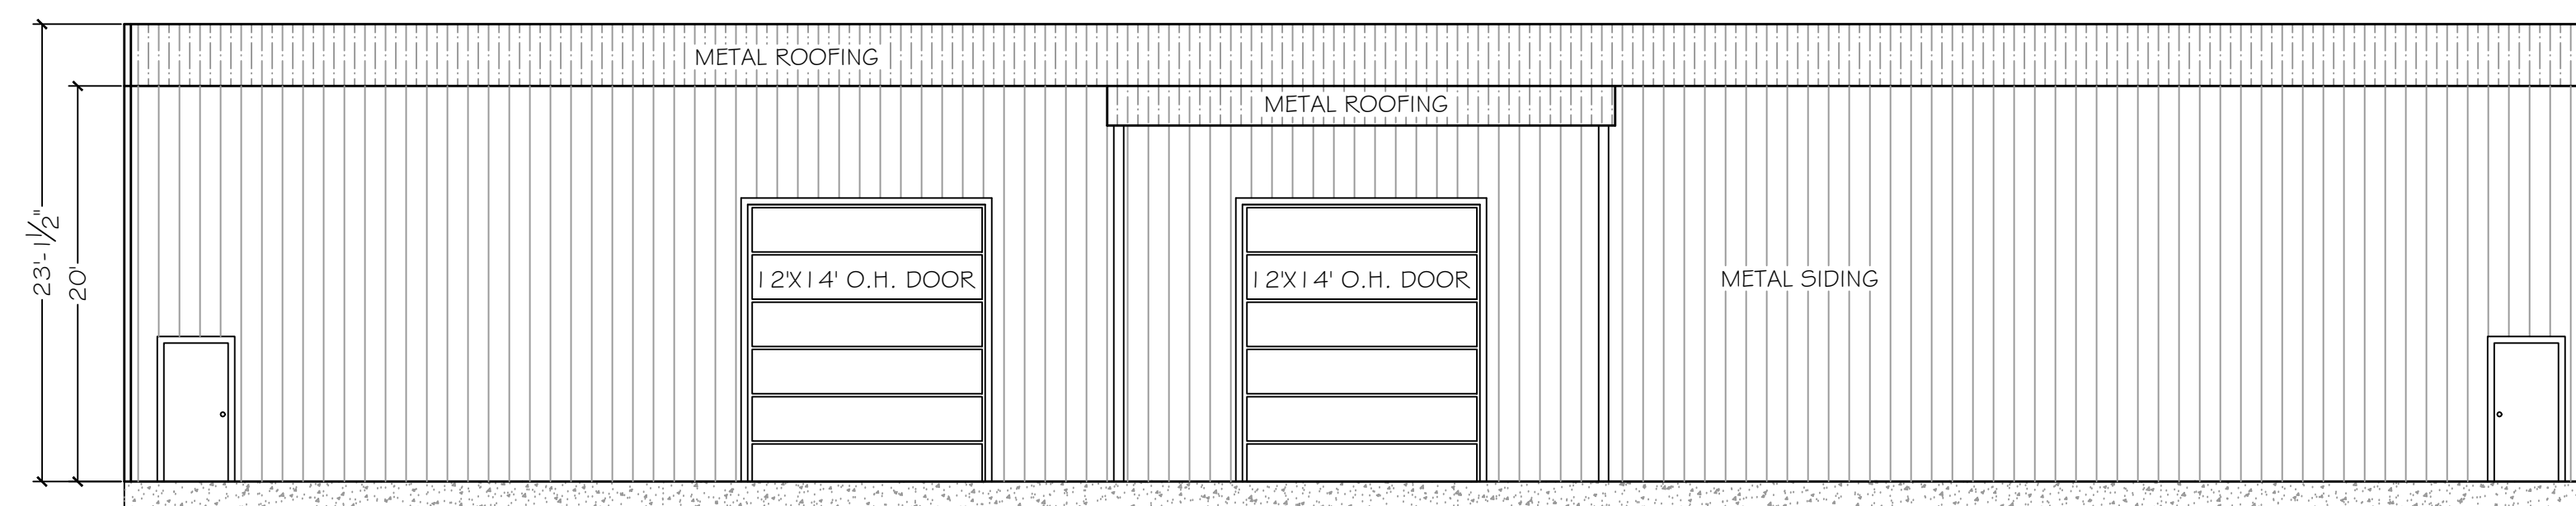


FRONT ELEVATION
SCALE: 1/8" = 1'

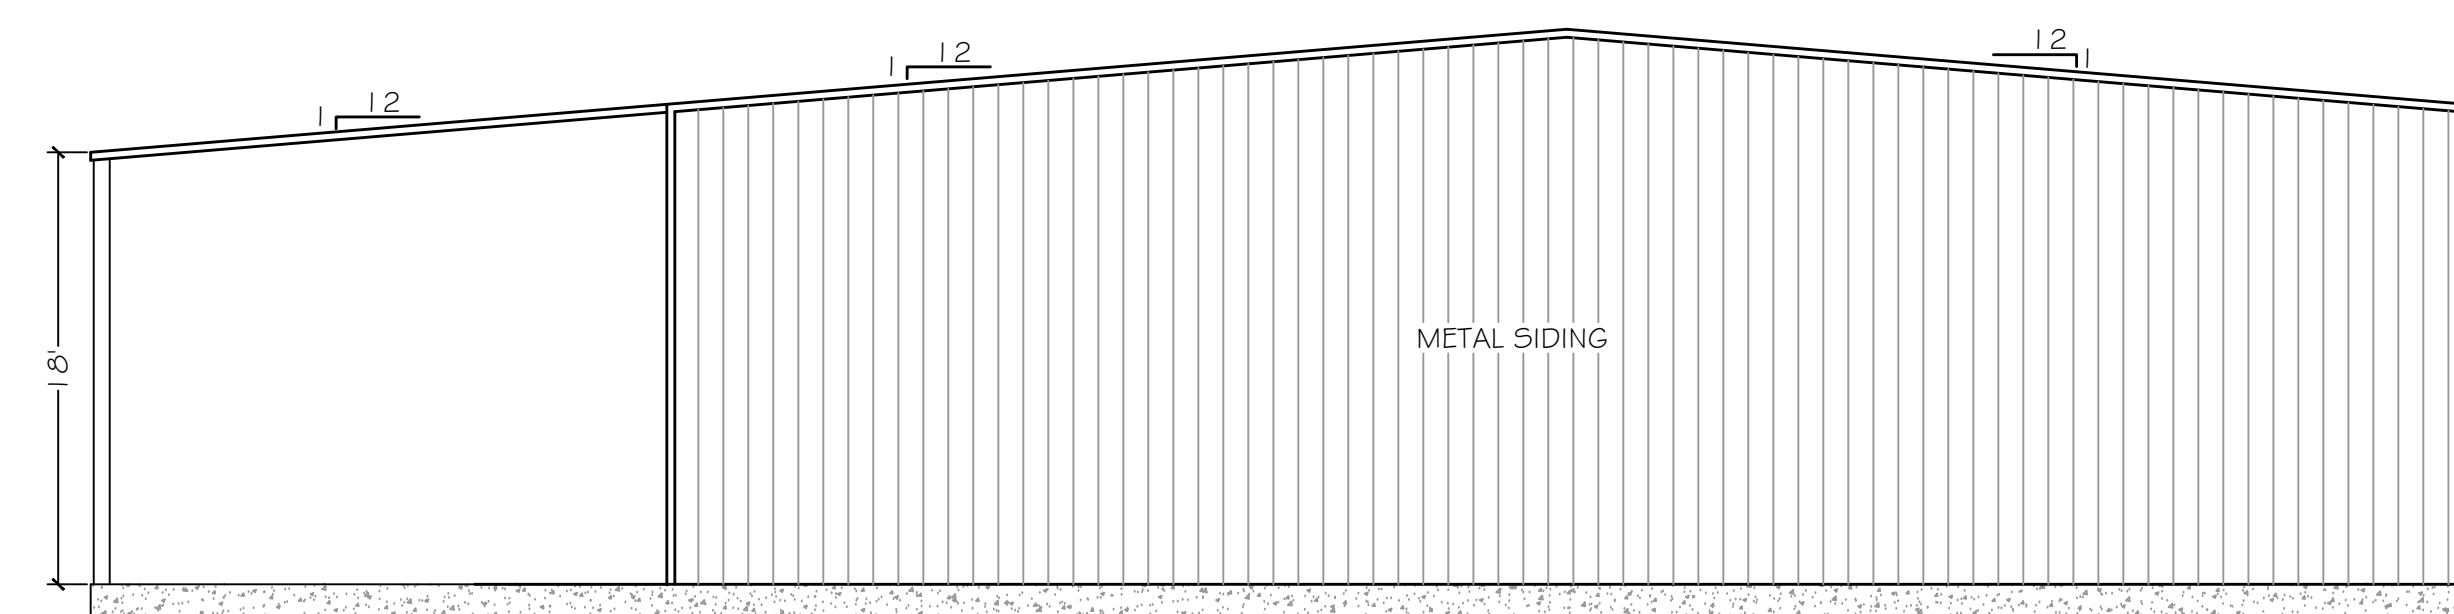

RIGHT ELEVATION
SCALE: 1/8" = 1'

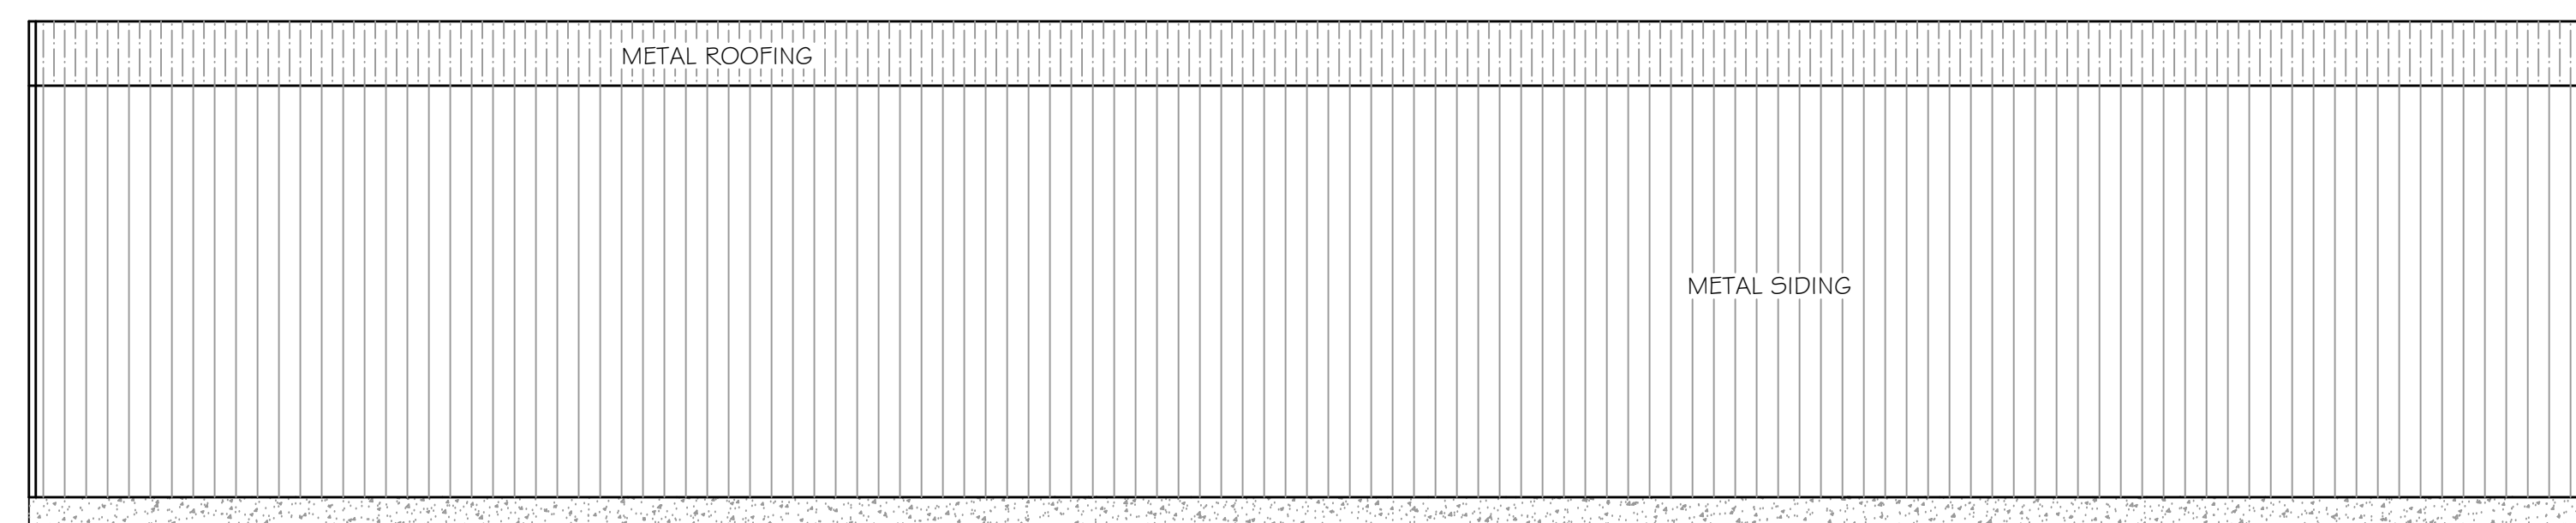

REAR ELEVATION
SCALE: 1/8" = 1'

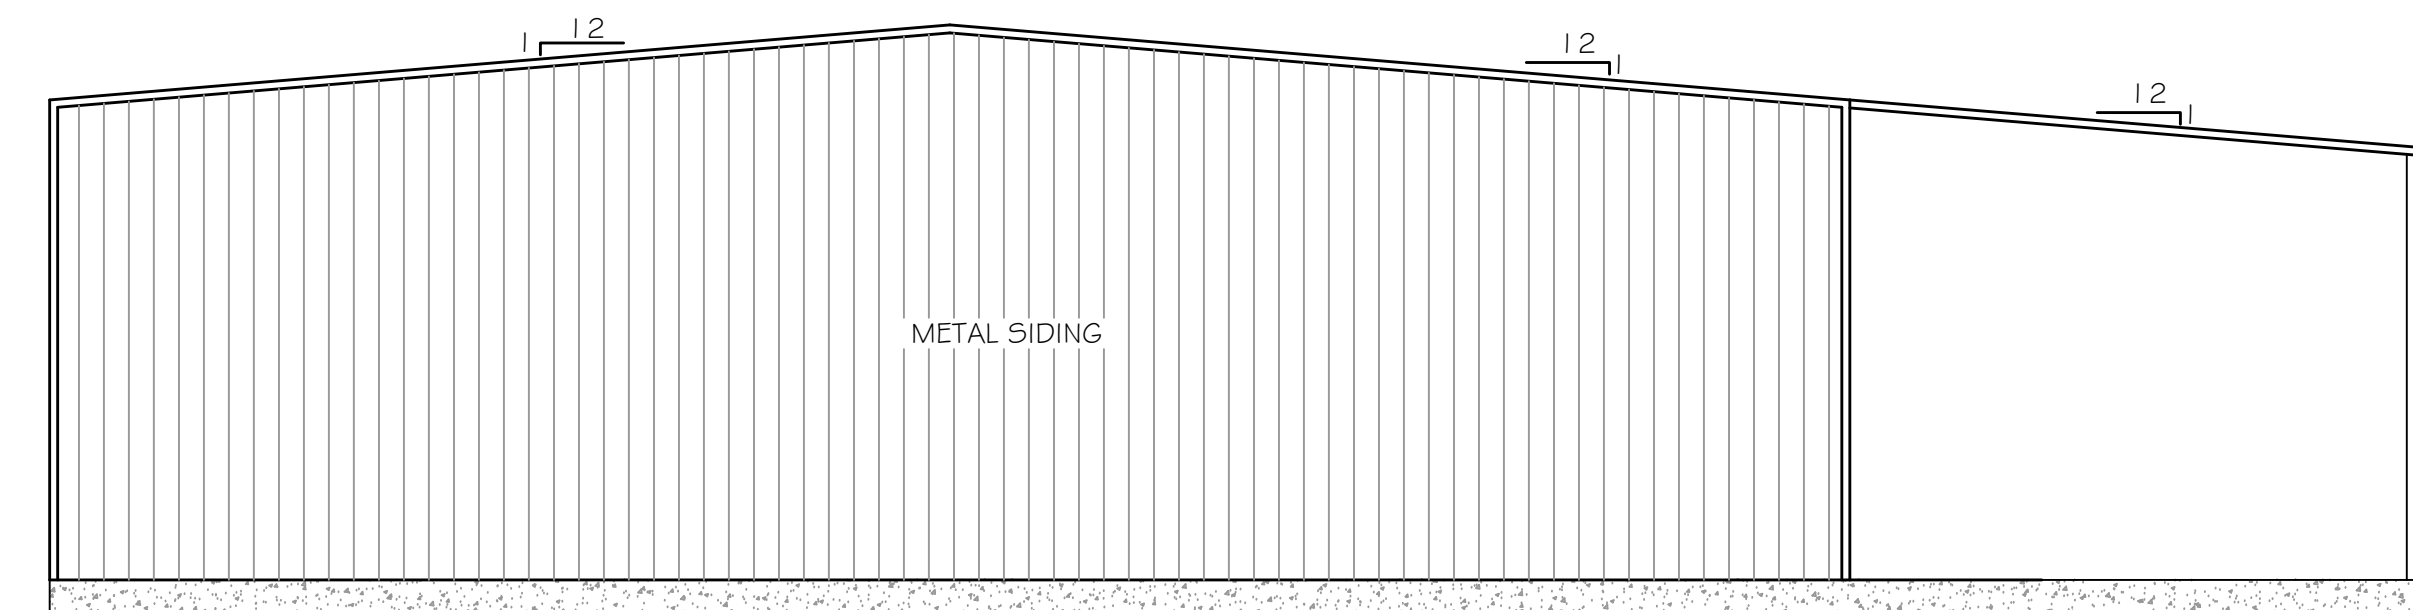


LEFT ELEVATION
SCALE: 1/8" = 1'

ALL ELECTRICAL TO BE INSTALLED PER CURRENT NEC CODE

1. PROVIDE INTERIOR SWITCH AND EXTERIOR LIGHT IN THE VICINITY OF ALL EXTERIOR DOORS.
2. PROVIDE AN OUTSIDE GFI, WATER PROTECTED RECEPTACLE NEAR EGRESS DOORS.
3. BATHROOM RECEPTACLES TO BE GFI WITH A SEPARATE 20 AMP CIRCUIT.
4. PROVIDE SMOKE DETECTOR PER BUILDING CODE.
5. ALL BRANCH CIRCUITS THAT SUPPLY 125 VOLT, SINGLE PHASE, 15 AND 20 AMP OUTLETS INSTALLED IN DWELLING UNIT SHALL BE PROTECTED BY AN ARC-FAULT CIRCUIT INTERRUPTER LISTED TO PROVIDE PROTECTION OF THE ENTIRE BRANCH CIRCUIT.
6. FLUORESCENT GENERAL LIGHTING IN BATH IS REQUIRED TO HAVE A 40 LUMENS PER WATT EFFICIENCY LAMP.
7. RECESSED CEILING FIXTURES MUST BE IC RATED.
8. NOT LESS THAN 75% OF THE LAMPS IN PERMANENTLY INSTALLED LIGHTING FIXTURES SHALL BE HIGH-EFFICIENCY LAMPS OR NOT LESS THAN 75% OF THE PERMANENTLY INSTALLED LIGHTING FIXTURES SHALL CONTAIN ONLY HIGH-EFFICIENCY LAMPS.

	DUPLEX WALL RECEPTACLE
	GFI DUPLEX WALL RECEPTACLE
	SPST WALL SWITCH
	DPDT WALL SWITCH (3 WAY)
	120V SMOKE DETECTOR
	VENT LIGHT COMBO
	SPOTLIGHT DOUBLE
	LIGHTED EXIT SIGN WITH BAT. PACK, GREEN FONT
	DUAL HEAD EM. LIGHT WITH BAT. PACK
	LED HIGH BAY LIGHT

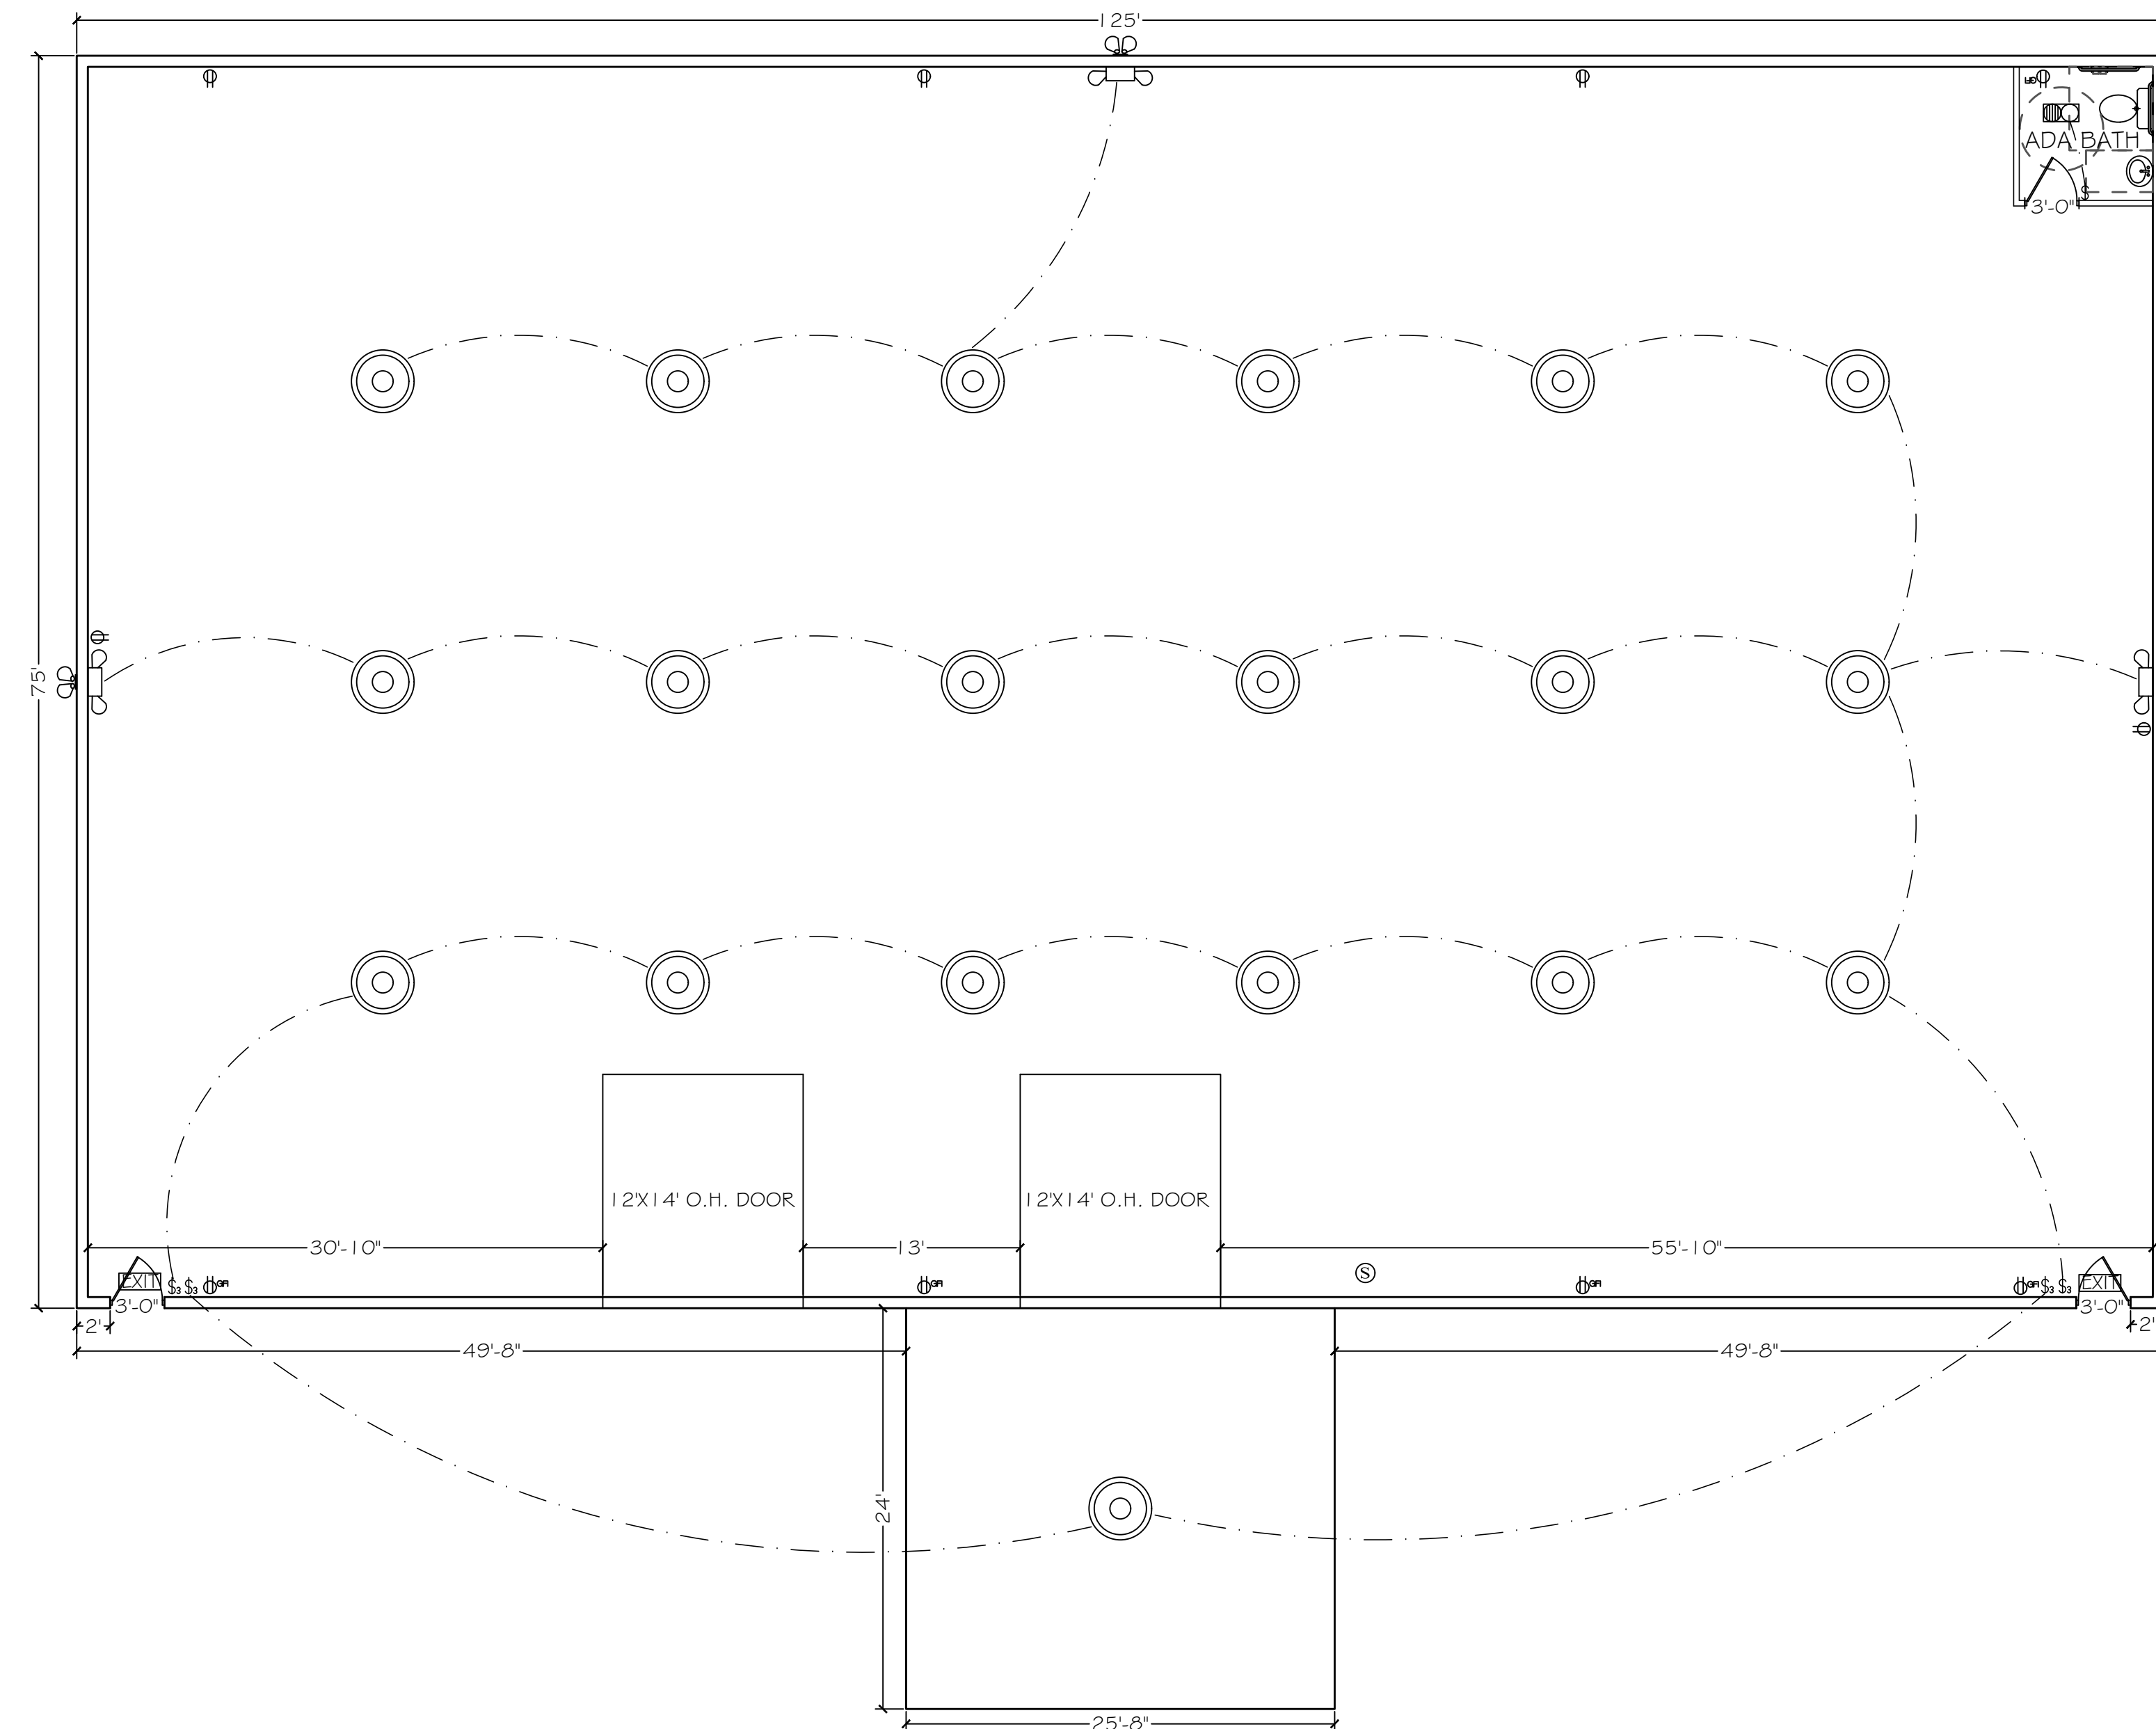

ELECTRIC PLAN
SCALE: 1/8" = 1'