


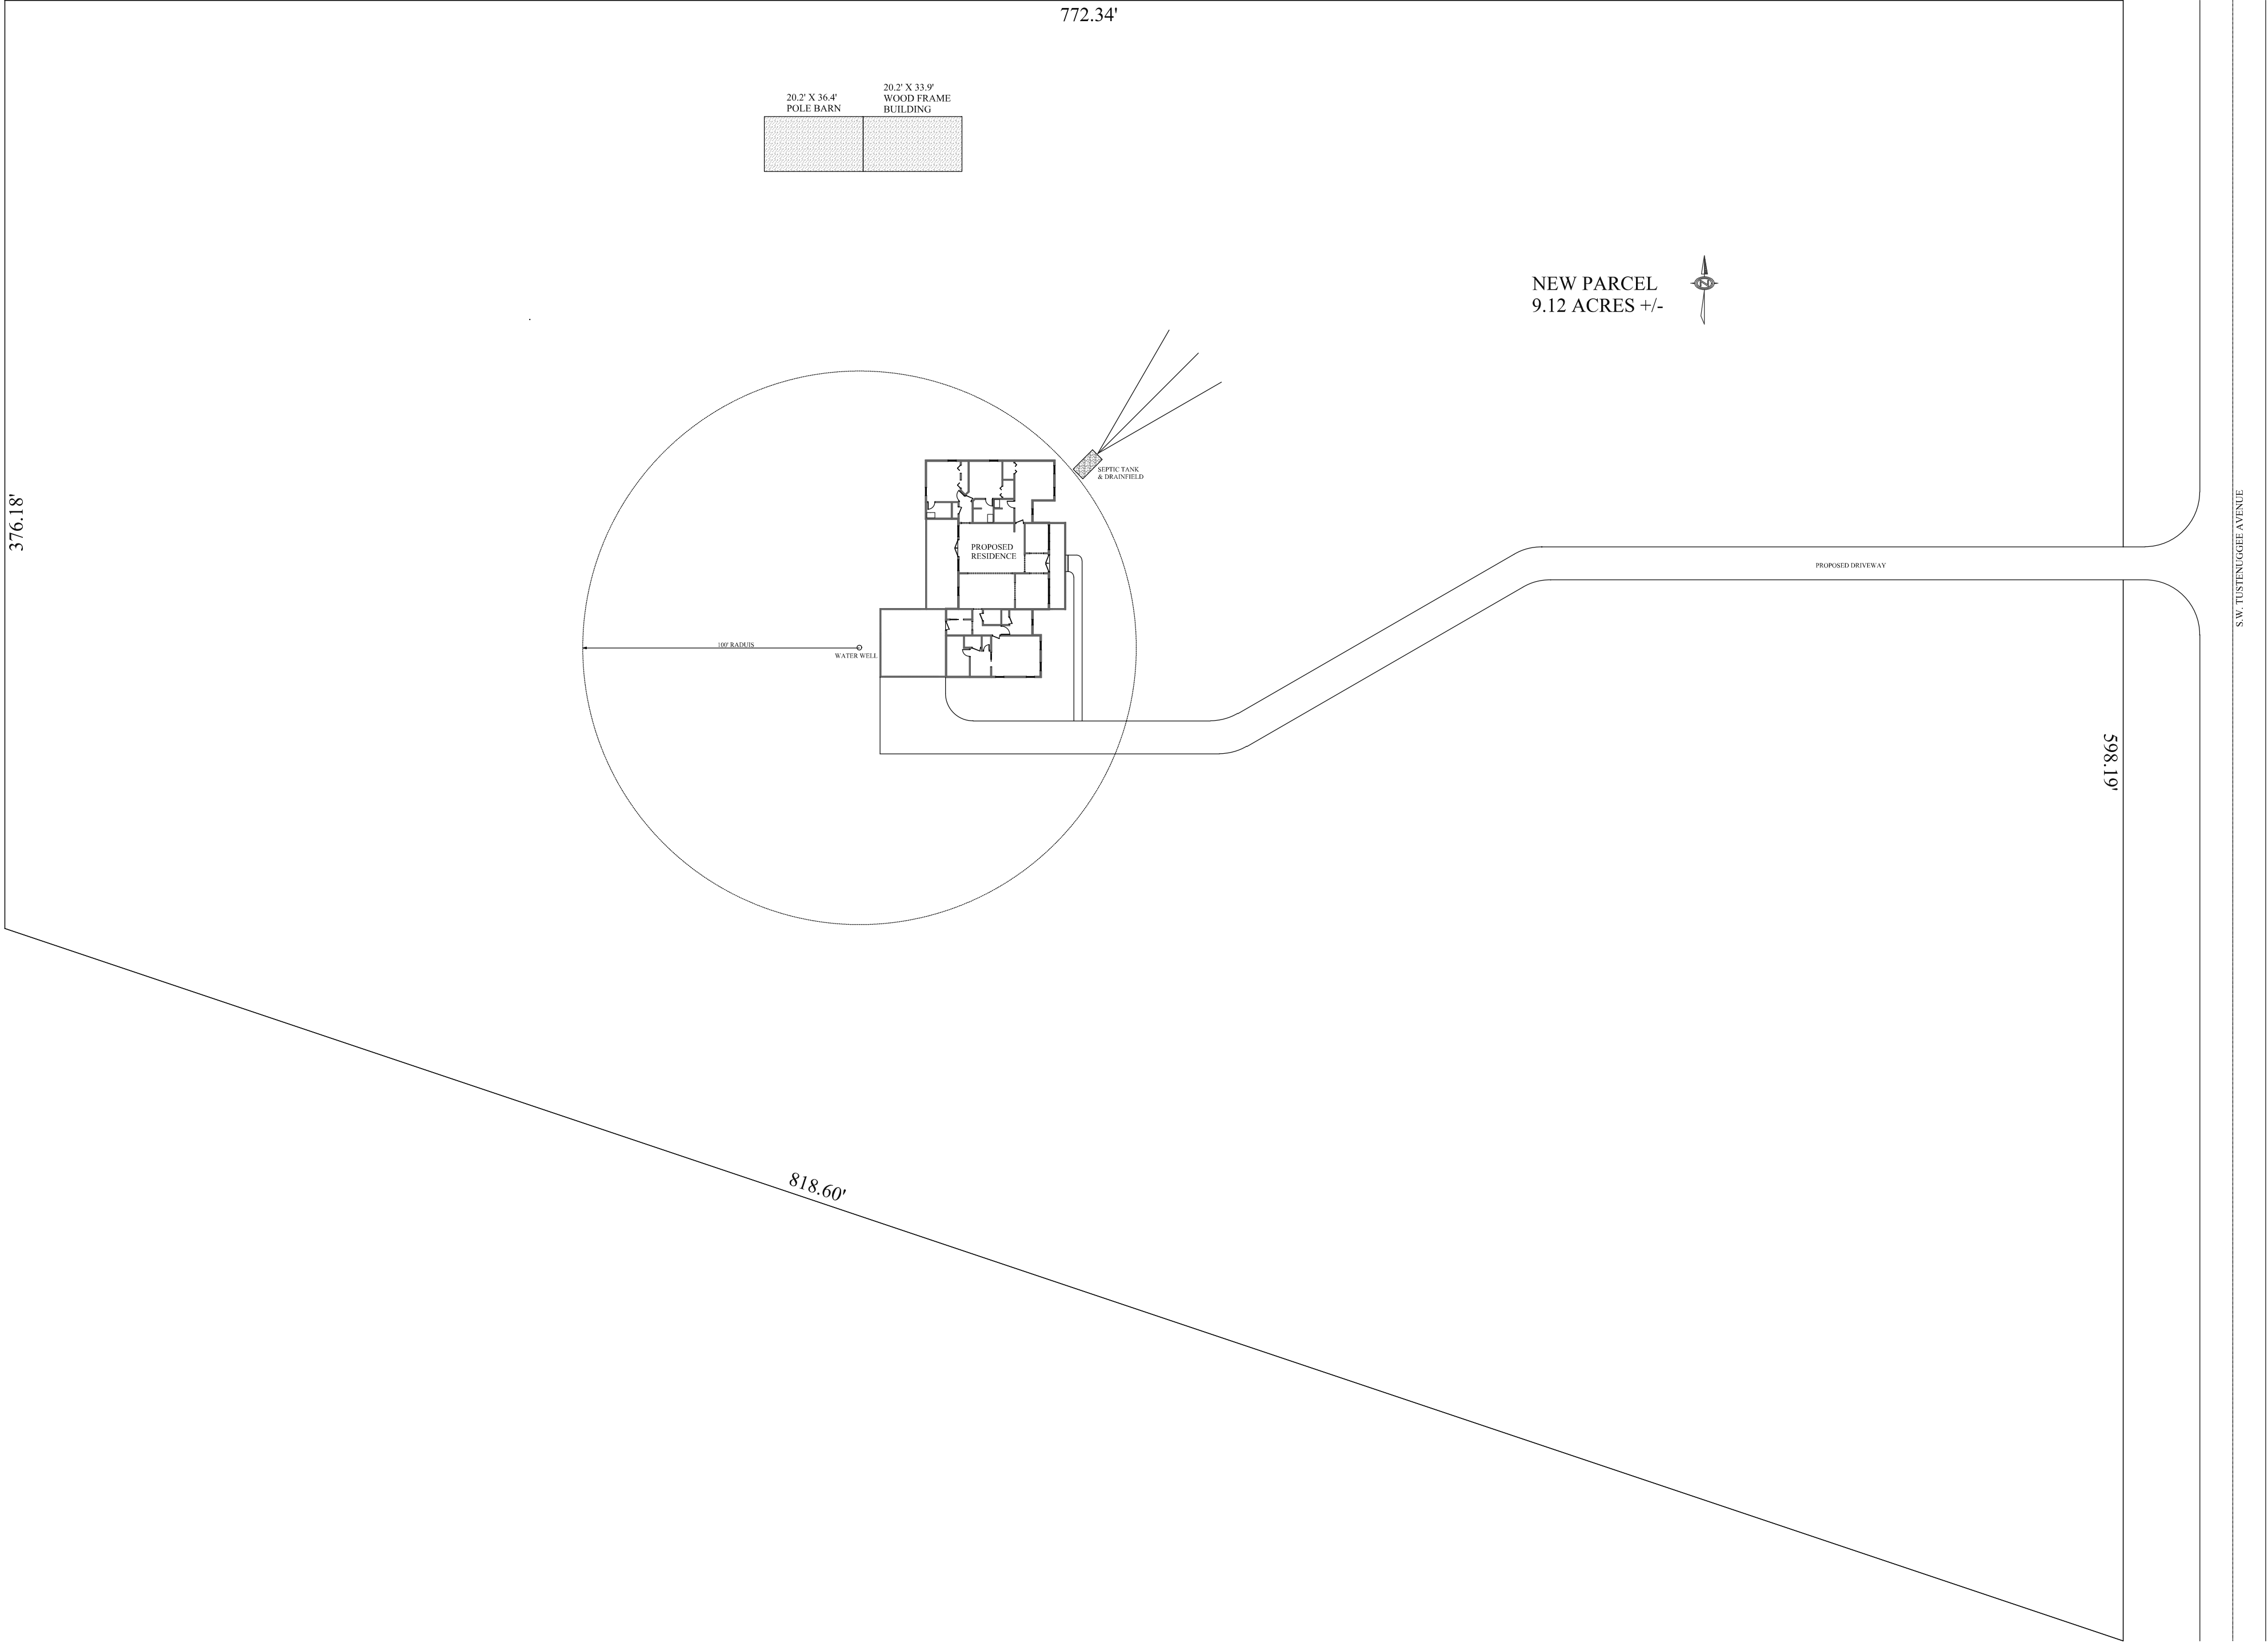

REVISIONS:

212 SE HICKORY DR  
LAKE CITY, FLORIDA 32025  
386-752-7578  
WWW.ONEALCOMPANIES.COM

**O'NEAL COMPANIES**  
O'NEAL CONTRACTING INC. CBC057550

**MR. & MRS. GREGORY O'NEAL RESIDENCE**  
**LAKE CITY, FLORIDA**

SITE PLAN

DATE: OCTOBER 16, 2023


DRAWN BY: MD

APPROVED BY:

SCALE: 1/4" = 1'-0"

SHEET:

1 of 6

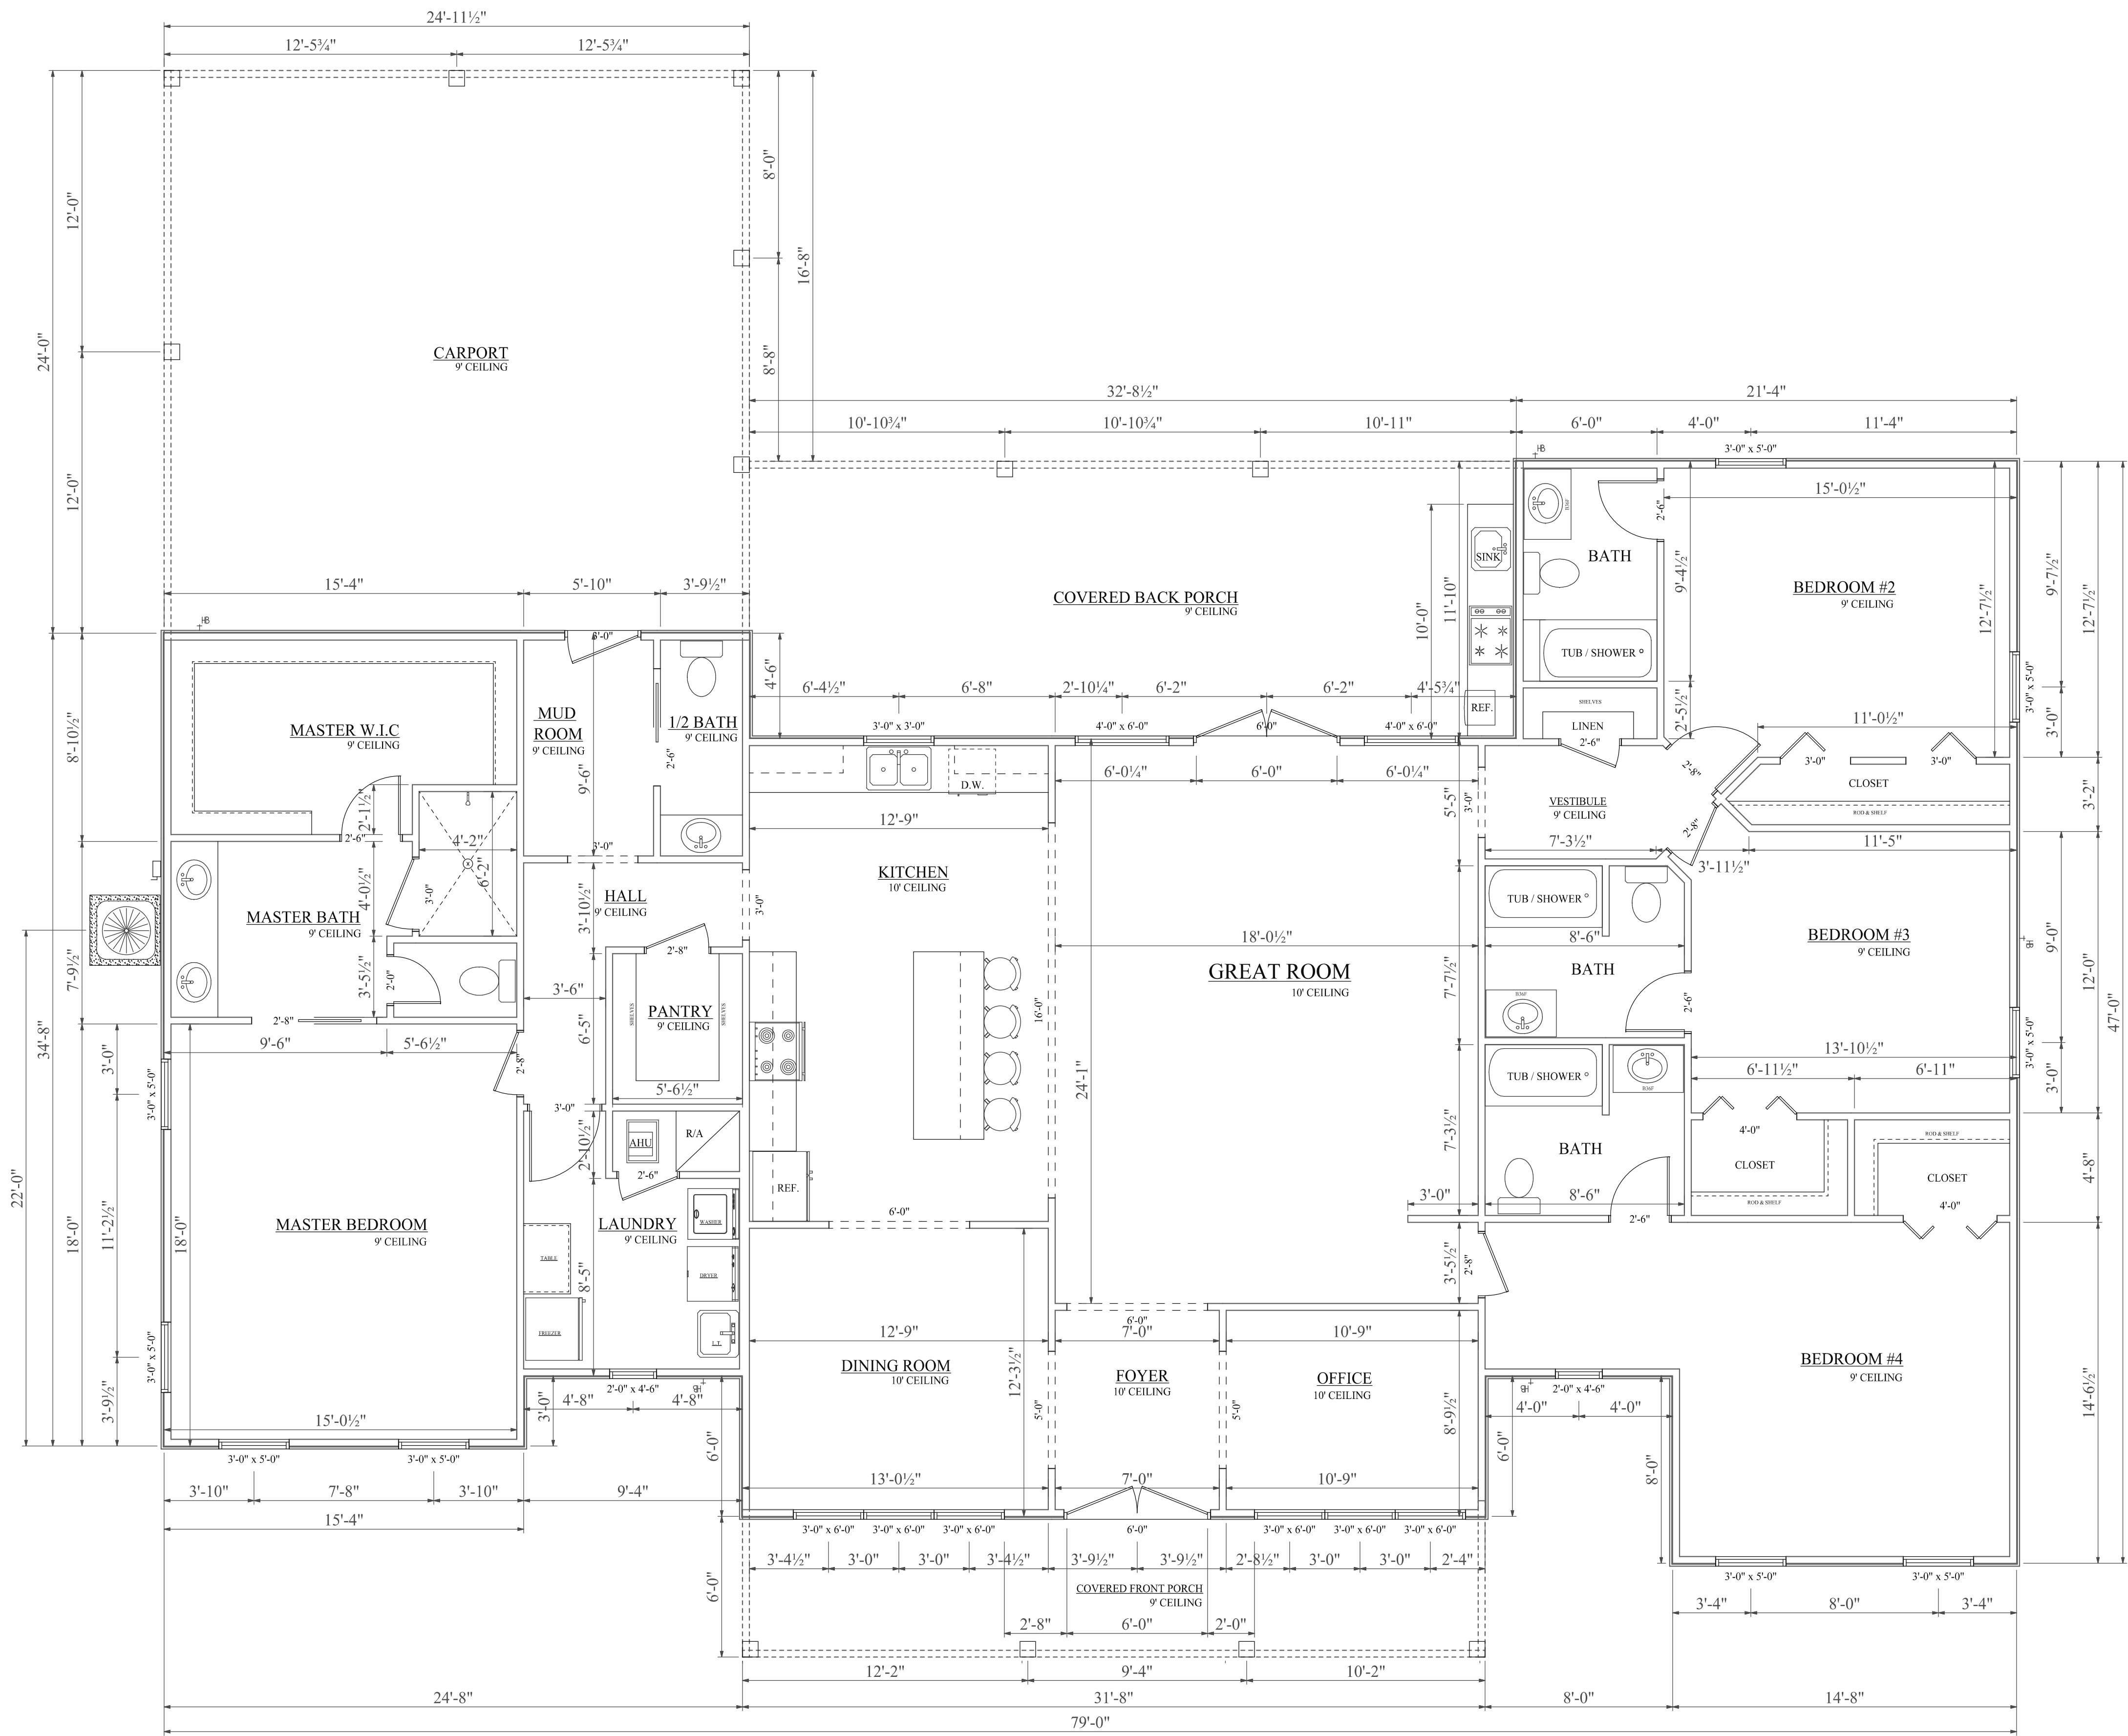

| AREA SUMMARY                |               |
|-----------------------------|---------------|
| HEATED                      | 2,899 sq. ft. |
| CARPORT                     | 596 sq. ft.   |
| BACK PORCH                  | 386 sq. ft.   |
| FRONT PORCH                 | 186 sq. ft.   |
| TOTAL SQ. FT. 4,067 sq. ft. |               |

REVISIONS:

212 SE HICKORY DR  
LAKE CITY, FLORIDA 32025  
386-752-7578  
WWW.ONEALCOMPANIES.COM

O'NEAL COMPANIES  
ONEAL CONTRACTING INC. CBC057550

MR. & MRS. GREGORY O'NEAL RESIDENCE  
LAKE CITY, FLORIDA

FLOOR PLAN

DATE: OCTOBER 16, 2023

DRAWN BY: MD

APPROVED BY:

SCALE: 1/4" = 1'-0"

SHEET:

2 of 6



REAR ELEVATION  
SCALE: 1/4" = 1'-0"



FRONT ELEVATION  
SCALE: 1/4" = 1'-0"

REVISIONS:

212 SE HICKORY DR  
LAKE CITY, FLORIDA 32025  
386-752-7578  
WWW.ONEALCOMPANIES.COM

O'NEAL COMPANIES  
O'NEAL CONTRACTING INC. CBC057550

MR. & MRS. GREGORY O'NEAL RESIDENCE  
LAKE CITY, FLORIDA

ELEVATIONS

DATE: OCTOBER 16, 2023


DRAWN BY: MD

APPROVED BY:

SCALE: 1/4" = 1'-0"

SHEET:

3 of 6

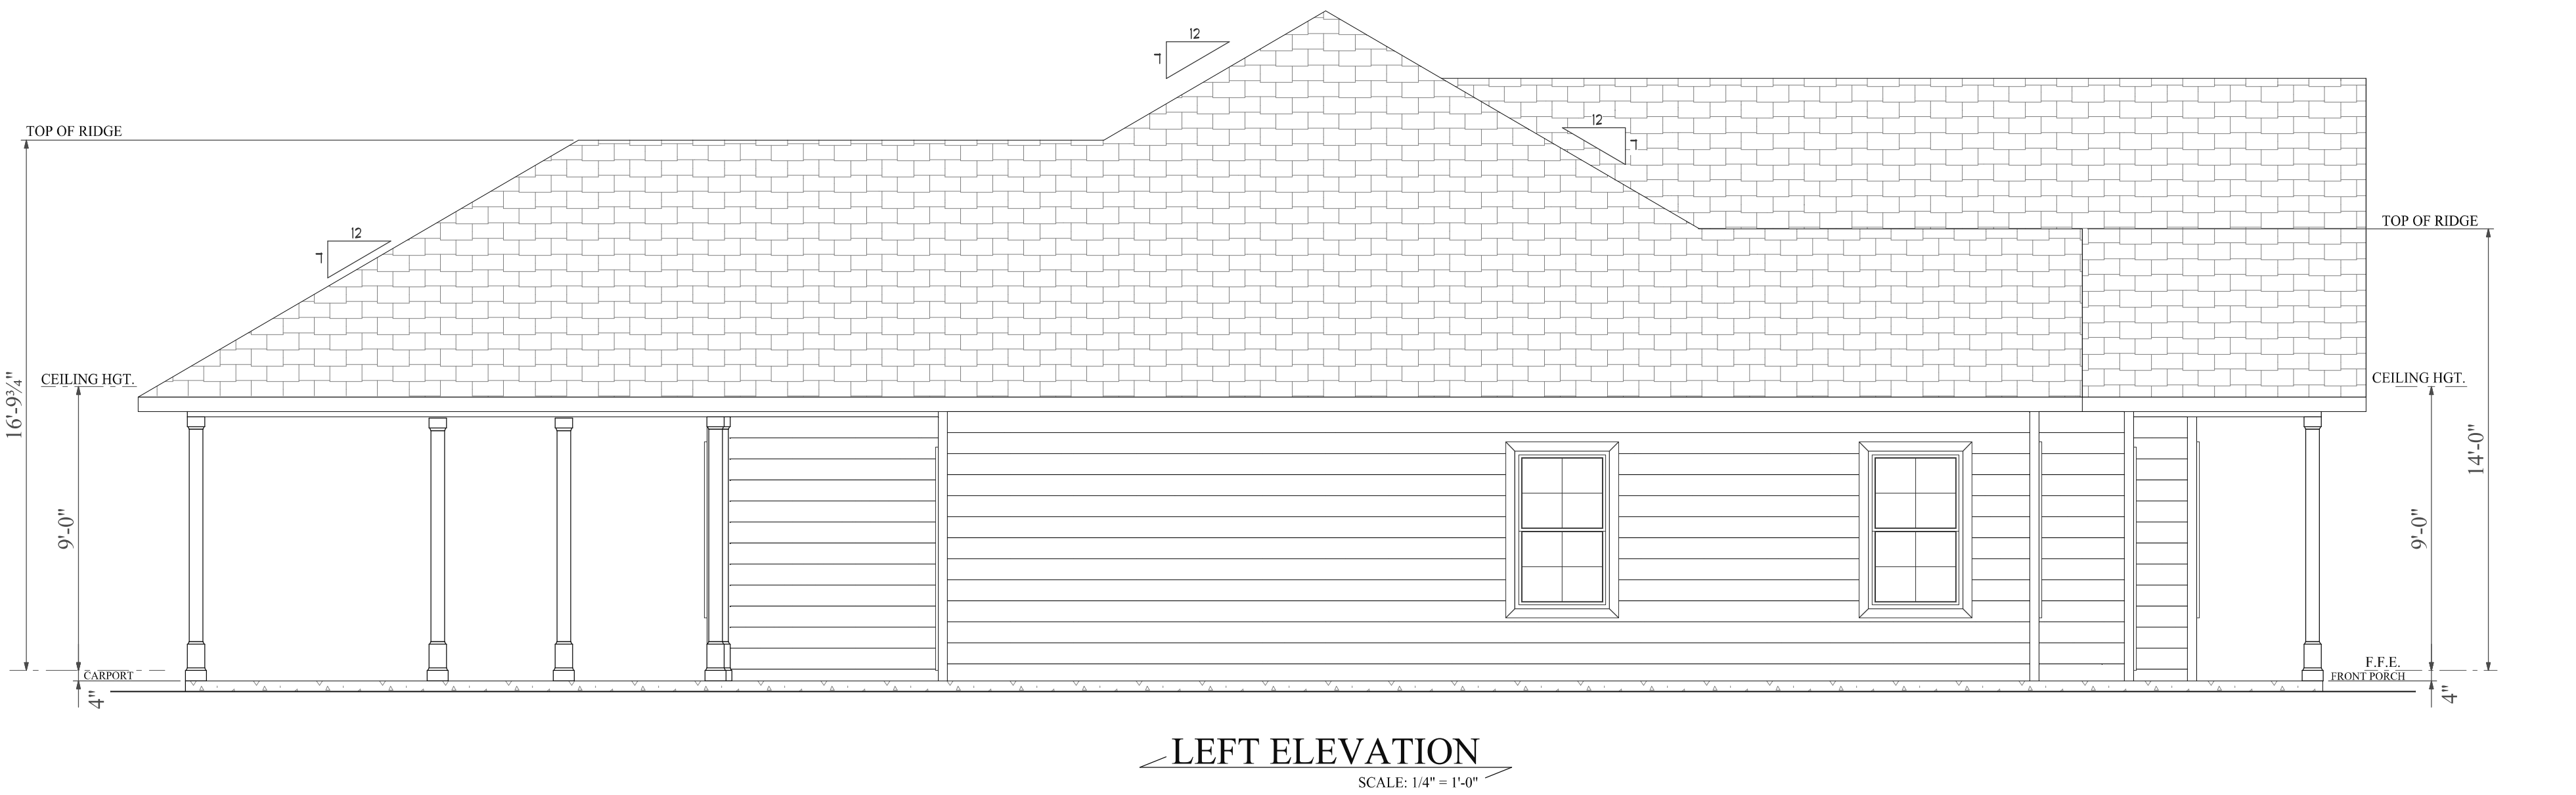

REVISIONS:

212 SE HICKORY DR  
LAKE CITY, FLORIDA 32025  
386-752-7578  
WWW.ONEALCOMPANIES.COM

O'NEAL COMPANIES

O'NEAL CONTRACTING INC. CBC057550

MR. & MRS. GREGORY O'NEAL RESIDENCE  
LAKE CITY, FLORIDA

ELEVATIONS

DATE: OCTOBER 16, 2023


 
DRAWN BY: MD

APPROVED BY:

SCALE: 1/4" = 1'-0"


SHEET:

4 of 6
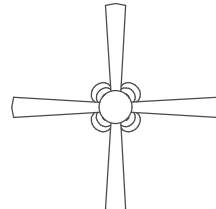
| ELECTRICAL                       | COUNT | SYMBOL                                                                              |
|----------------------------------|-------|-------------------------------------------------------------------------------------|
| ceiling fan w/light kits         | 7     |    |
| light                            | 46    |    |
| dining room light                | 1     |    |
| security lights                  | 5     |    |
| electrical meter                 | 1     |    |
| electrical panel                 | 1     |    |
| exhaust fan/bathroom             | 6     |    |
| water proof light                | 2     |    |
| 110v outlet                      | 44    |    |
| 220v outlet                      | 3     |    |
| outlet gfi 110v                  | 13    |    |
| outlet wp 110v                   | 3     |    |
| smoke / carbon monoxide detector | 9     |   |
| single pole switch               | 33    |  |
| switch 3 way                     | 6     |  |
| switch 4 way                     | 9     |  |
| master bath vanity light         | 1     |  |
| bathroom vanity light            | 4     |  |

ELECTRICAL NOTES:

ELECTRICAL CONTRACTOR SHALL PREPARE "AS-BUILT" SHOP DRAWINGS INDICATING ALL ELECTRICAL WORK, INCLUDING ANY CHANGES TO THE ELECTRICAL PLAN, ADDITIONS TO THE ELECTRICAL PLAN, RISER DIAGRAM, AS-BUILT PANEL SCHEDULE, W/ ALL CIRCUITS IDENTIFIED W/ CIRCUIT NUMBER, DESCRIPTION & BREAKER. SERVICE ENTRANCE & ALL UNDERGROUND WIRE LOCATIONS RISER DIAGRAM SHALL INCLUDE WIRE SIZE, TYPE AND EQUIPMENT TYPE, W/ RATINGS & LOADS. CONTRACTOR SHALL PROVIDE 1 COPY OF AS-BUILT DRAWINGS TO OWNER & 1 COPY TO THE PERMIT ISSUING AUTHORITY. TELEPHONE, TELEVISION AND OTHER LOW VOLTAGE DEVICES OR OUTLETS SHALL BE AS PER THE OWNER'S DIRECTIONS, & IN ACCORDANCE W/ APPLICABLE SECTIONS OF THE N.E.C. LATEST EDITION. ALL SMOKE/ CARBON MONOXIDE DETECTORS SHALL BE 120V W/ BATTERY BACKUP OF THE PHOTOELECTRIC TYPE, AND SHALL BE INTERLOCKED TOGETHER. LOCATION OF AUDIO WIRES PER OWNER REQUEST.

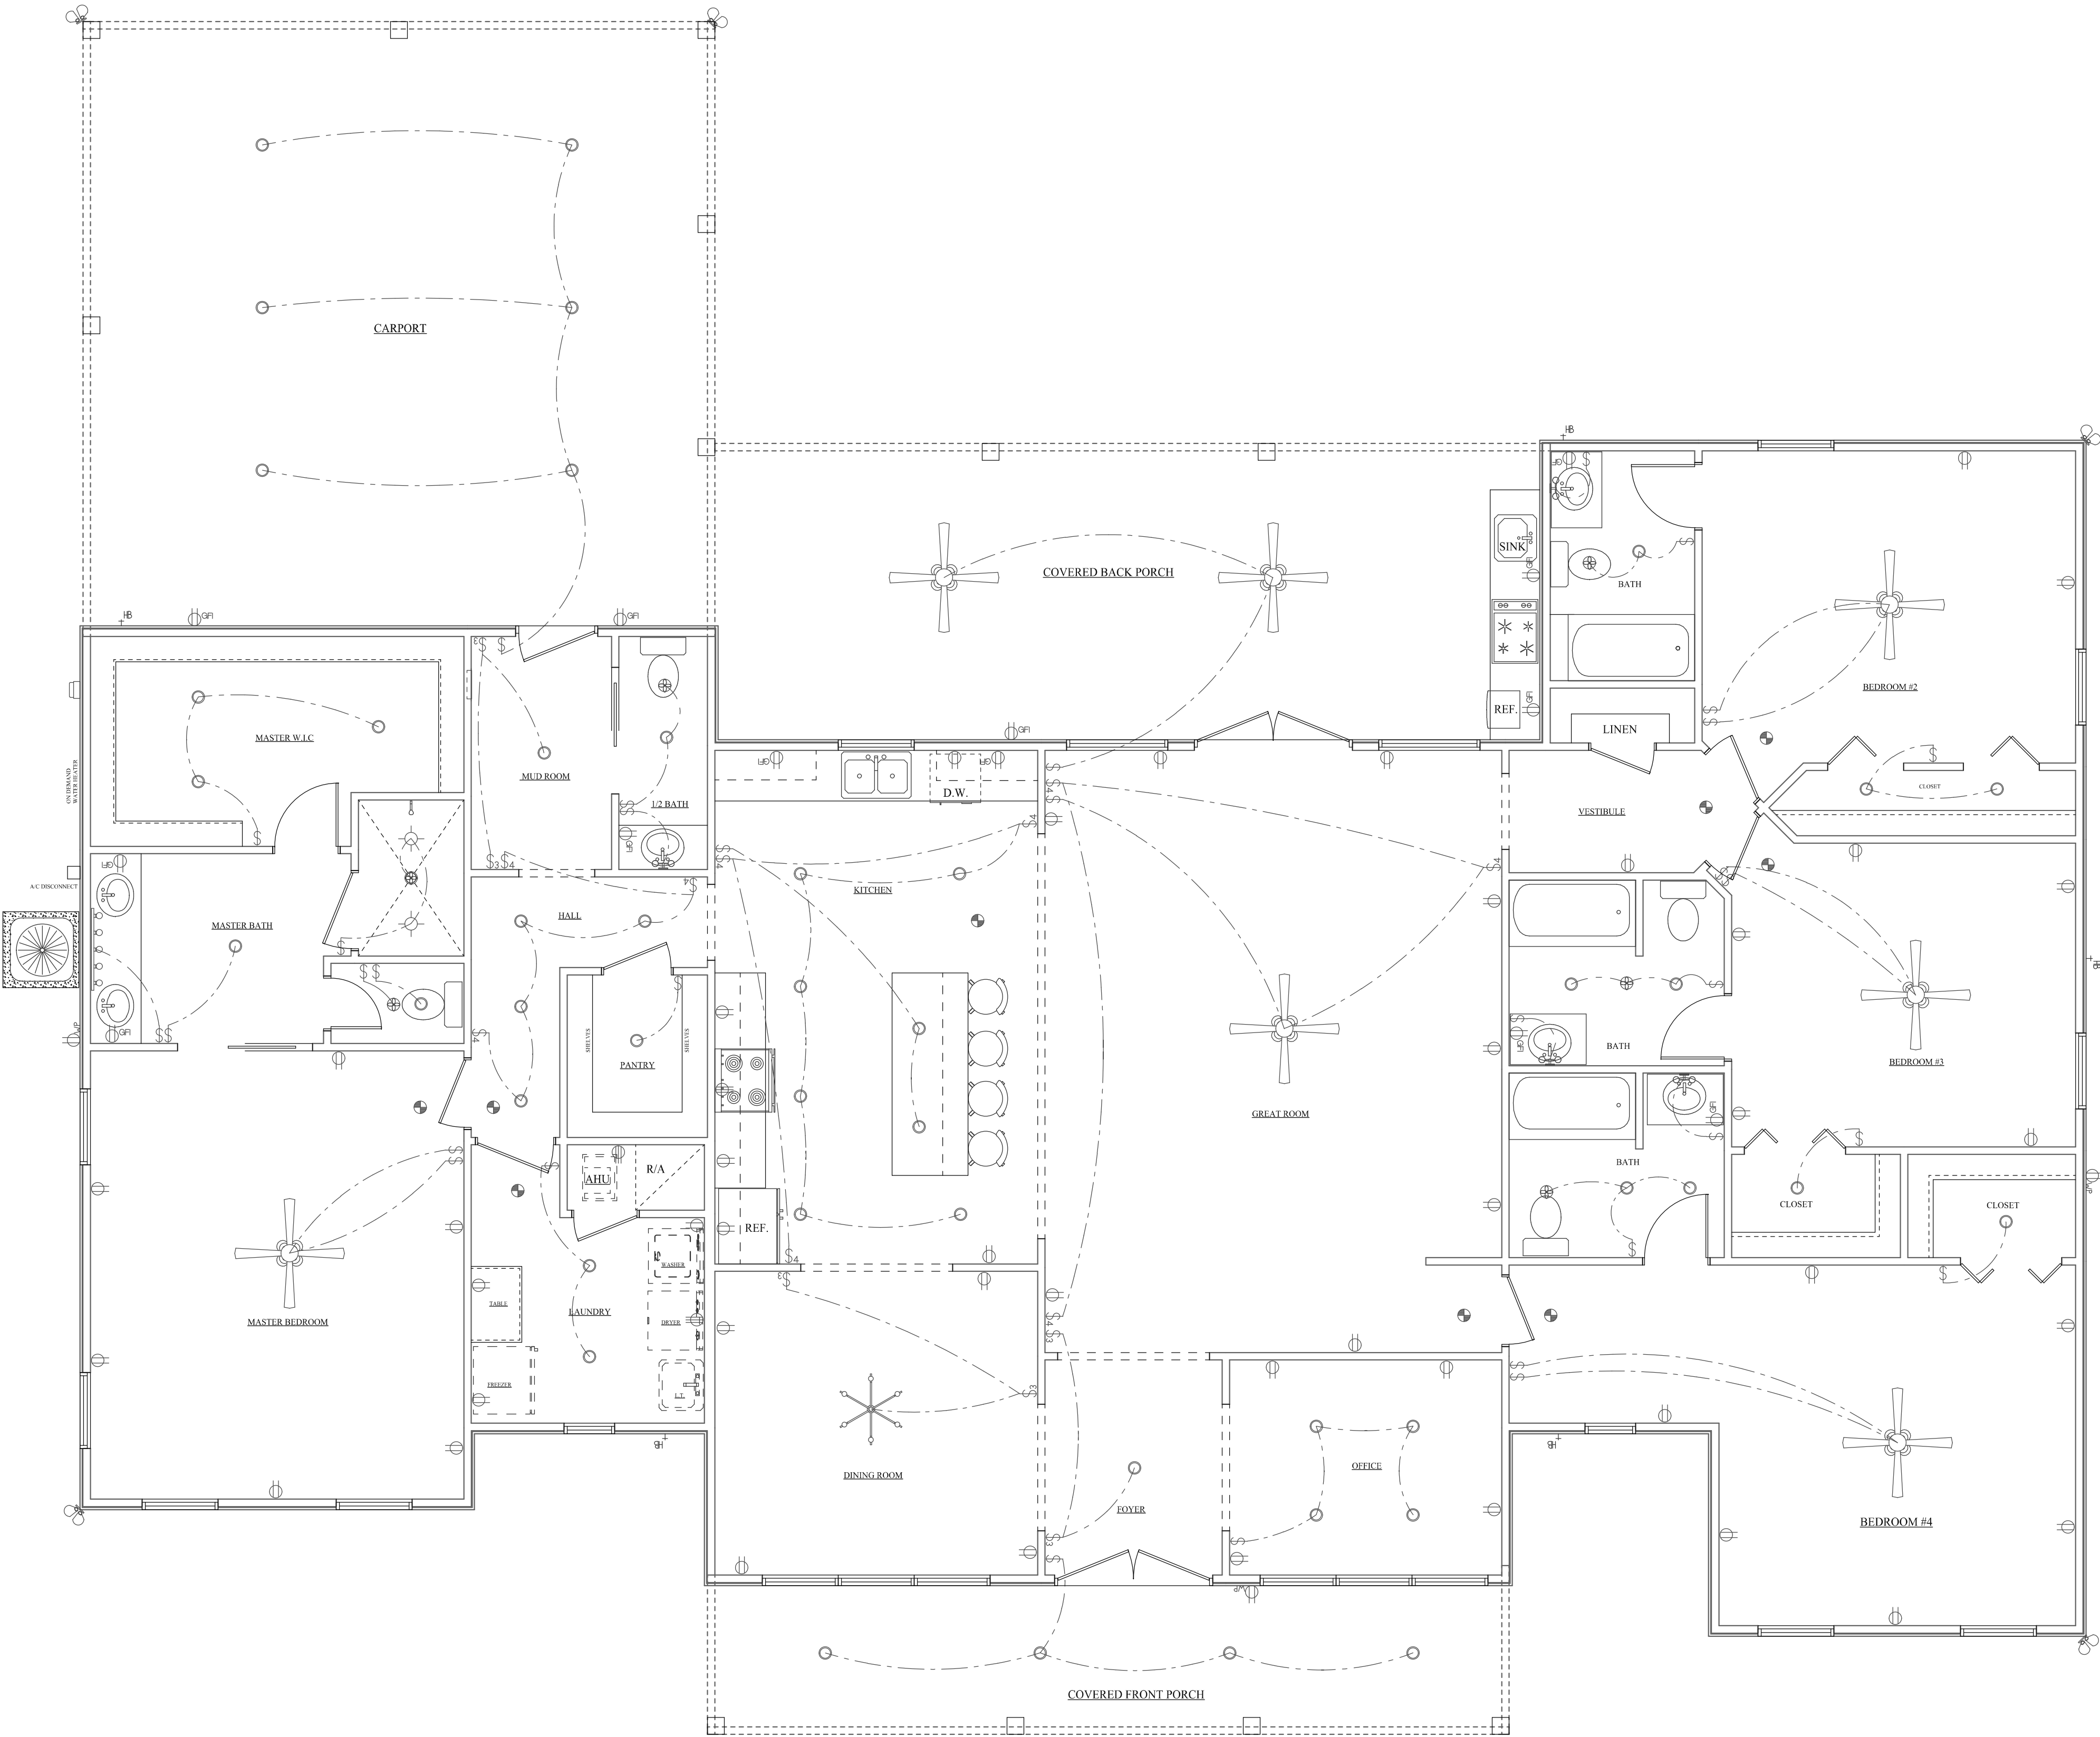

REVISIONS:

212 SE HICKORY DR  
LAKE CITY, FLORIDA 32025  
386-752-7578  
WWW.ONEALCOMPANIES.COM

O'NEAL COMPANIES  
O'NEAL CONTRACTING INC. CBC057550

MR. & MRS. GREGORY O'NEAL RESIDENCE  
LAKE CITY, FLORIDA

ELECTRICAL  
PLAN


DATE: OCTOBER 16, 2023

DRAWN BY: MD

APPROVED BY:

SCALE: 1/4" = 1'-0"

SHEET:

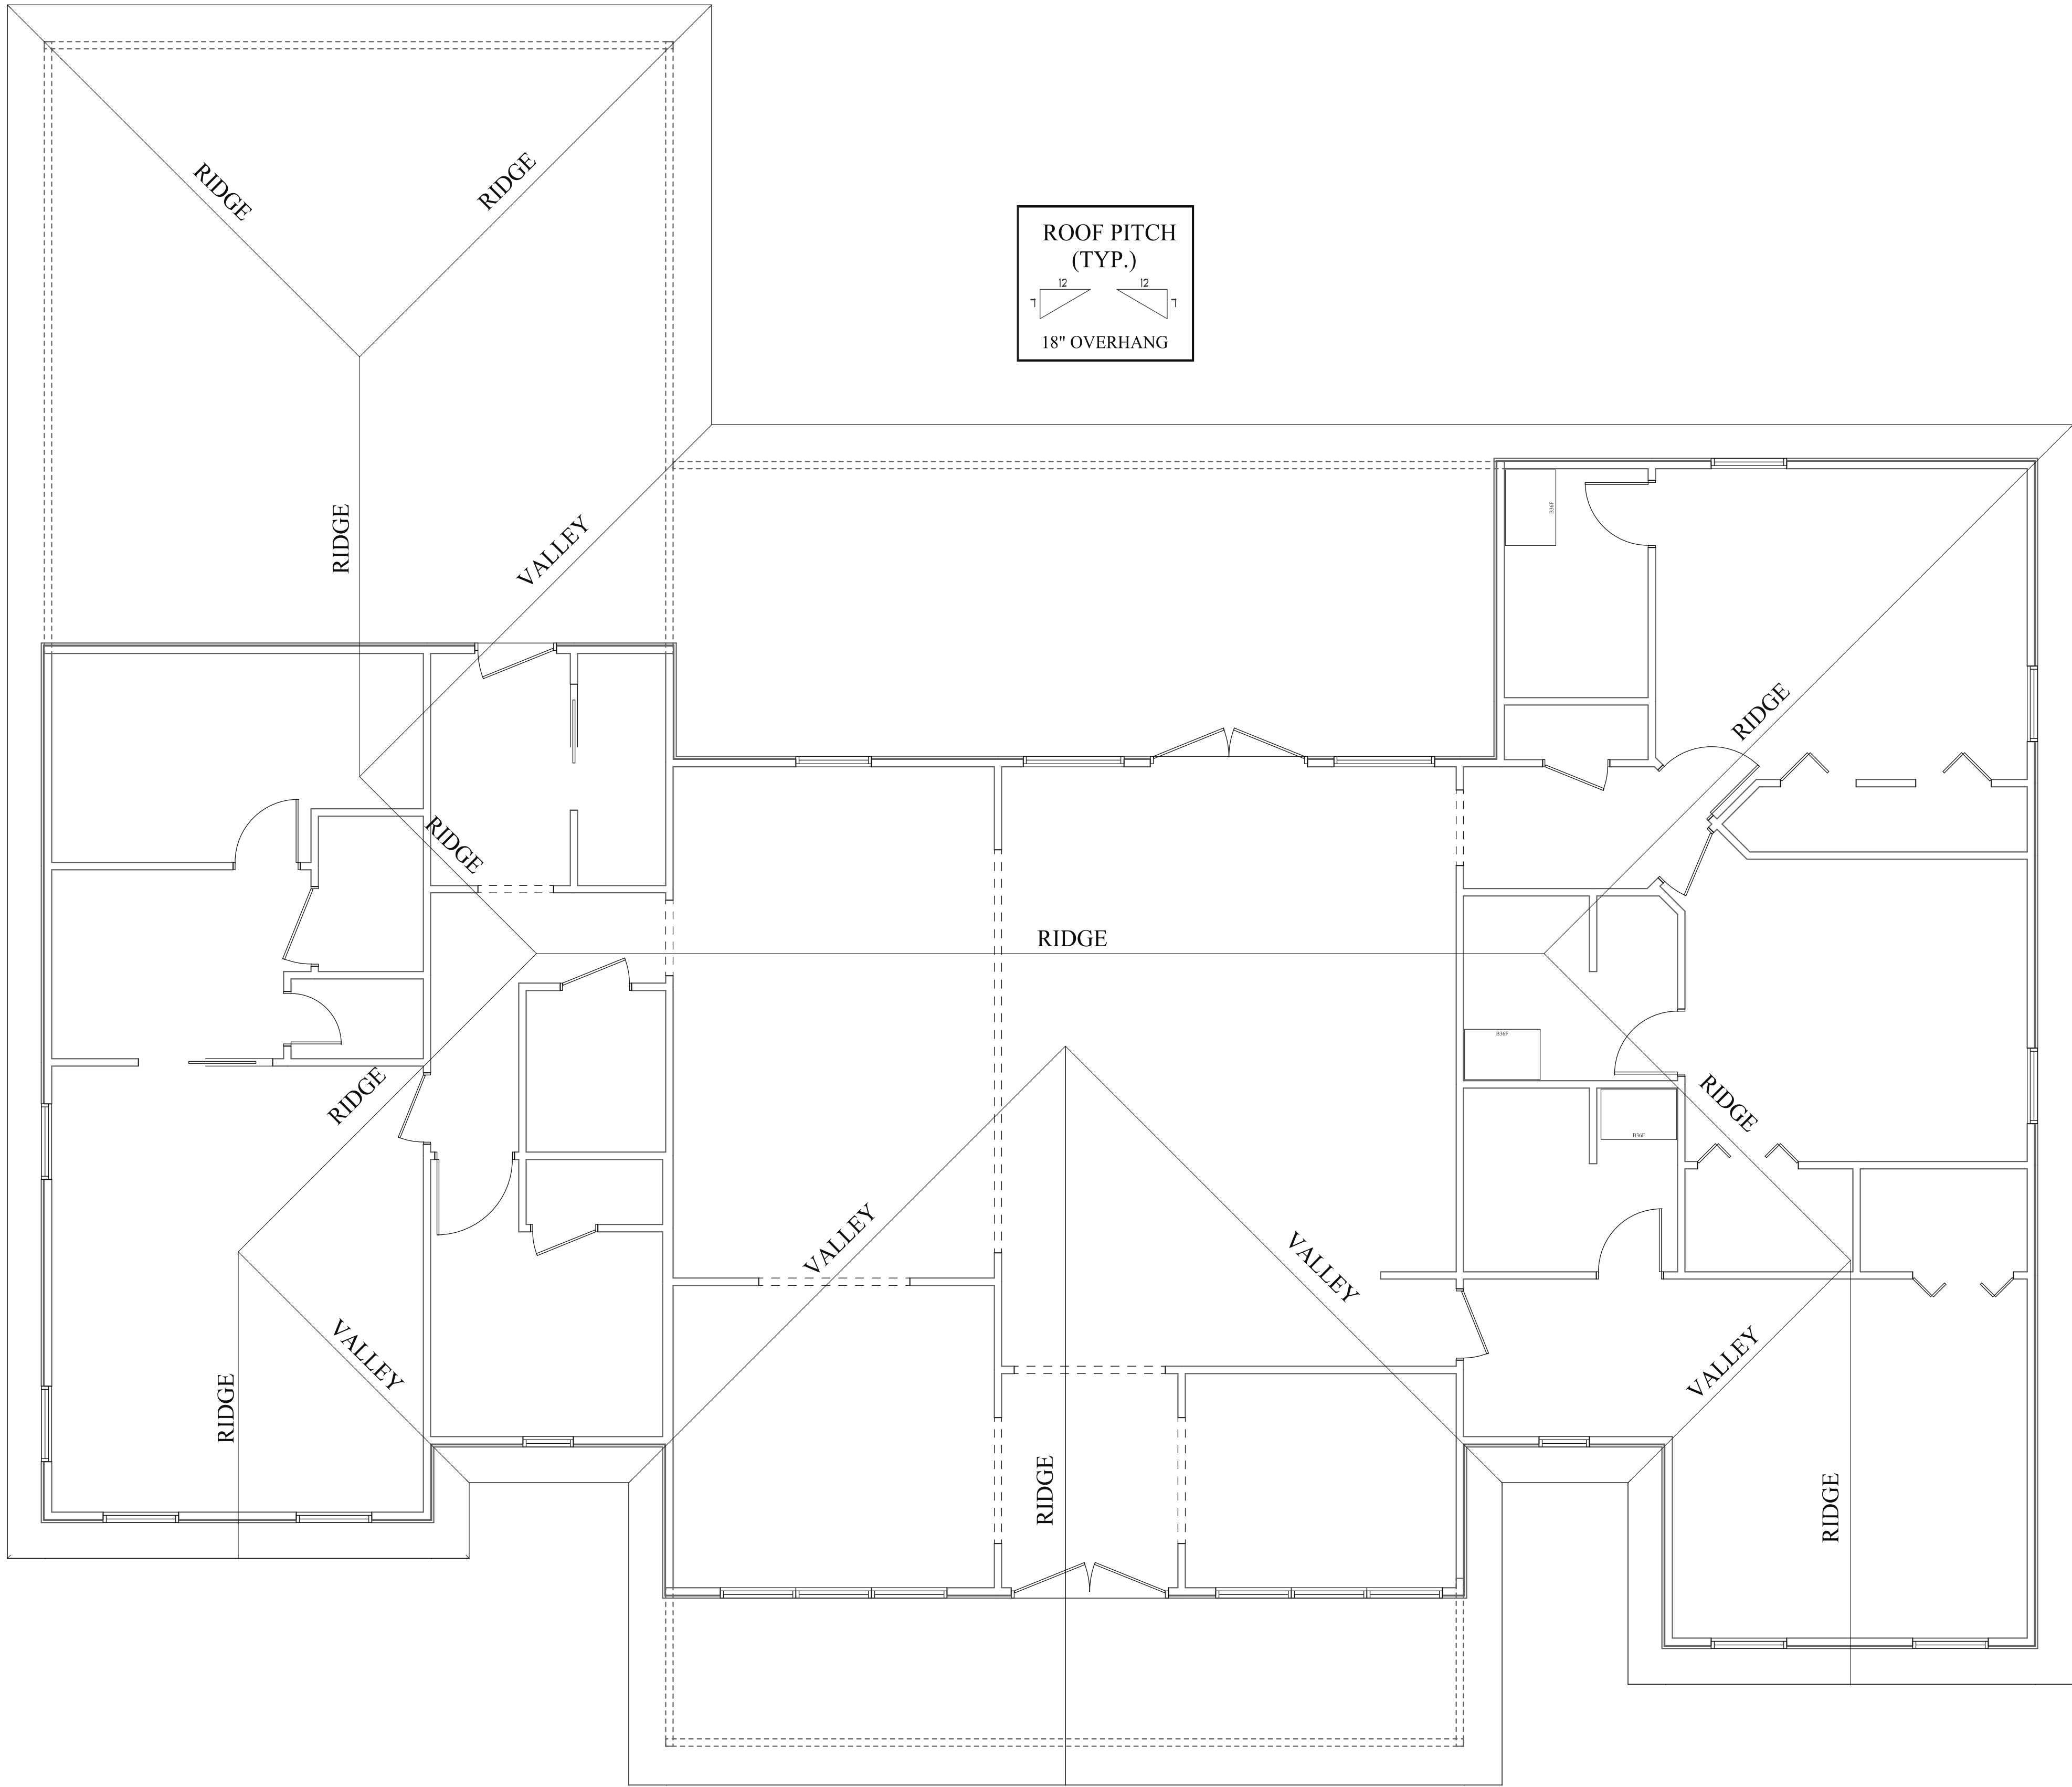

REVISIONS:

212 SE HICKORY DR  
LAKE CITY, FLORIDA 32025  
386-752-7578  
WWW.ONEALCOMPANIES.COM

O'NEAL COMPANIES

O'NEAL CONTRACTING INC. CBC057550

MR. & MRS. GREGORY O'NEAL RESIDENCE

LAKE CITY, FLORIDA

ELECTRICAL  
PLAN

DATE: OCTOBER 16, 2023

DRAWN BY: MD

APPROVED BY:

SCALE: 1/4" = 1'-0"

SHEET: